




# University of Louisville - Student Recreation Center (Phase #3 - Construction Set) Louisville, Ky

 212 North Upper Street Lexington, Kentucky 40507-1001 p 859.252.6864 f 859.253.2388 www.omniarchitects.com			
Drawing Name: OVERALL ROOF DRAIN PLAN		Revision Date: Jan 24, 2012	
U of L Project Number: Omni - 1105.00 Cannon - 08667.00		Date: March 02, 2012	
Drawn By: VPP		Checked By: ANTHONY	



OVERALL ROOF DRAIN PLAN  
 SCALE: 1/16" = 1'-0"  
 1  
 S0140

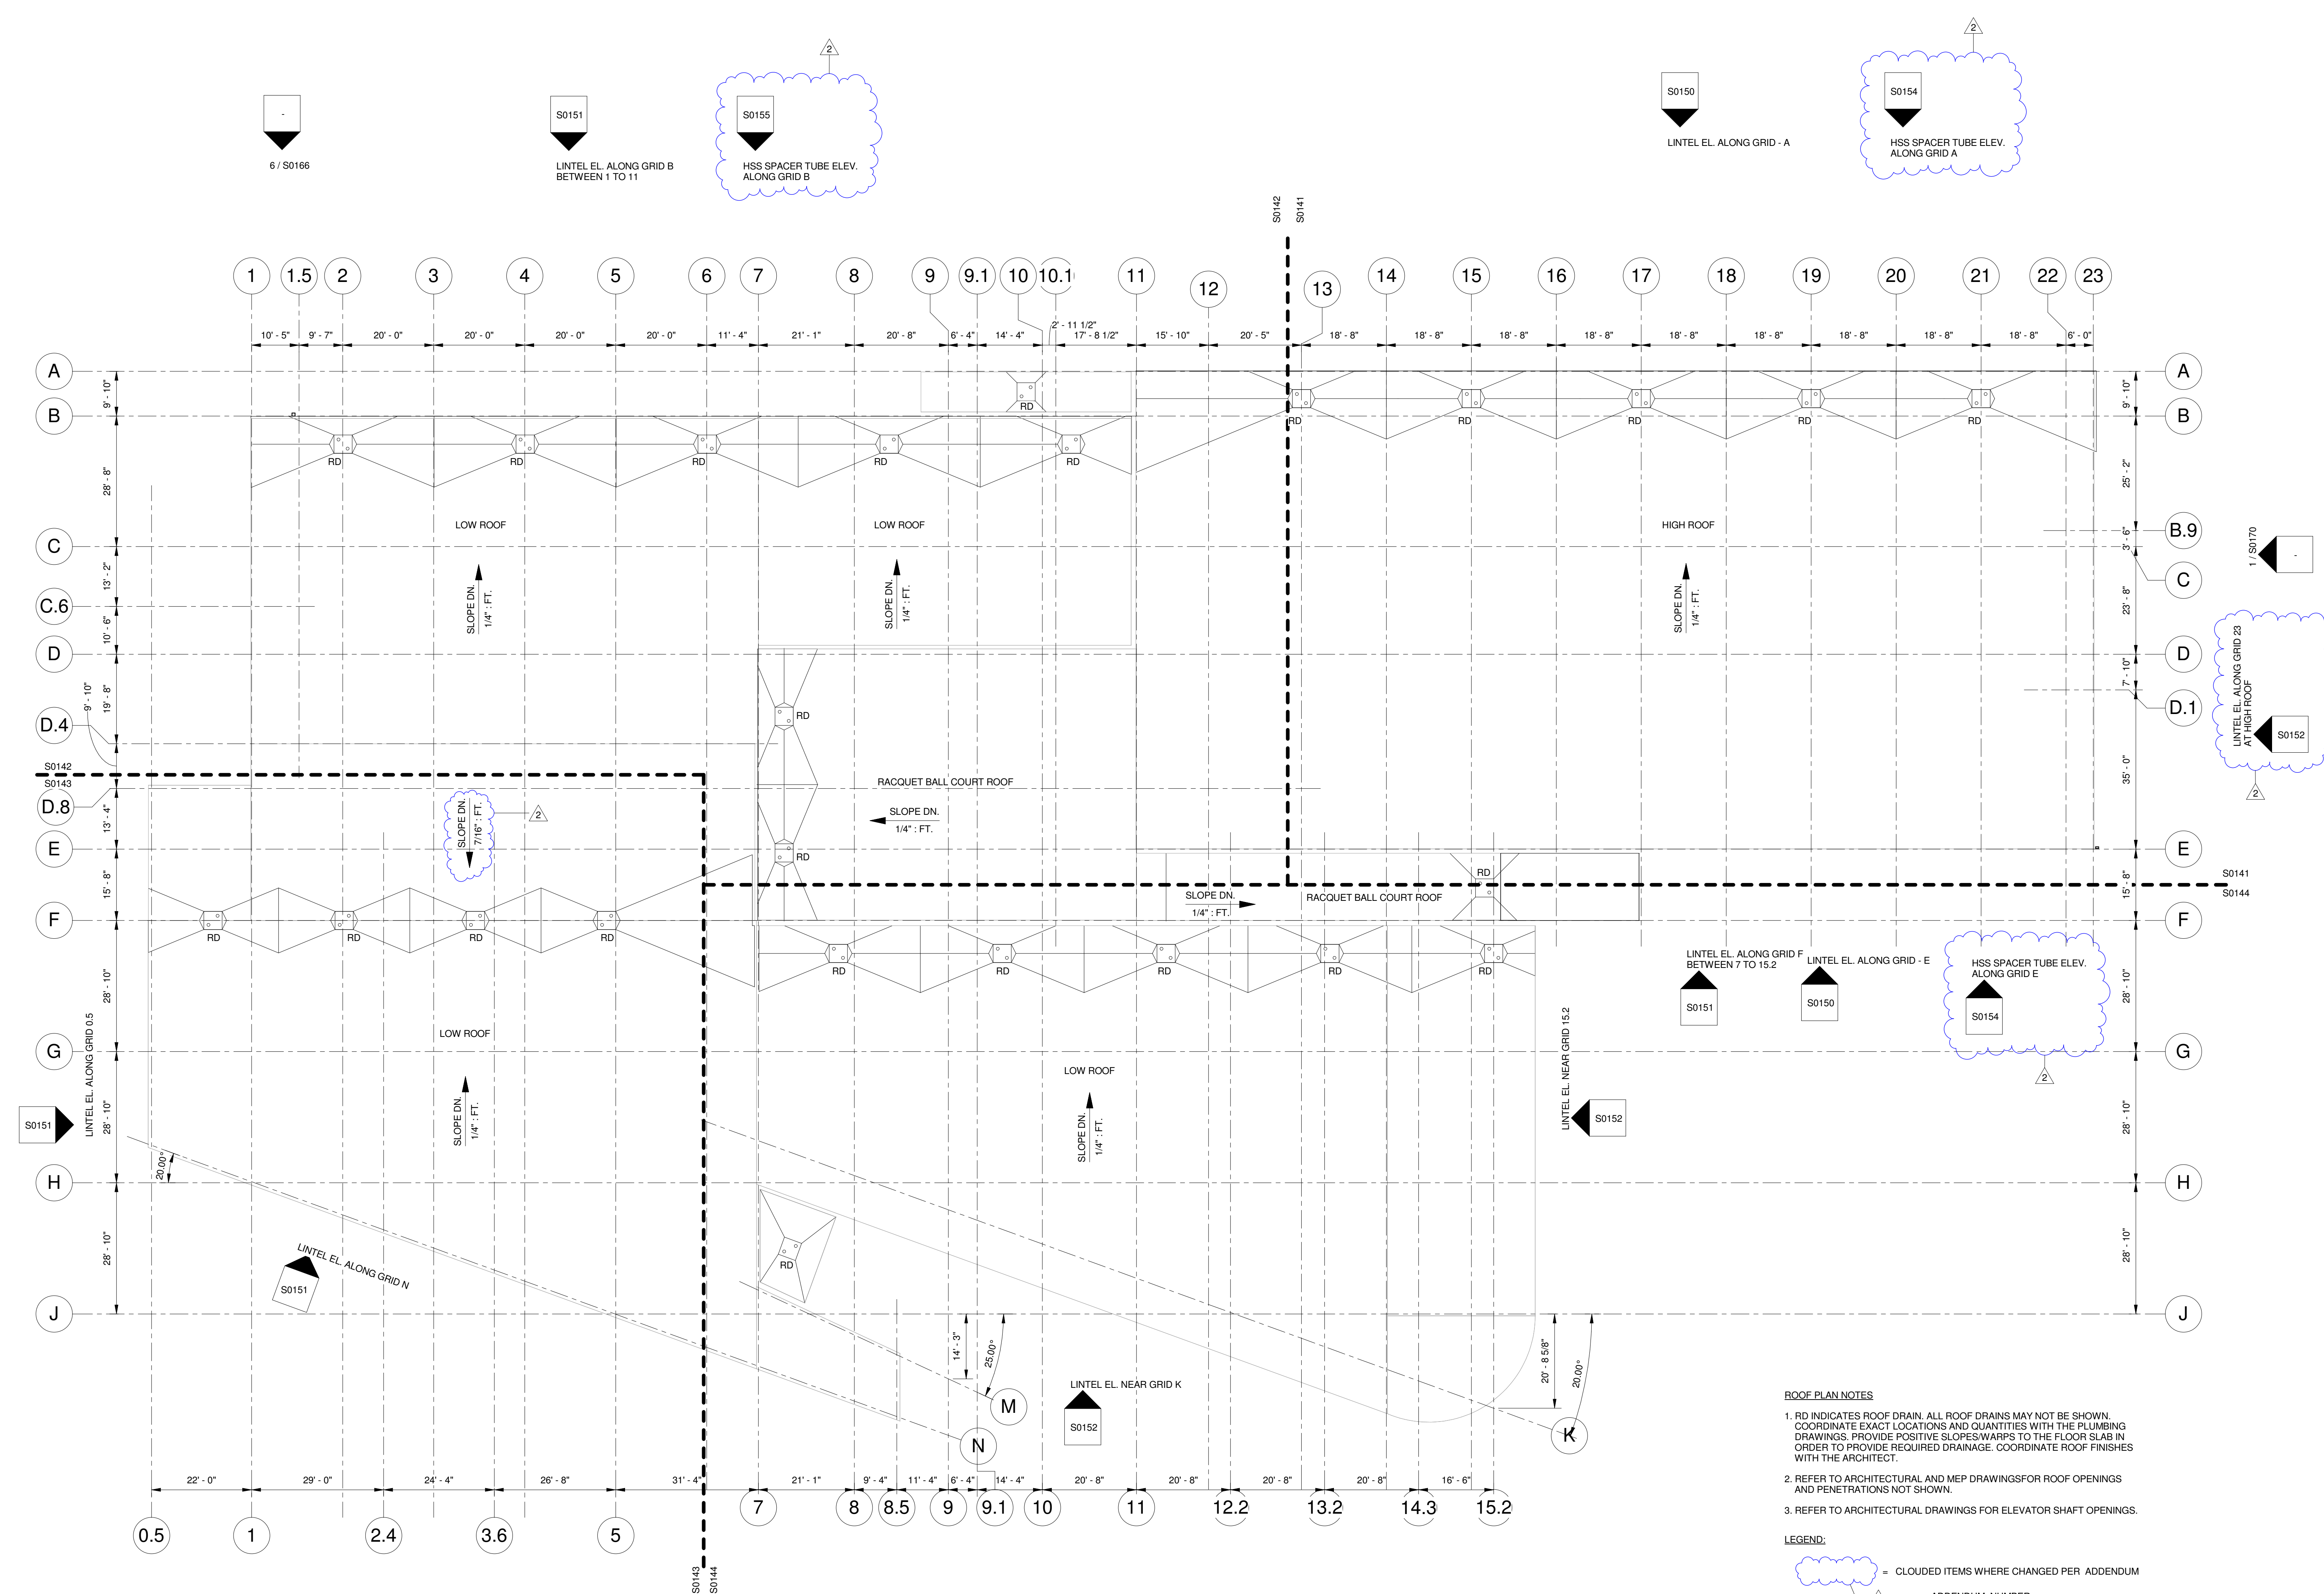**ROOF PLAN NOTES**


- RD INDICATES ROOF DRAIN. ALL ROOF DRAINS MAY NOT BE SHOWN. COORDINATE EXACT LOCATIONS AND QUANTITIES WITH THE PLUMBING DRAWINGS. PROVIDE POSITIVE SLOPES TOWARDS TO THE FLOOR SLAB IN ORDER TO PROVIDE REQUIRED DRAINAGE. COORDINATE ROOF FINISHES WITH THE ARCHITECT.
- REFER TO ARCHITECTURAL AND MEP DRAWINGS FOR ROOF OPENINGS AND PENETRATIONS NOT SHOWN.
- REFER TO ARCHITECTURAL DRAWINGS FOR ELEVATOR SHAFT OPENINGS.

**LEGEND:**

☁ = CLOUDED ITEMS WHERE CHANGED PER ADDENDUM  
 ↖ = ADDENDUM NUMBER

**DISCLAIMER NOTE:**  
 THIS SET OF CONSTRUCTION DRAWINGS HAS BEEN UPDATED TO INCLUDE ANY CHANGES ISSUED THROUGH ADDENDUM OR OTHER MEANS. EVERY EFFORT HAS BEEN TAKEN TO INCLUDE ALL CHANGES TO DATE. THE CONTRACTOR IS STILL RESPONSIBLE FOR PROVIDING ANY ITEMS THAT WERE SHOWN AS PART OF THE ORIGINAL BID SET THAT MAY HAVE BEEN OVERLOOKED AND NOT INCLUDED IN THIS SET.

© Cannon Design 2010  
 All rights reserved. No part of this document may be reproduced or utilized in any form without prior written authorization by The Cannon Corporation.  
 02-03-2012 16:15:15

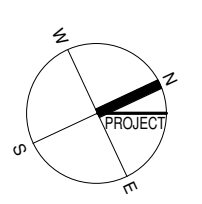

**S0140**