


University of Louisville - Student Recreational Facility (Bid Phase #4)

Drawing Name / Description	SITE UTILITY PLAN	#	Revision Date
U of L Project Number:		1	
A&E Project Number:		2	
Date:	JANUARY, 2012	3	
Drawn By:	SDS	4	
Checked By:	JLC / KLW	5	
		6	
		7	
		8	

CARMAN
Landscape Architecture • Land Planning • Site Engineering
310 OLD EAST VINE STREET LEXINGTON, KY 40506
P: (859) 254-9803 F: (859) 255-8625

Omni ARCHITECTS
212 North Upper Street
Lexington, Kentucky
40507-1001
P 859.252.6664
www.omniarchitects.com

SITE UTILITY PLAN

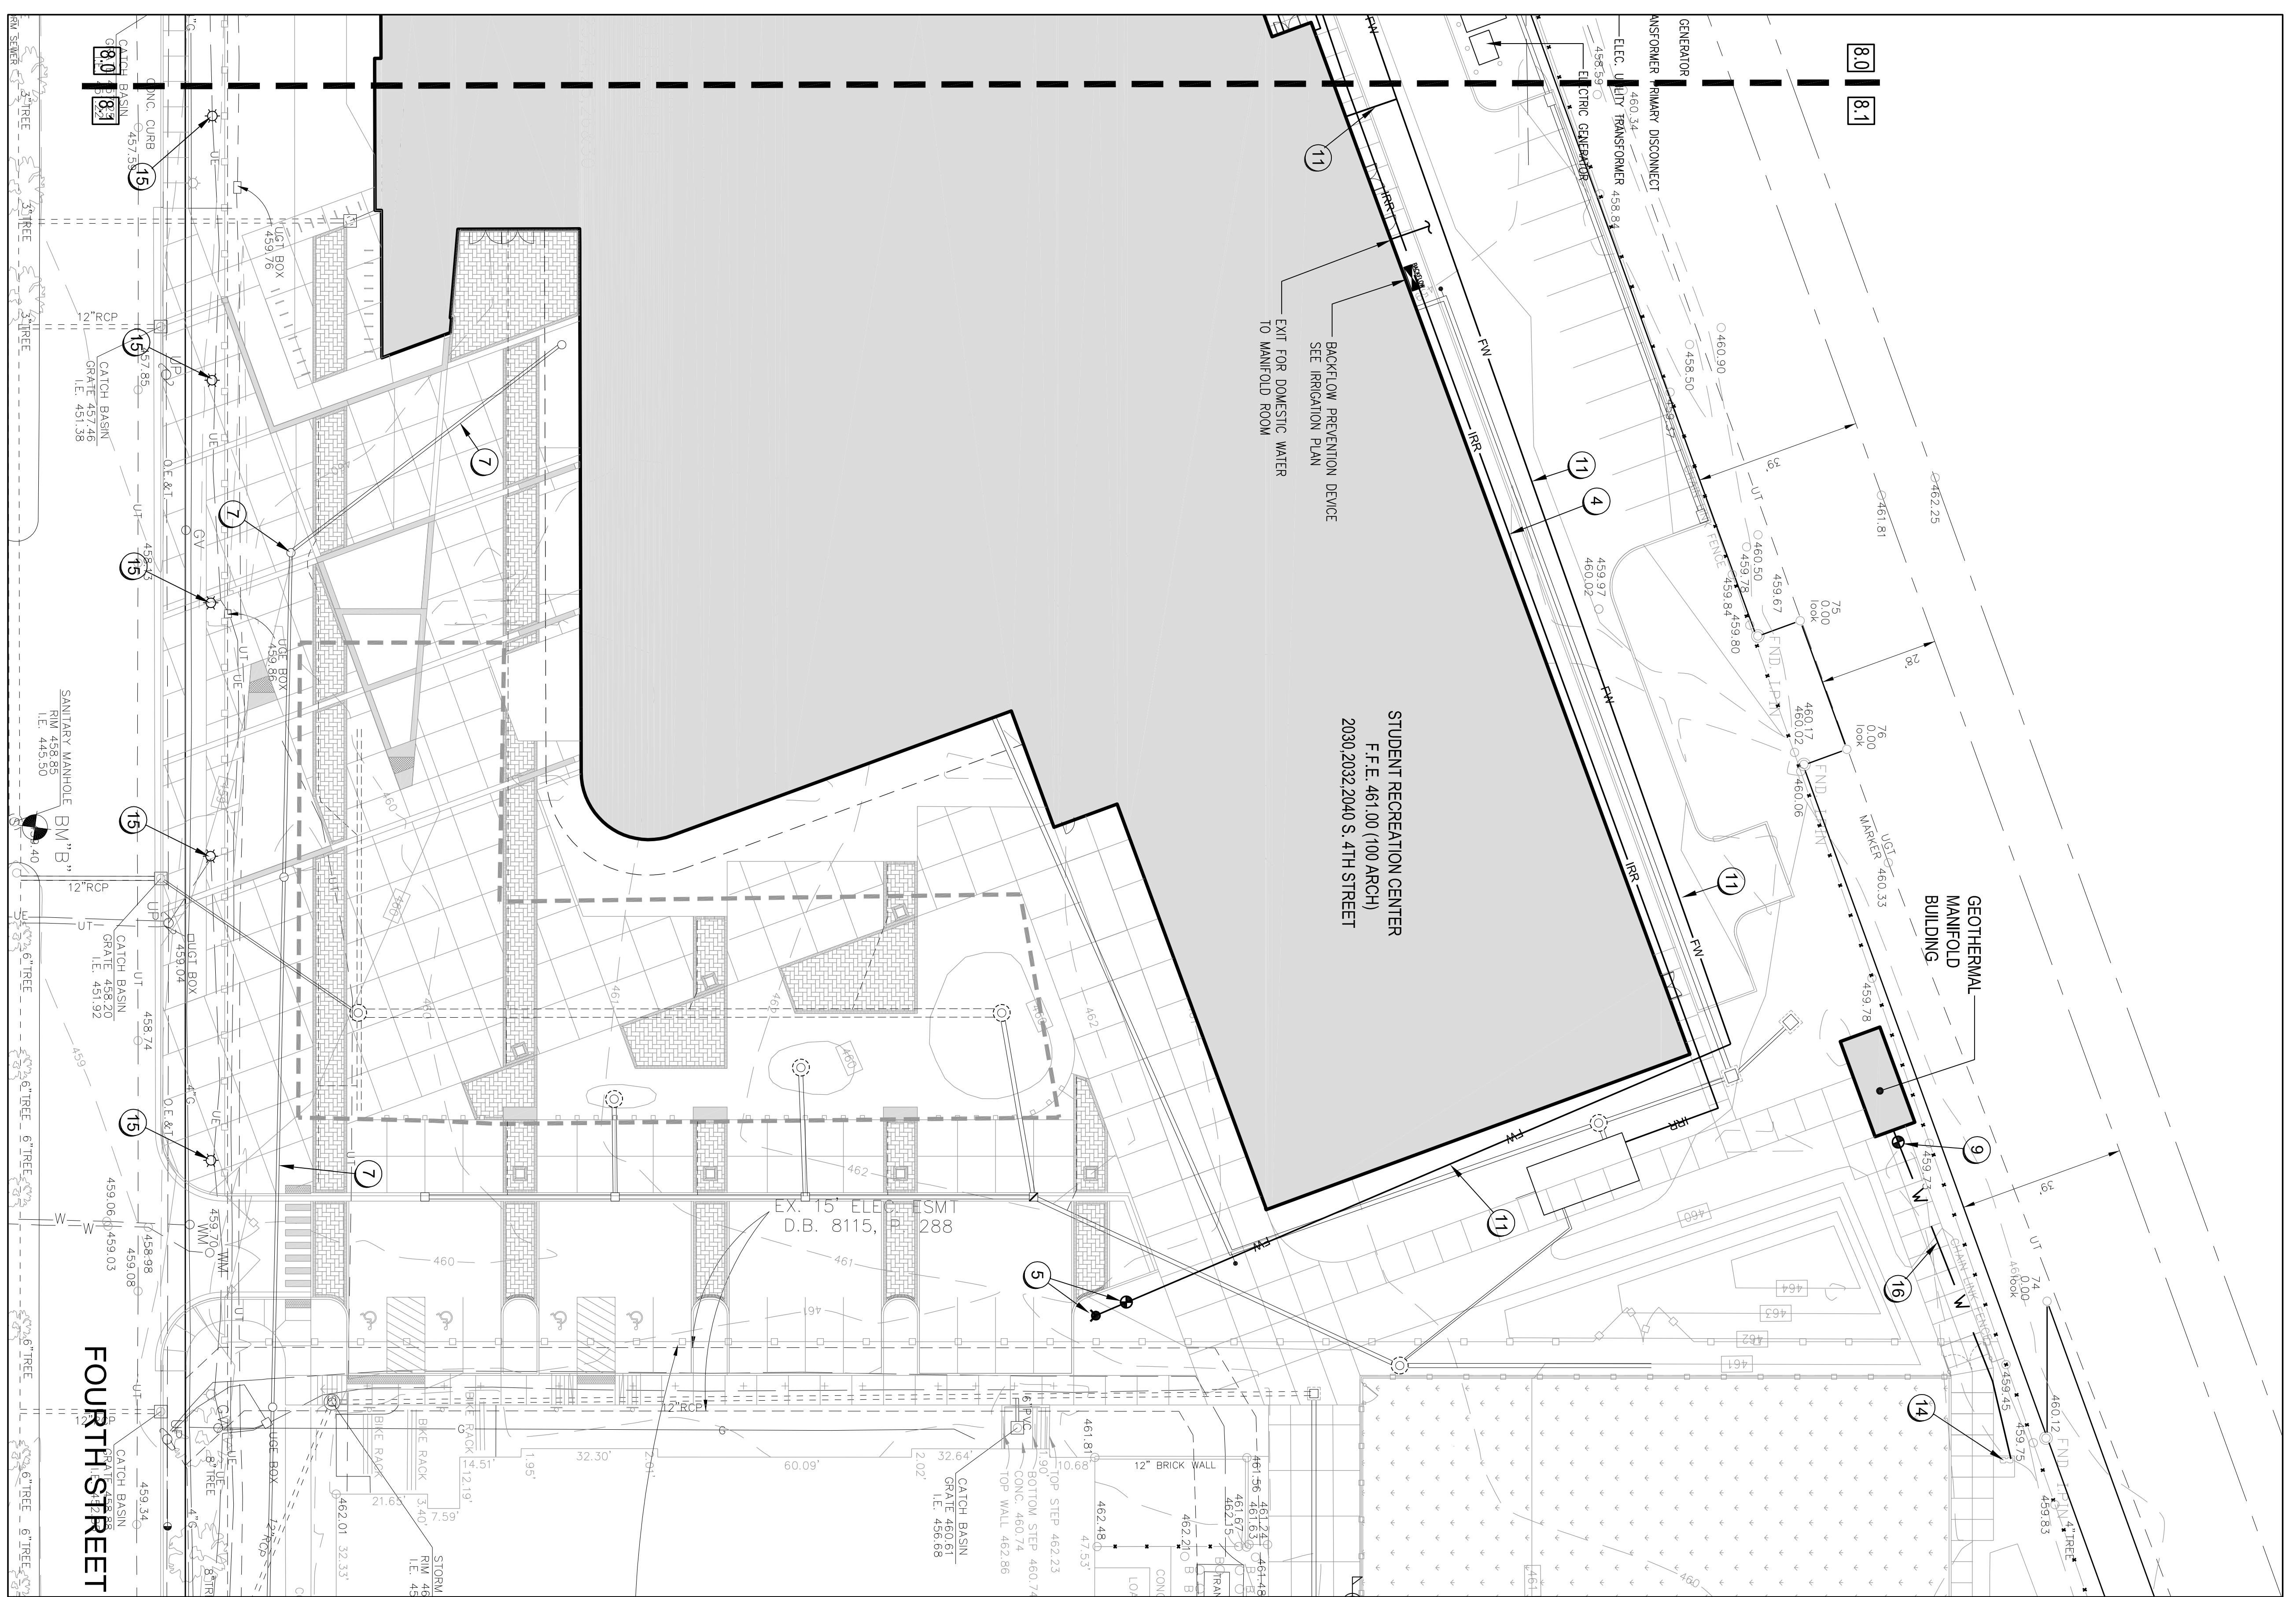

- GENERAL NOTES:**
- CONTRACTOR TO PAY ALL TAP AND UTILITY FEES AS APPLICABLE FOR NEW SERVICE LINES TO THIS FACILITY.
 - REFER TO ALL OTHER APPLICABLE PLANS FOR INSTALLATION OF UTILITIES TO AVOID POTENTIAL CONFLICTS INCLUDING:
 - A - ARCHITECTURAL PLANS
 - B - MECHANICAL AND ELECTRICAL PLANS
 - C - FEDERAL, STATE, LOCAL, MUNICIPALITY AND UTILITY COMPANY CODES, RULES, REGULATIONS, AND REQUIREMENTS APPLY UNLESS ADVISED THE DESIGN CONSULTANT OF ANY POTENTIAL CONFLICTS.
 - EXCEED BY THIS DESIGN, EXISTING EXTERIOR CURBLINE WHILE WORKING IN VICINITY OF WATER, GAS MAINS, AND ANY OVERHEAD UTILITY LINES.
 - ALL SANITARY SEWER, WATER LINES, CANY, AND TELEPHONE CONDUIT UNDER PAVEMENT SHALL BE IDENTIFIED WITH COMPLETED ROUGHED SHOWN CONSTRUCTION REQUIREMENTS, AND PERFORMANCE STANDARDS SHALL COMPLY WITH ALL APPLICABLE STANDARDS, CURRENT DESIGN MANUALS, AND RESPECTIVE UTILITY COMPANY REQUIREMENTS.
 - ALL FEES AND ANY OTHER COSTS FROM UTILITY COMPANIES, MUNICIPALITIES, INSPECTORS, PERMITS AGENCIES, ETC. ARE TO BE INCLUDED AS A PART OF THIS CONTRACT.
 - PERMANENT INTERFERENCE OF ANY SERVICE SHALL BE COORDINATED WITH THE APPROPRIATE MUNICIPALITY OR UTILITY COMPANY. NOTIFY THAT THEY DO NOT DELAY WORK.
 - LOCATIONS, DEPTHS, MATERIAL TYPES, ELEVATIONS, ETC. OF ALL APPURTENANCES, LINES, BUILDINGS, ETC. INDICATED ON THIS DRAWING SHALL BE VERIFIED BY THE CONTRACTOR PRIOR TO ANY CONSTRUCTION. TWO VIEWS IN EACH DIRECTION IN WRITING AND USING CERTAIN EXISTING ELEMENTS AND UTILITIES MAY NOT BE INDICATED AT ALL. THE CONTRACTOR SHALL BE RESPONSIBLE FOR VERIFYING THE WORK INDICATED HEREON SHALL VISIT THIS SITE AND DETERMINE AT ALL TIMES THE CONTRACTOR SHALL BE COMPLETELY RESPONSIBLE FOR VERIFYING UTILITY LINES. THE PROPOSED CONSTRUCTION SHALL CALL BIDDING WORKING DAYS PRIOR TO CONSTRUCTION OF ANY WORK WITHIN PUBLIC RIGHT-OF-WAY SHALL COMPLY WITH ALL APPLICABLE PUBLIC WORKS STANDARDS.
- PER A DOMESTIC WATER SERVICE NOTES:**
- UNLESS NOTED OTHERWISE, ALL WATER LINES SHALL BE 3\"/>
- UNDERGROUND WATER COMPANY NOTES:**
- THE LOUISVILLE WATER COMPANY WILL LOCATE TYPES OF DOMESTIC, FIRE AND IRRIGATION WATER LINES ON MAIN WATER LINE LOCATED IN 4TH STREET AND WILL EXTEND THE LINES TO THE WATER LOCATIONS AS INDICATED.
 - THE CONTRACTOR SHALL COORDINATE EACH WATER LINE WITH THE LOUISVILLE WATER COMPANY. USE BETH ALLEN, 502.689.8501 EXT 2169.
 - THE LOUISVILLE WATER COMPANY WILL BE RESPONSIBLE FOR ANY AND ALL COSTS ASSOCIATED WITH THE WORK OF THIS CONTRACT.
 - THE CONTRACTOR SHALL BE RESPONSIBLE FOR ALL OTHER WATER LINE, VALVE AND IRRIGATION INSTALLATIONS AND EXTENSIONS FROM THE MAIN WATER LINE AS INDICATED ON THE PLAN.
- USE GAS NOTES:**
- THE CONTRACTOR SHALL BE RESPONSIBLE FOR INSTALLING THE GAS LINE TO THE TAP LOCATION AS INDICATED ON THE PLANS. LOUISVILLE GAS STREET SERVICE COMPANY WILL BE RESPONSIBLE FOR WORKING ALL GAS LINE FROM THE MAIN GAS LINE LOCATED ON THE WEST SIDE OF 4TH STREET.
 - THE CONTRACTOR SHALL COORDINATE ALL GAS LINE TAPS AND WATER INSTALLATIONS WITH USE, USE JOHN LEMKE, 502.262.8475.
 - INSTALLATIONS SHALL BE RESPONSIBLE FOR ANY AND ALL COSTS ASSOCIATED WITH THE WORK OF THIS CONTRACT.
 - THE CONTRACTOR SHALL BE RESPONSIBLE FOR THE GAS LINE EXTENSIONS AS INDICATED ON THE PLAN INCLUDING THE BUILDING SERVICE LINE AND CONNECTIONS TO THE BUILDING.
 - BR-BRASS ON EACH WATER TAP.
 - THE GAS SERVICE LINE SHALL BE 2\"/>
- CODED LAYOUT NOTES**
- | KEY | DESCRIPTION |
|-----|--|
| 1 | CONNECTION BY LOUISVILLE WATER COMPANY |
| 2 | 2\"/> |
| 3 | 3\"/> |
| 4 | 6\"/> |
| 5 | INSTALL NEW FIRE HOBBART AND VALVES (AS PERMITTED BY LOUISVILLE FIRE DEPARTMENT) |
| 6 | INSTALL IRRIGATION MAINFOLD VALVE |
| 7 | 6\"/> |
| 8 | METER AS REQUIRED |
| 9 | SHUTOFF/CONNECTION VALVE AS REQUIRED |
| 10 | MANHOLE GAS LINE WATER LOCATION TO BE DETERMINED. |
| 11 | MANHOLE GAS LINE WATER LOCATION TO BE DETERMINED. 6\"/> |
| 12 | 4\"/> |
| 13 | 2\"/> |
| 14 | BRASS ON EACH WATER TAP |
| 15 | RENEWAL USE LIGHTS SEE SHEET UET201 |
| 16 | 1/2\"/> |
- APPROVAL #4, ITEM 16
DATED 3-15-2012

PURPOSE OF THESE DRAWINGS IS TO REFLECT ALL CHANGES AND CLARIFICATIONS MADE THRU PREVIOUSLY ISSUED ADDENDA. CONTRACTOR IS RESPONSIBLE FOR ADHERENCE TO IMPROVEMENTS REFLECTED IN THE CONTRACT BIDS AND SPECIFICATIONS.

FOR LOCATION OF UNDERGROUND UTILITIES CALL B.U.D. 1-502-286-9123 (2) WORKING DAYS IN ADVANCE OF DIGGING

SD-8.1