

# BROWNING DAY MULLINS DIERDORF ARCHITECTS

Browning Day Mullins Dierdorf Architects  
Architecture  
Landscape Architecture  
Planning

334 North Senate Avenue  
Indianapolis, Indiana 46204  
P: 317.635.5030  
F: 317.634.5409  
E-Mail: jindstaedt@bdmd.com

Circle Design Group, Inc.  
Mechanical Electrical Plumbing Engineers


5510 South East Street, Suite F  
Indianapolis, Indiana 46227  
P: 317.781.6200  
F: 317.781.6201  
E-Mail: kerry@circledesigngroup.com

Lawson Elser Engineering Consultants  
Structural Engineers

650 East Carmel Drive, Suite 150  
Carmel, Indiana 46032  
P: 317.674.9409  
F: 317.674.9431  
E-Mail: mlawson@lawsonelser.com

Skoos Engineering, Inc.  
Civil Engineers

400 Blankensbaker Parkway, Suite 300  
Louisville, KY 40243  
P: 502.254.2344  
F: 502.254.3008  
E-Mail: cmckinnon@skoos.com

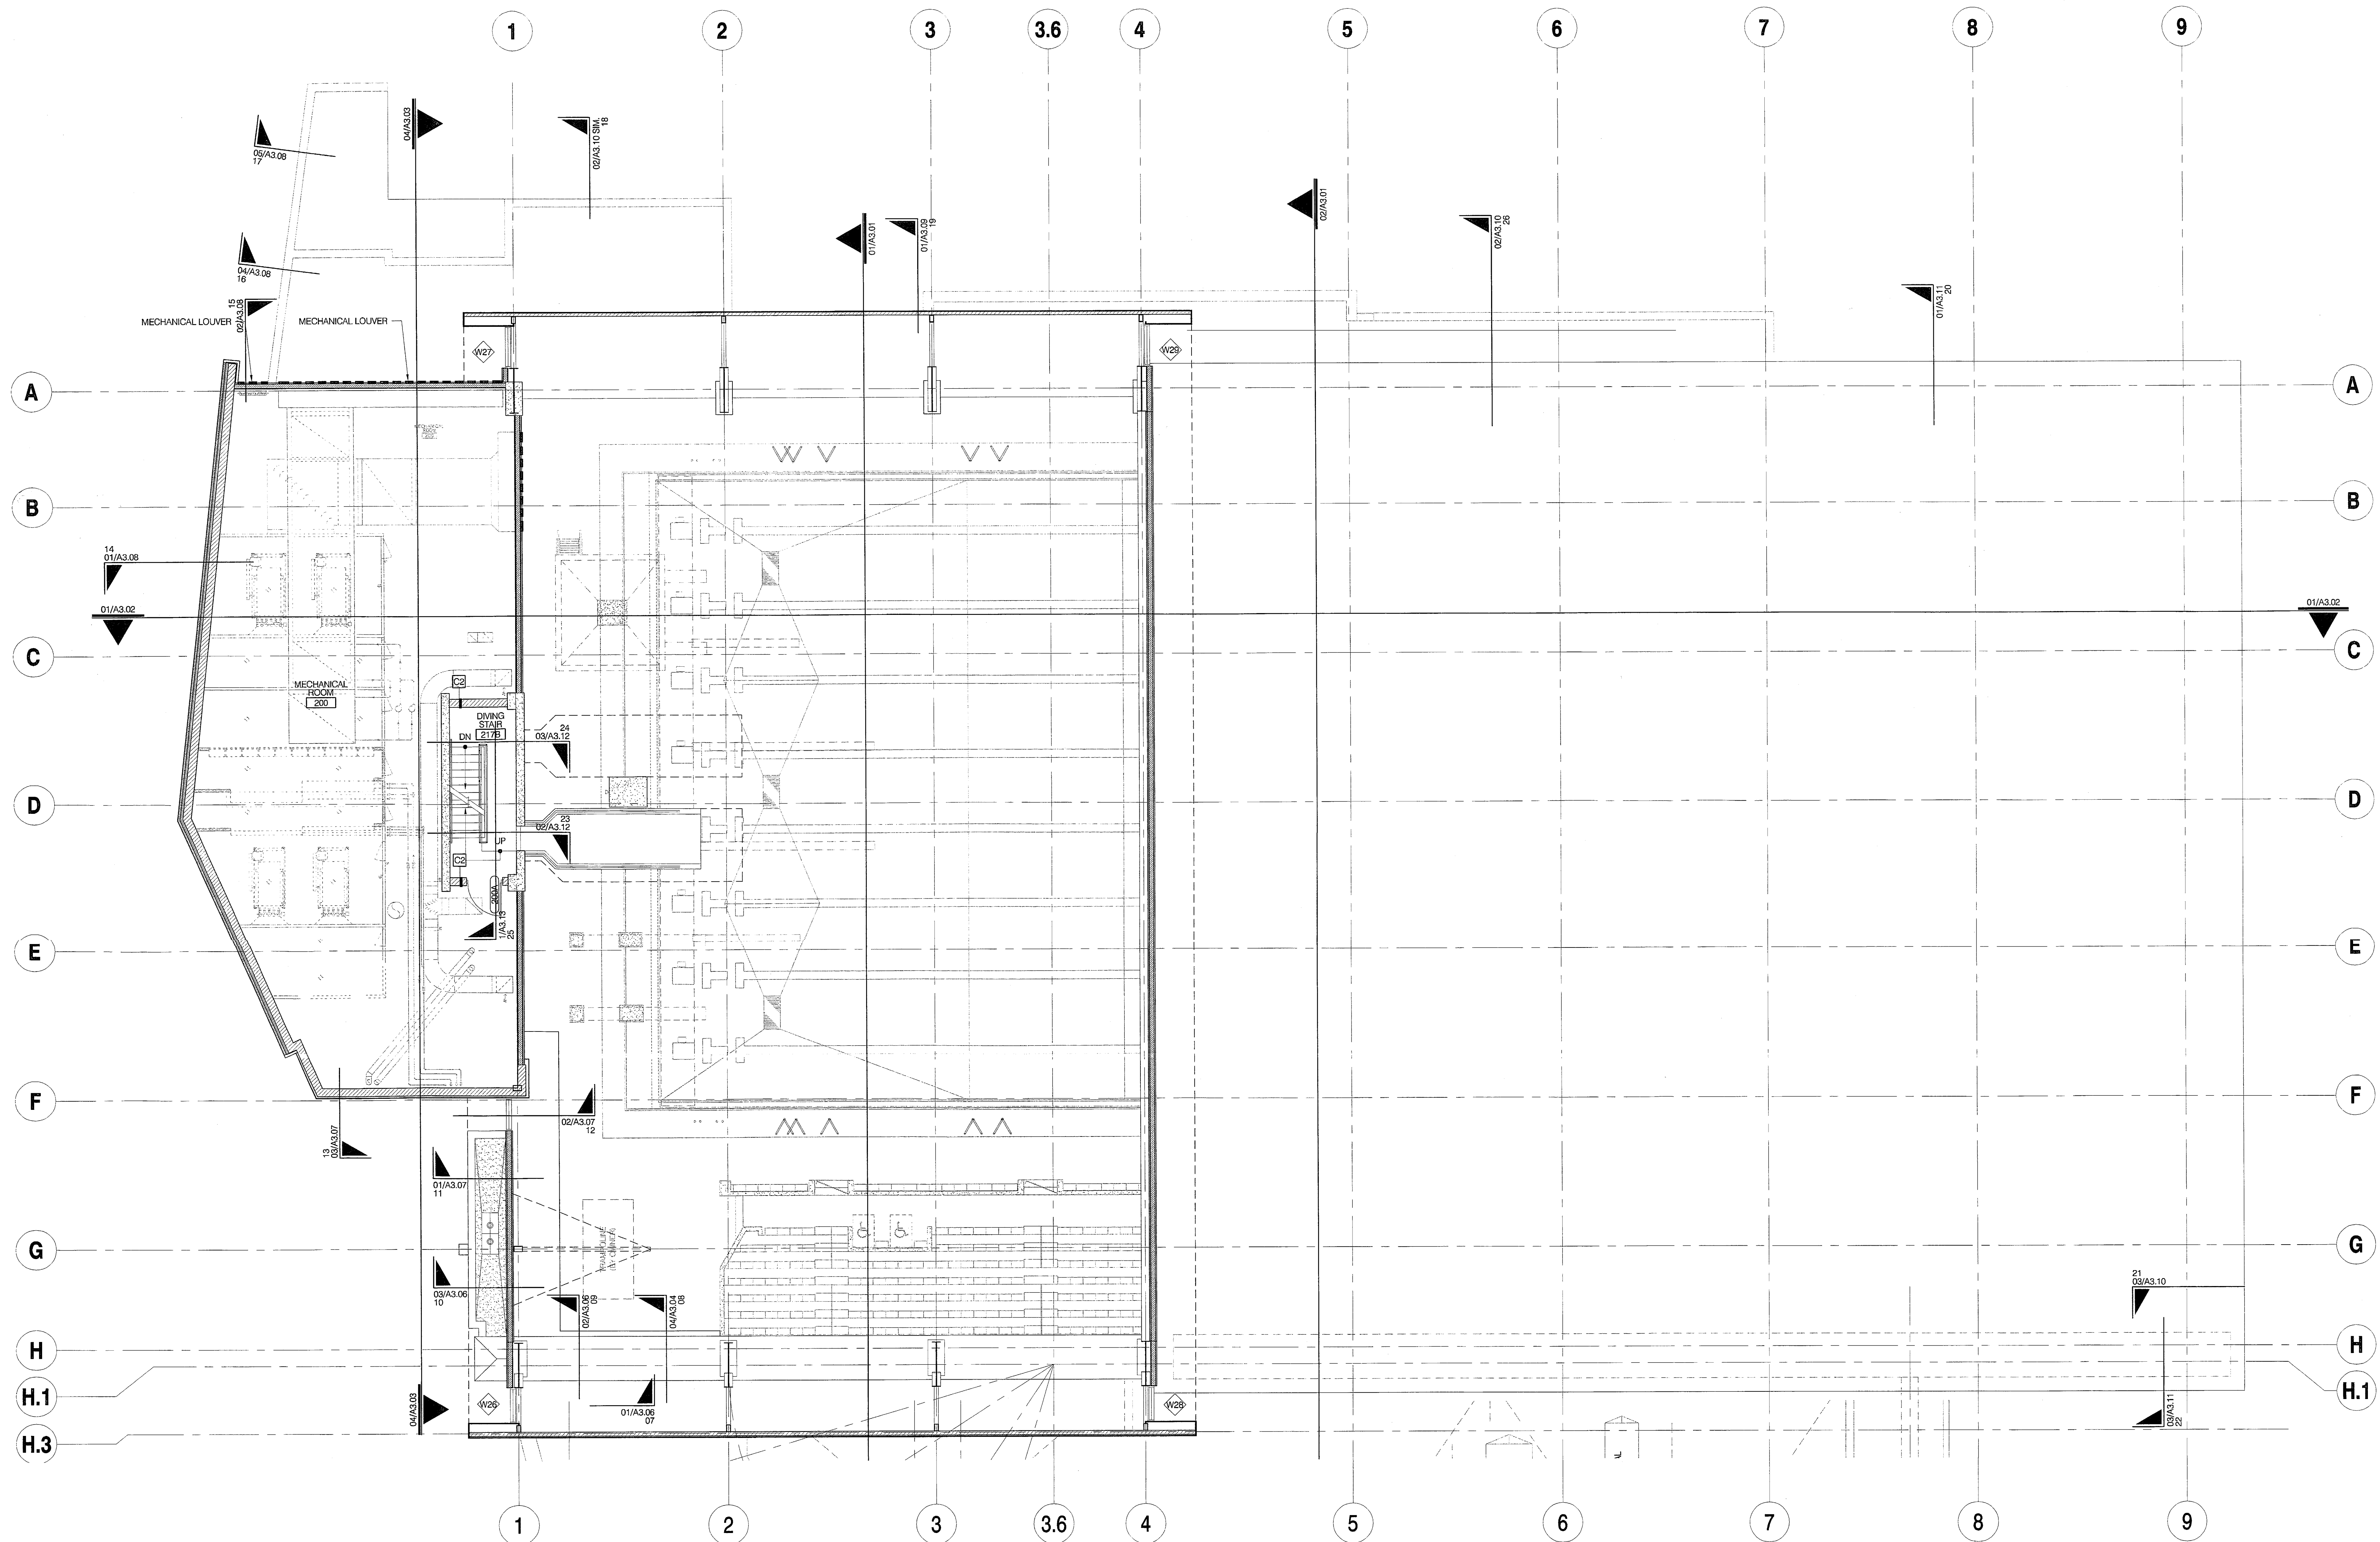

**01** UNIT A  
MECHANICAL FLOOR PLAN

A1.03 1/8" = 1'-0"



CERTIFICATION  
CONSTRUCTION DOCUMENTS

CARDINAL PARK  
NATORIUM

UNIVERSITY OF LOUISVILLE

Project: 05006  
Drawn: D. MCCLOSKEY  
Checked: J. LINDSTAEDT  
Scale:  
Issue Date: AUGUST 27, 2003  
Revision:

MECHANICAL FLOOR PLAN

**A1.03**