

**BROWNING  
DAY MULLINS  
DIERDORF  
ARCHITECTS**

Browning Day Mullins Dierdorf Architects  
Architecture  
Landscape Architecture  
Planning

334 North Senate Avenue  
Indianapolis, Indiana 46204  
P: 317.625.5000  
F: 317.634.5409  
E-Mail: jindstaedt@bmdm.com

Circle Design Group, Inc.  
Mechanical Electrical Plumbing Engineers


6510 South East Street, Suite F  
Indianapolis, Indiana 46227  
P: 317.781.8200  
F: 317.781.8201  
E-Mail: kerry@circledesigngroup.com

Lawson Elser Engineering Consultants  
Structural Engineers


650 East Carmel Drive, Suite 150  
Carmel, Indiana 46032  
P: 317.574.9409  
F: 317.574.9431  
E-Mail: rlawson@lawsonelser.com

Skees Engineering, Inc.  
Civil Engineers


400 Blankenbaker Parkway, Suite 300  
Louisville, KY 40243  
P: 502.254.3244  
F: 502.254.3008  
E-Mail: dmkinnon@skees.com

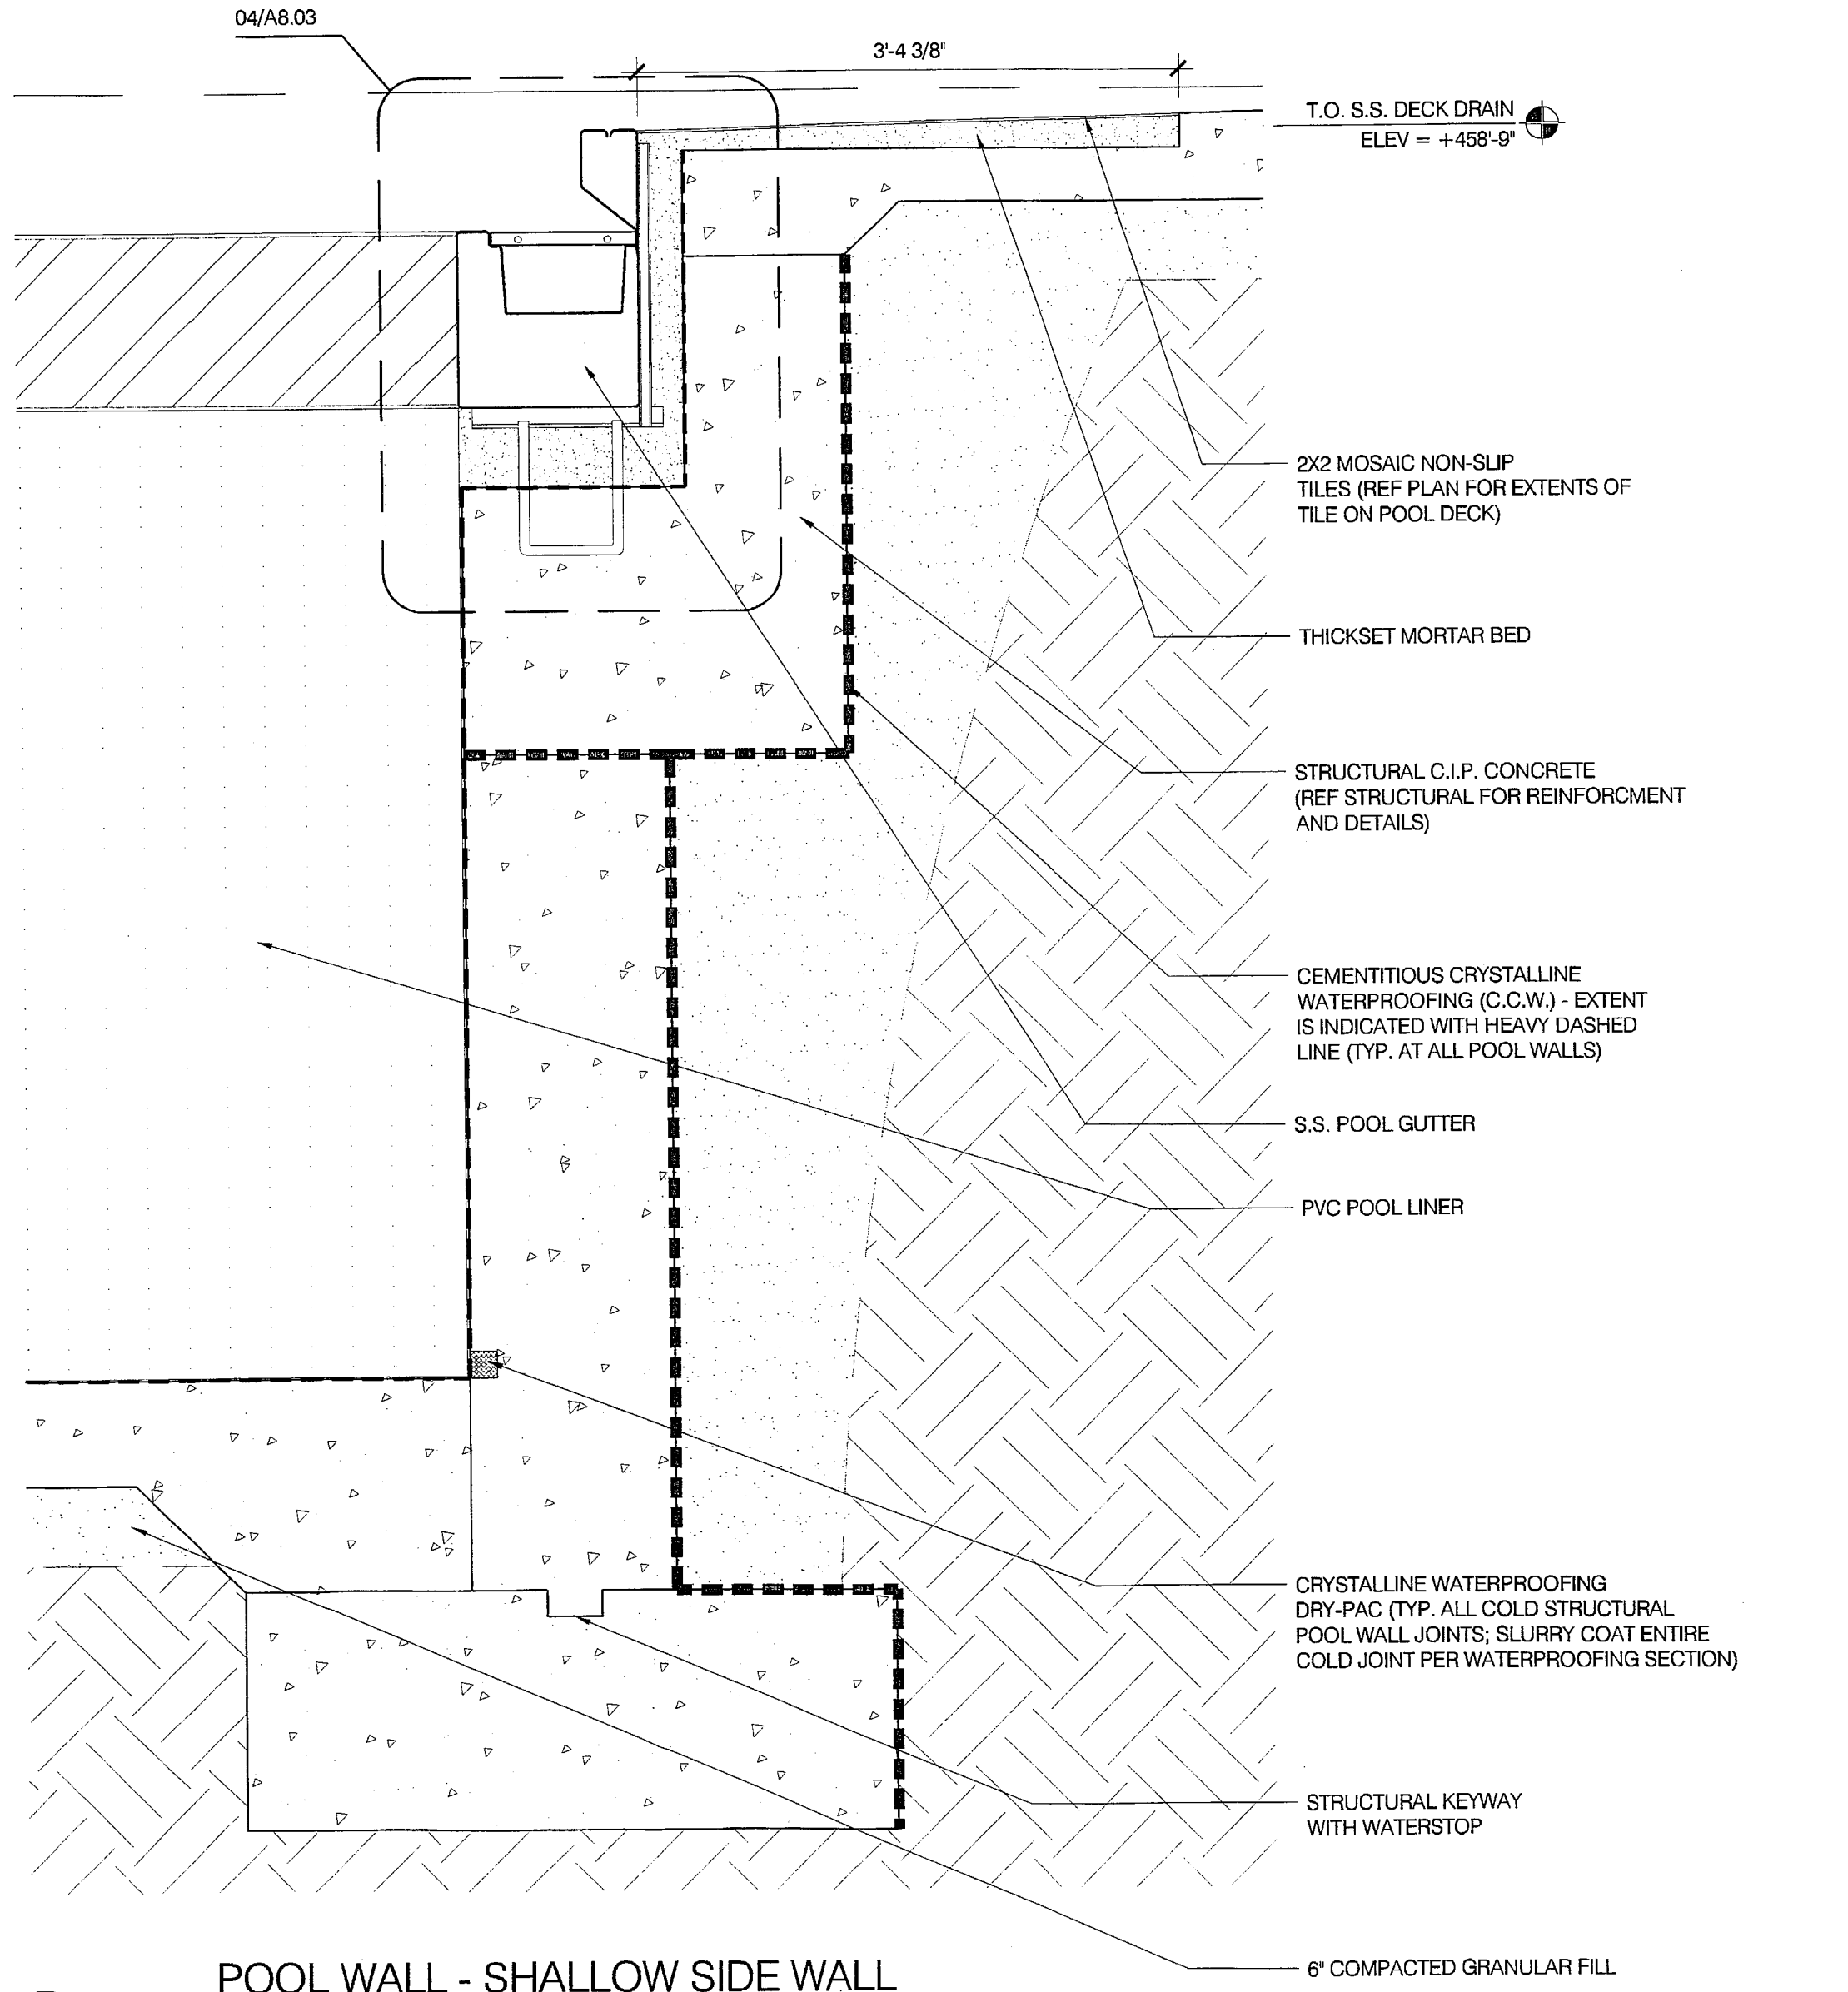


**04** POOL WALL - SHALLOW SIDE WALL SECTION  
A8.02 1" = 1'-0"

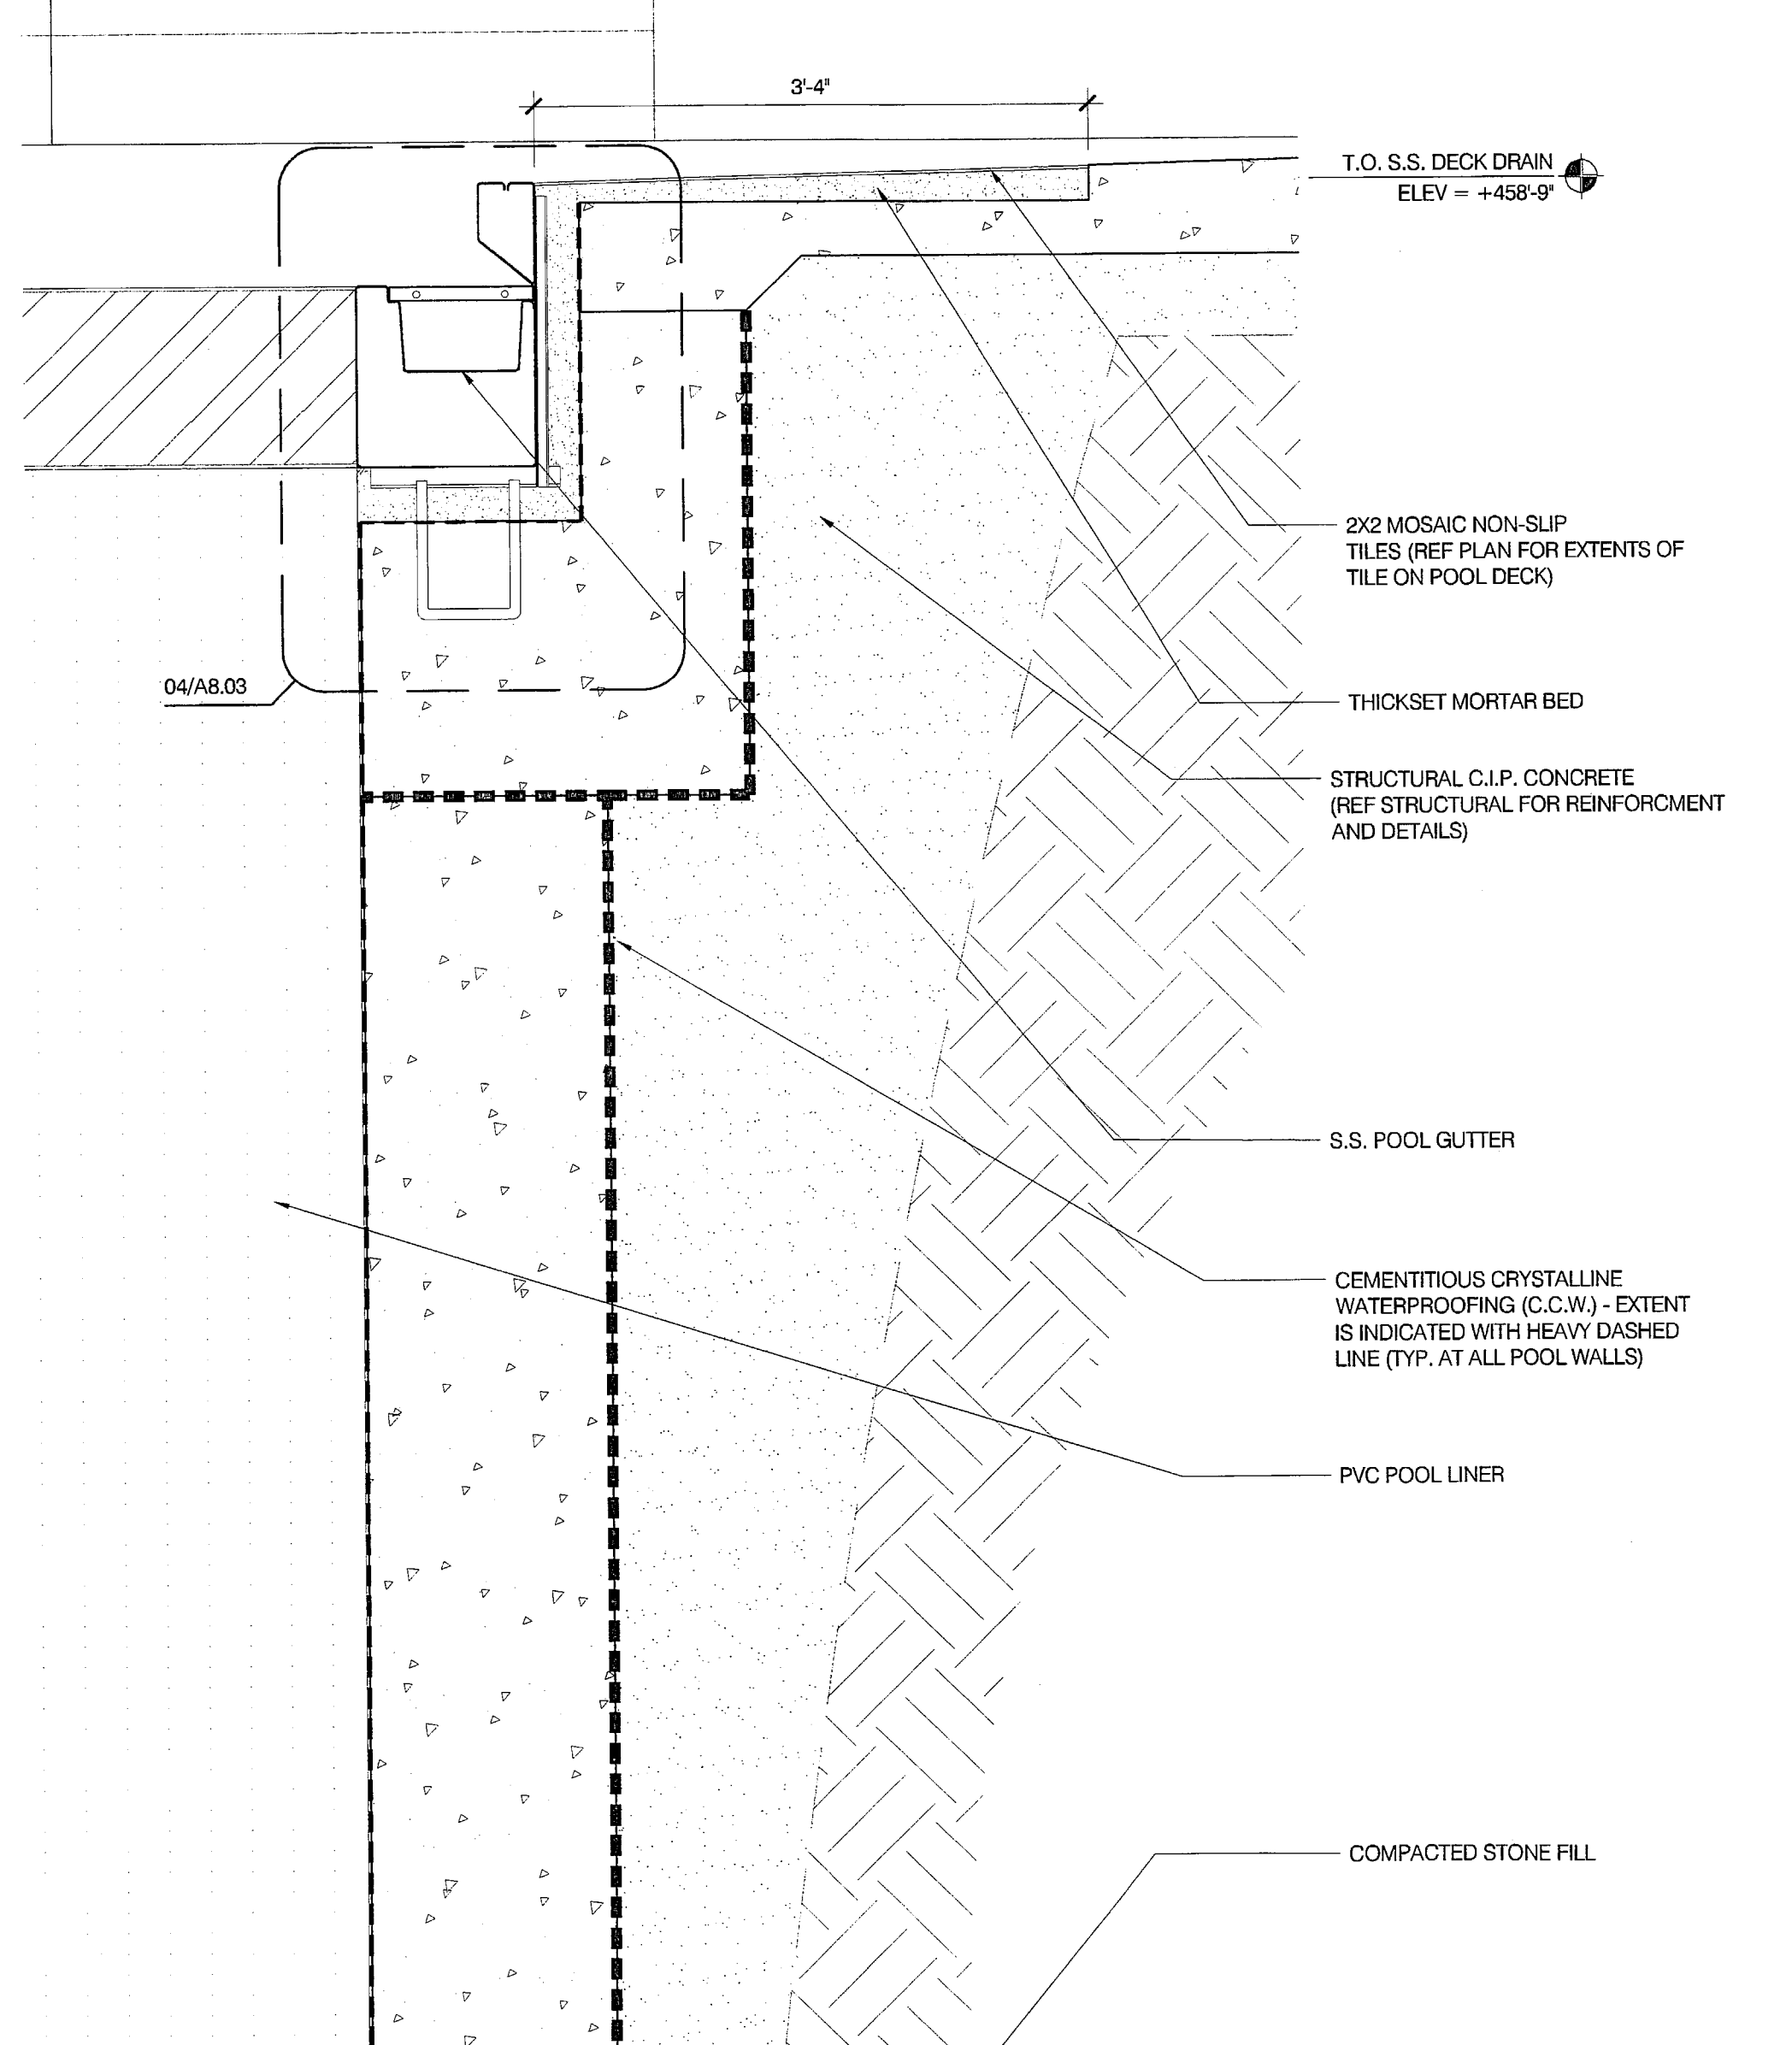


**02** POOL WALL - DIVING END WALL SECTION  
A8.02 1" = 1'-0"

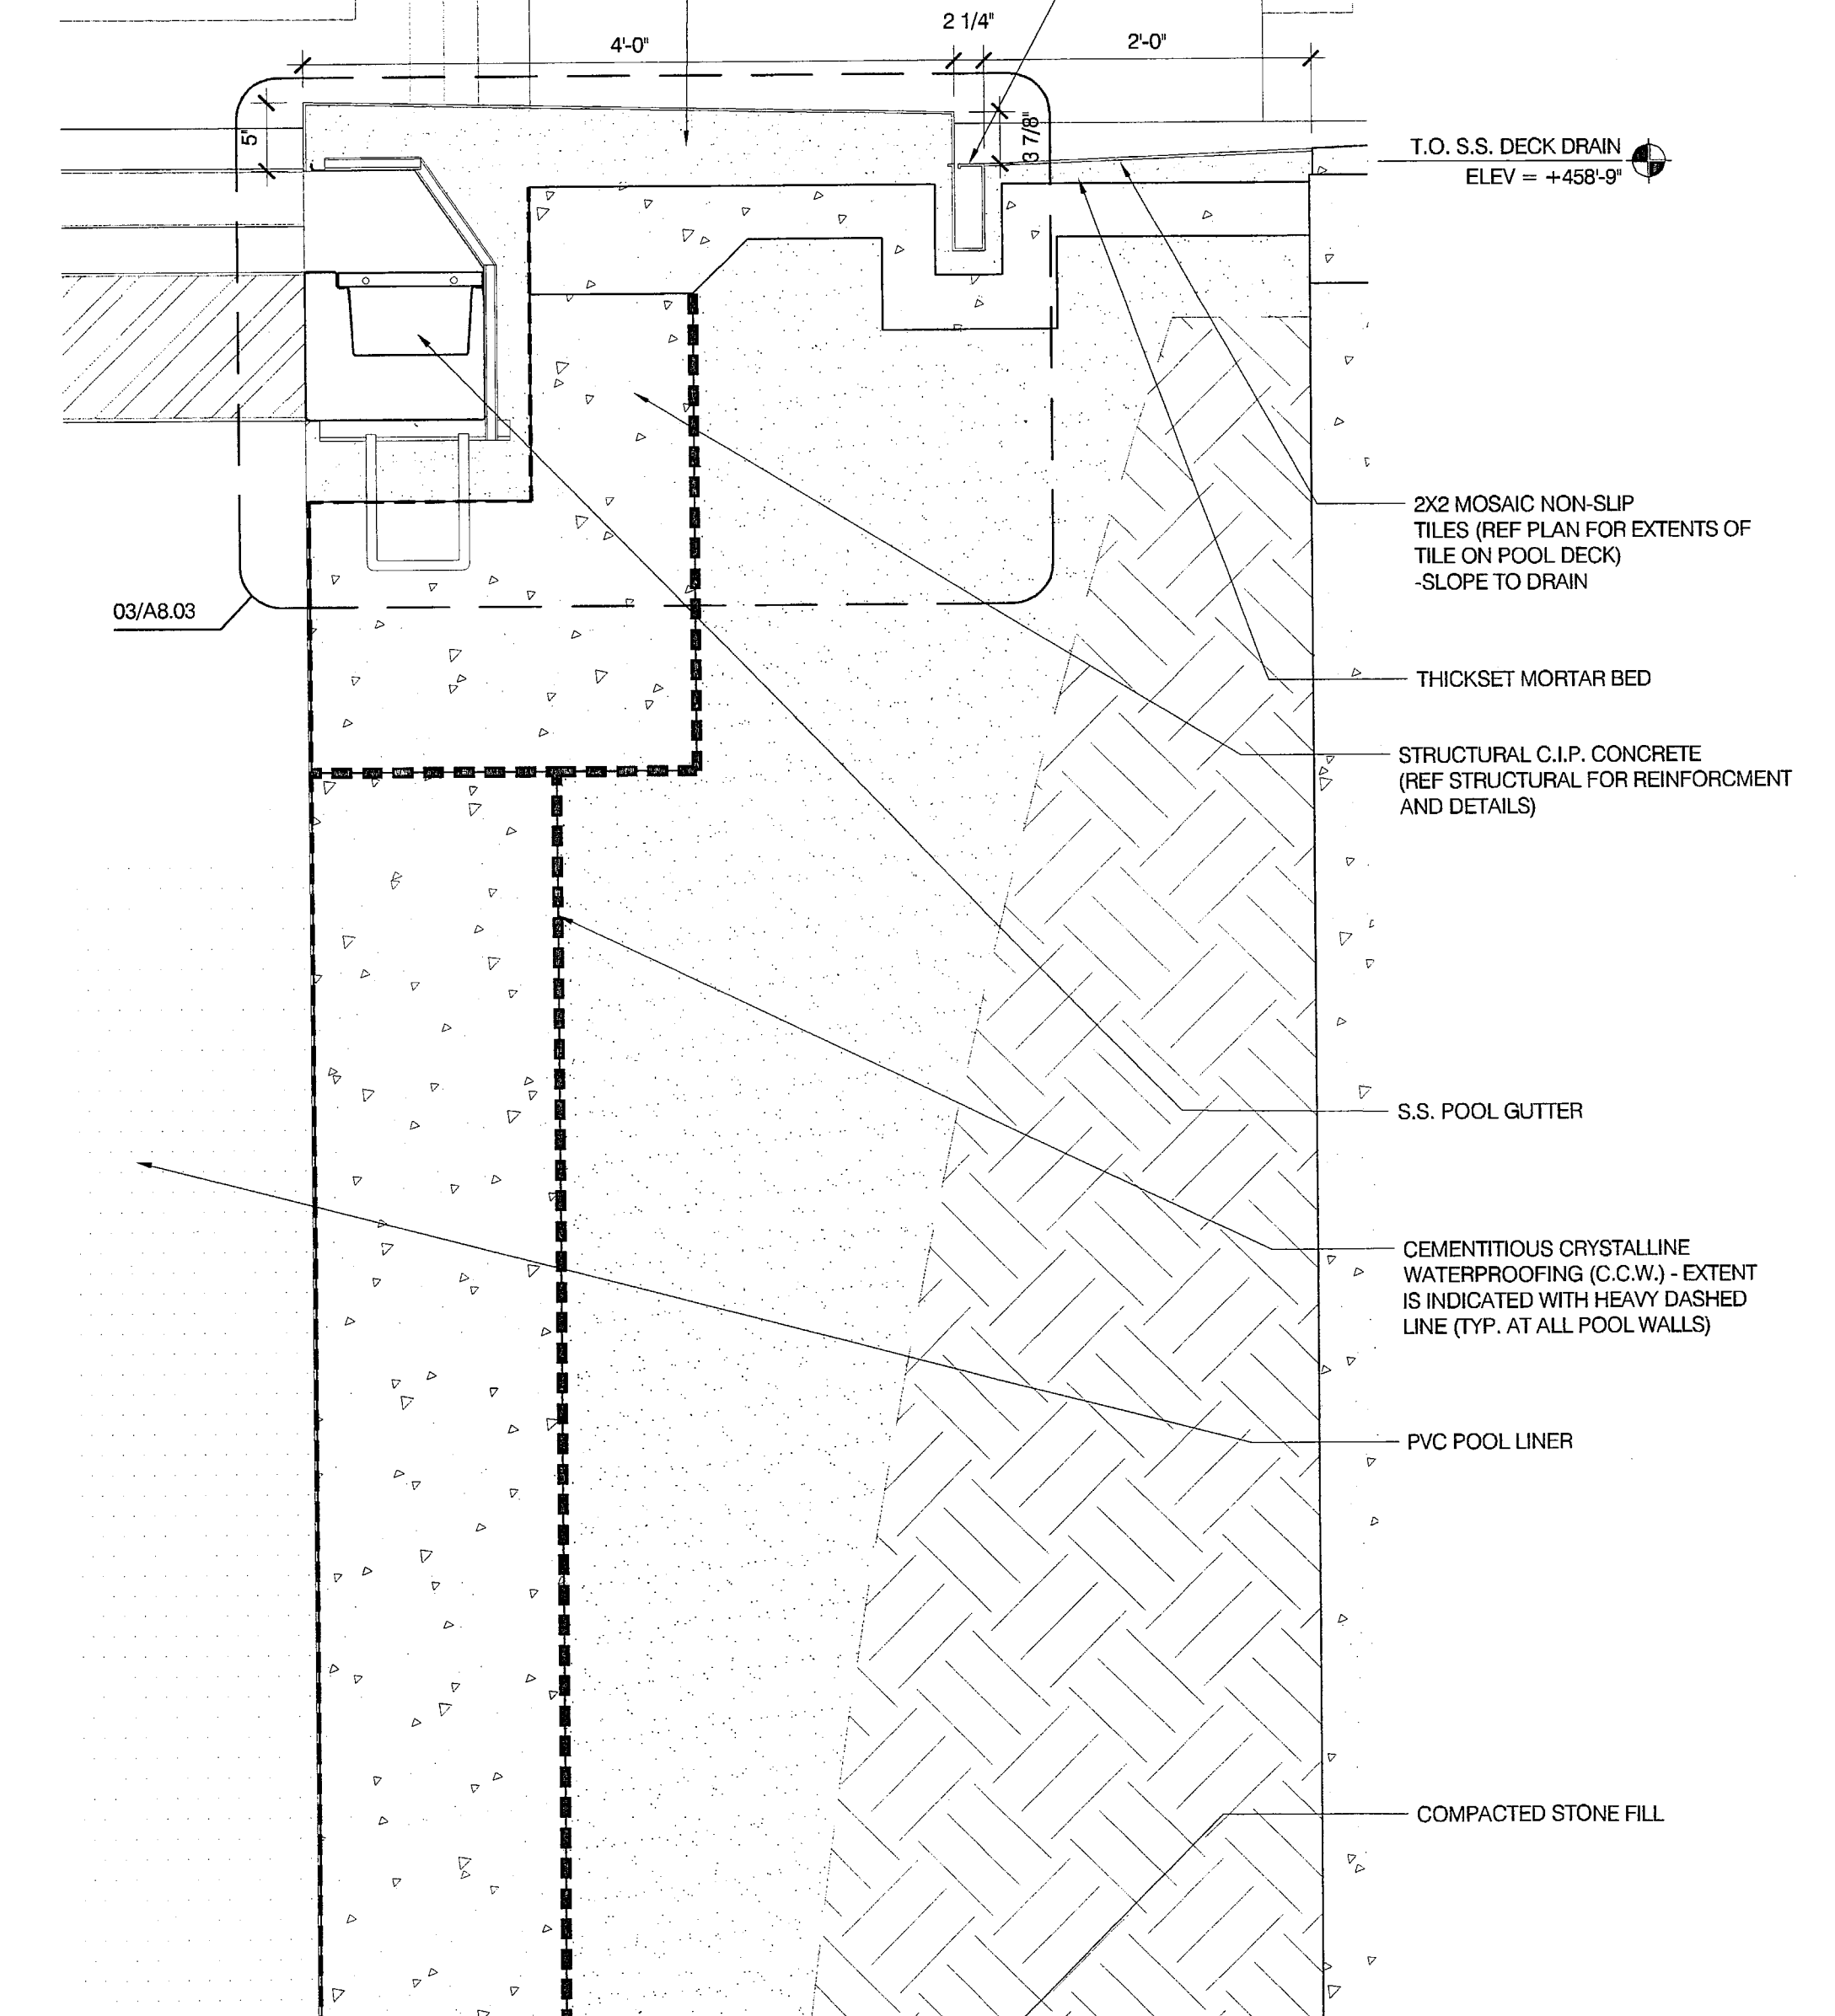


**01** POOL WALL - DIVING END WALL SECTION  
A8.02 1" = 1'-0"

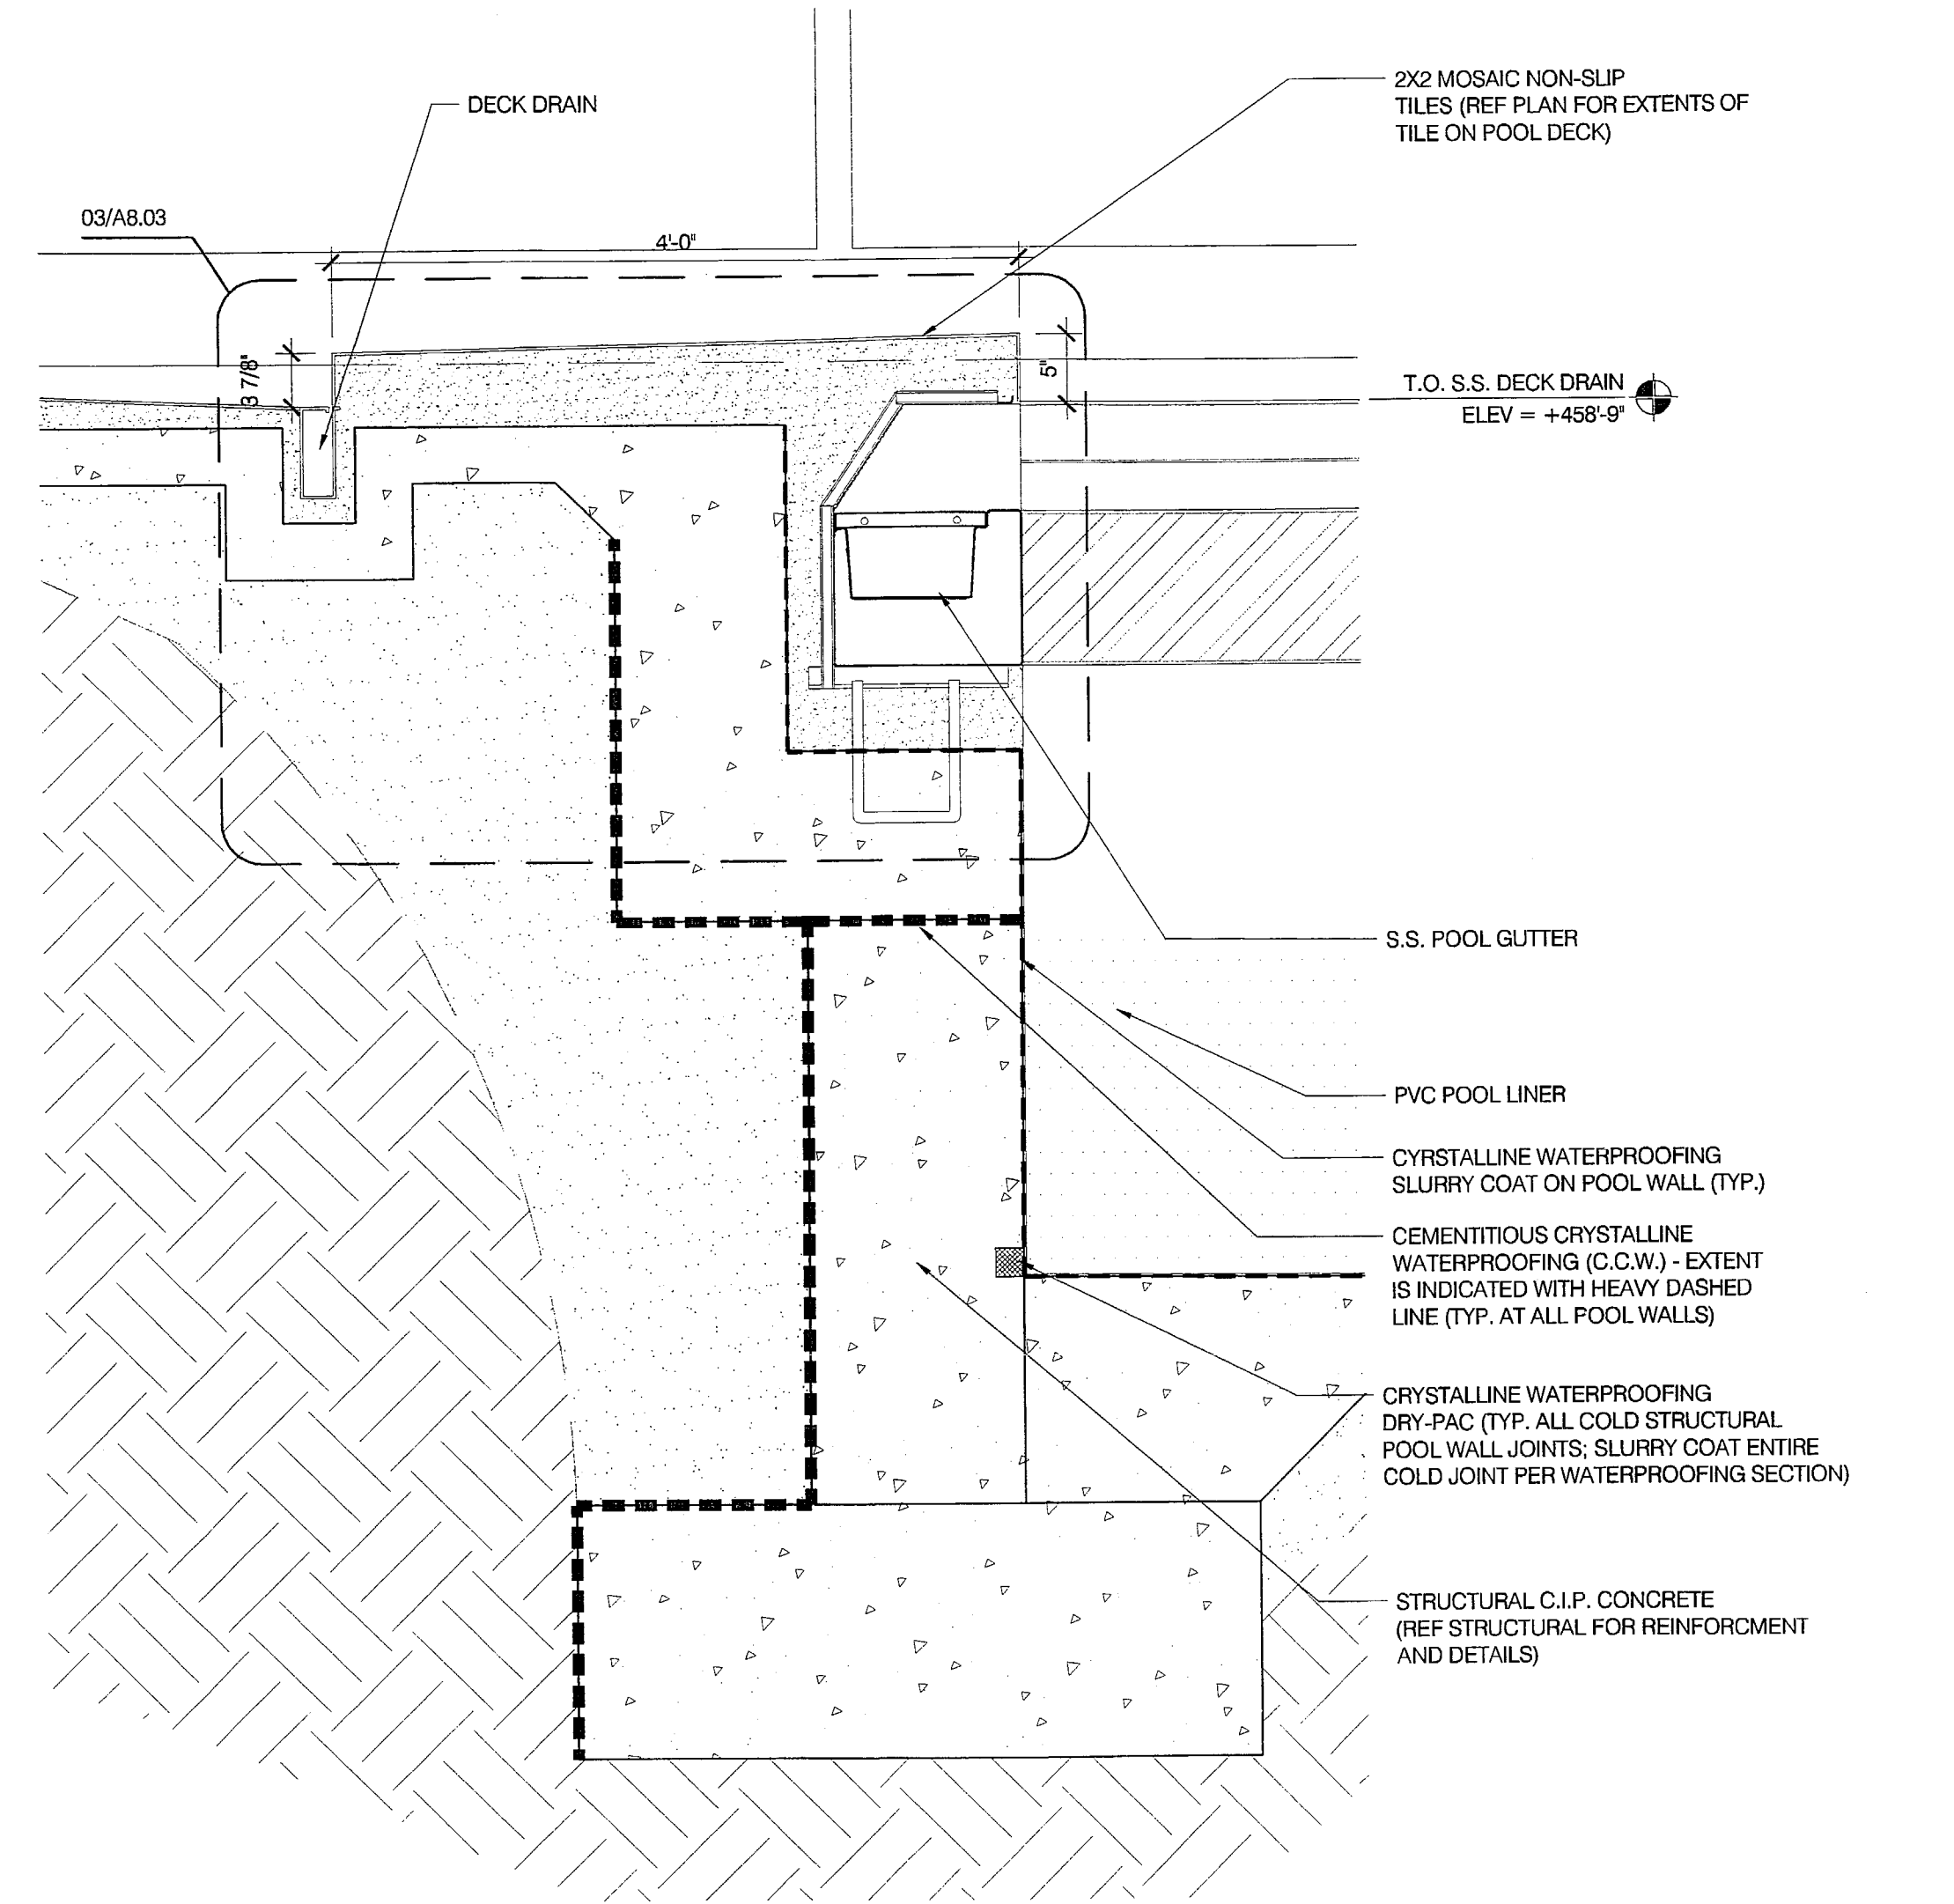


**03** POOL WALL - SHALLOW END WALL SECTION  
A8.02 1" = 1'-0"

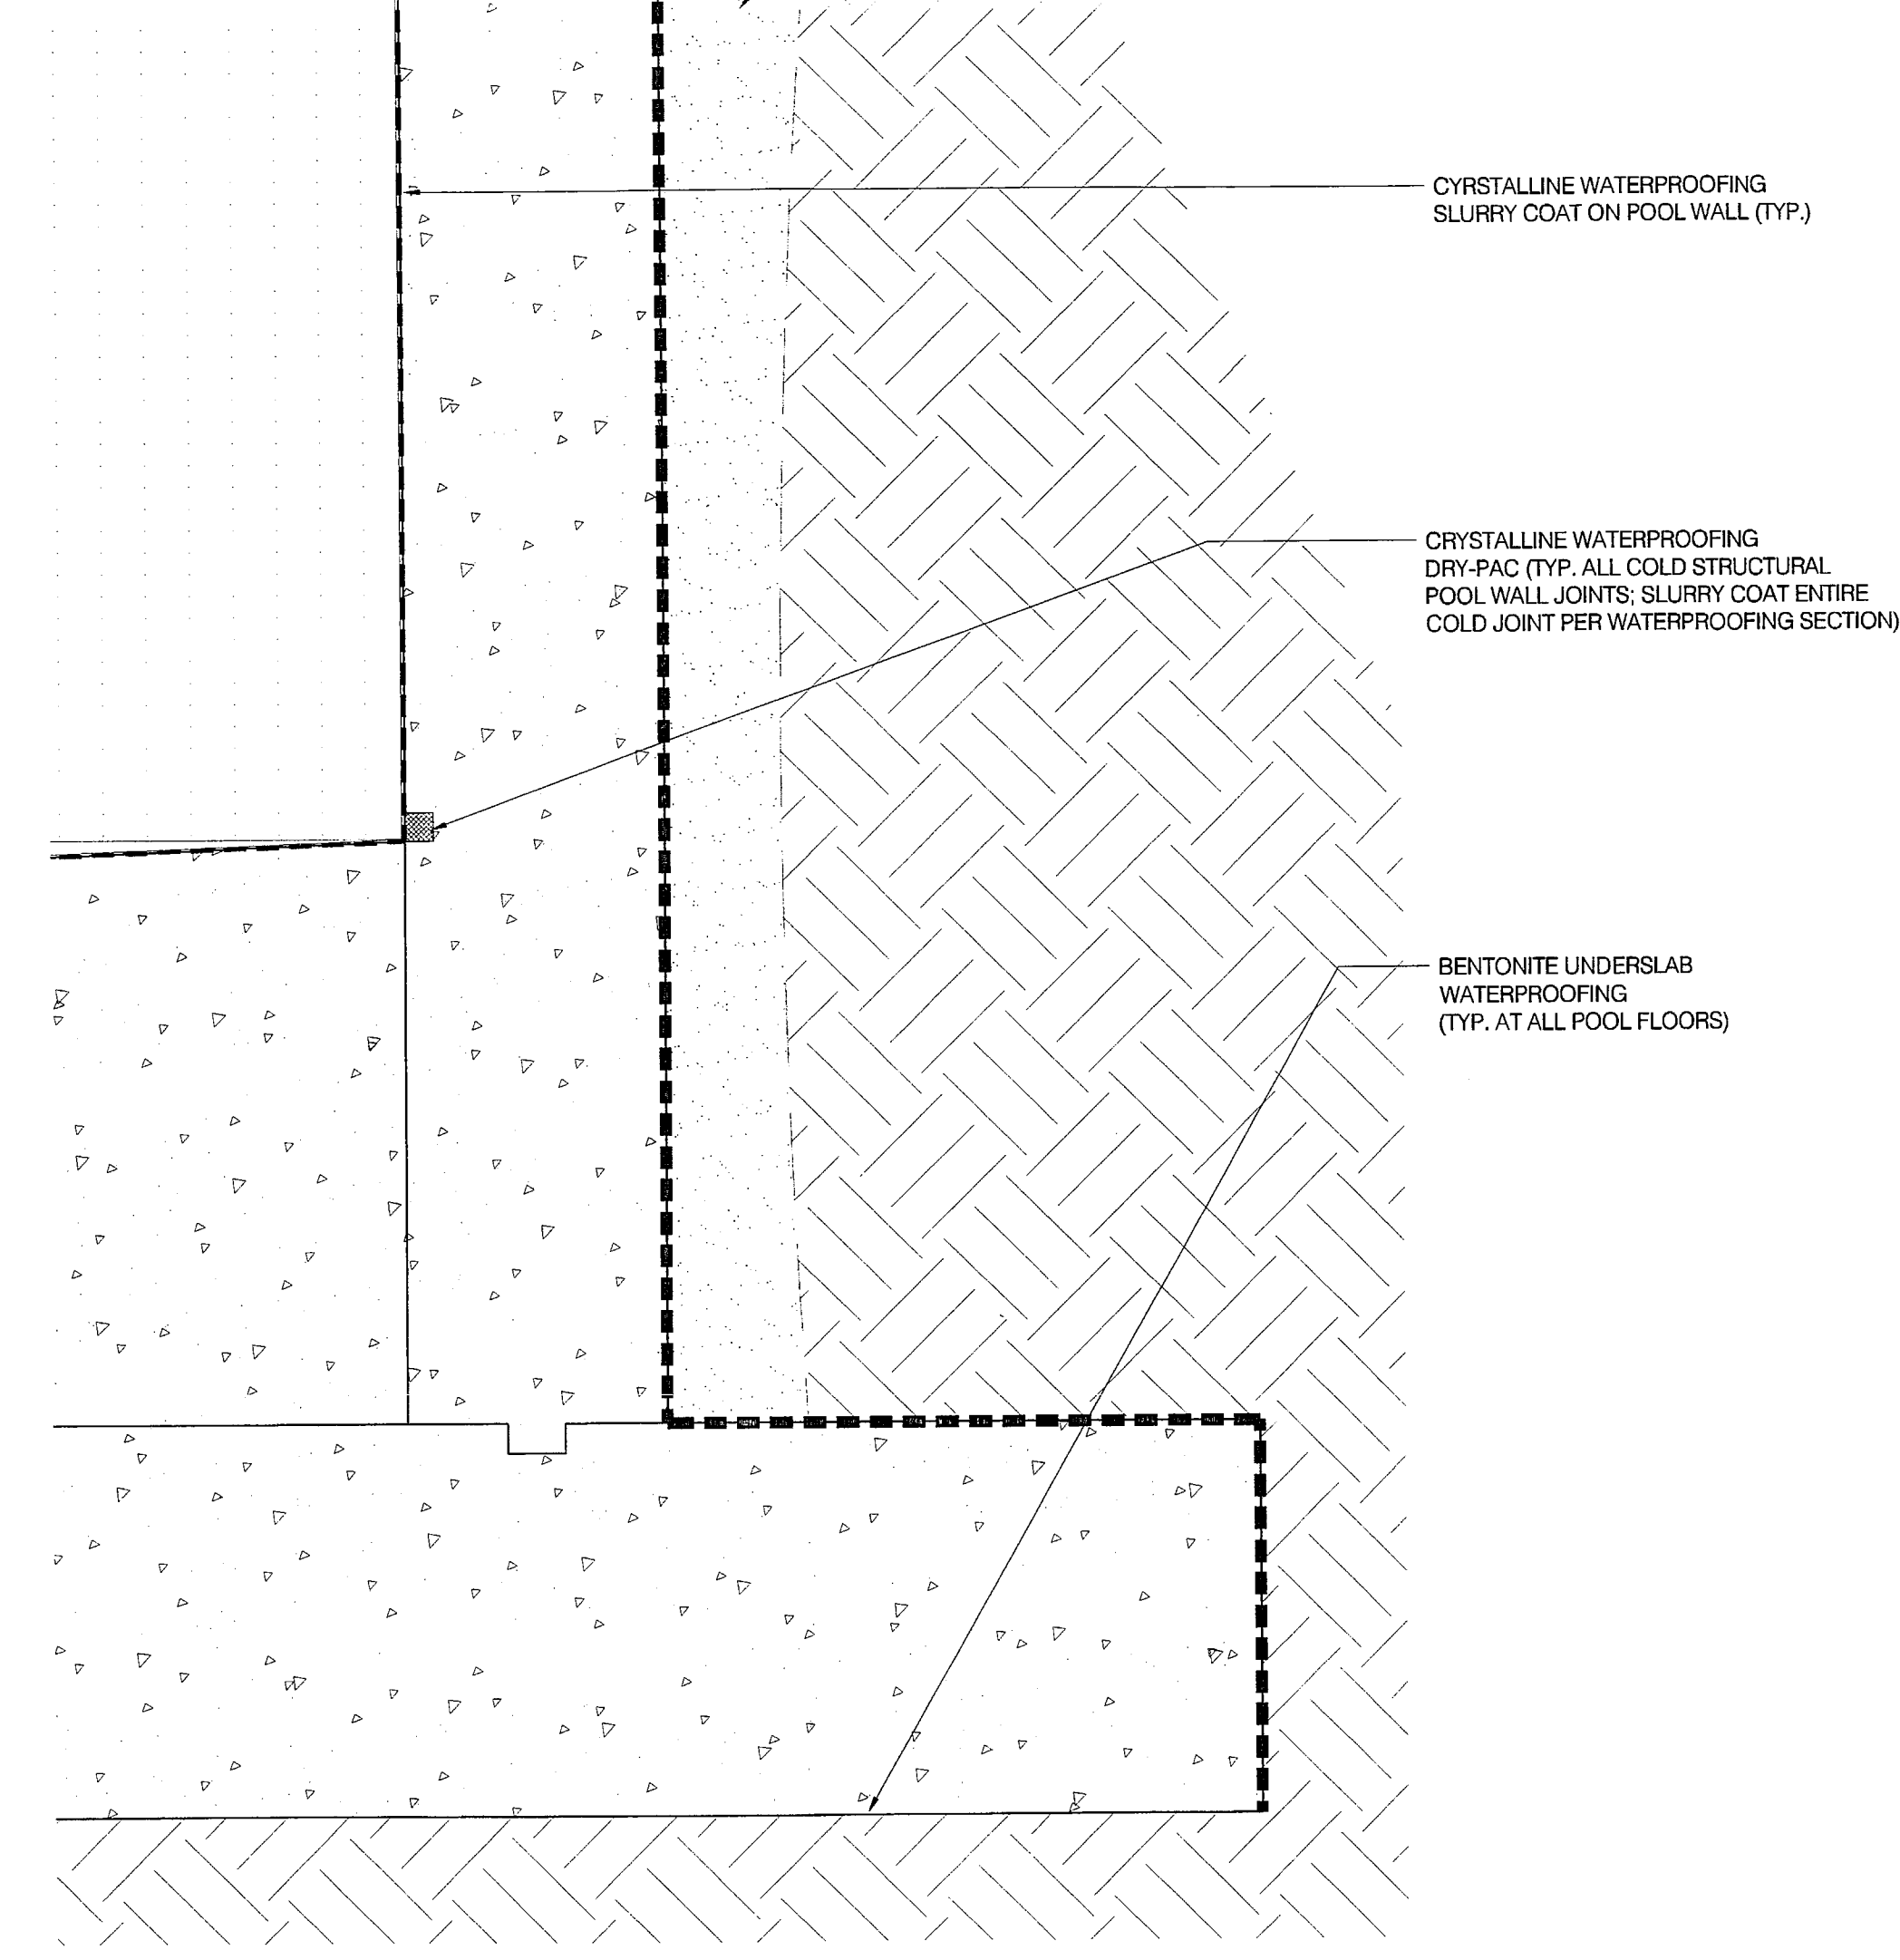

**02** POOL WALL - DIVING END WALL SECTION  
A8.02 1" = 1'-0"

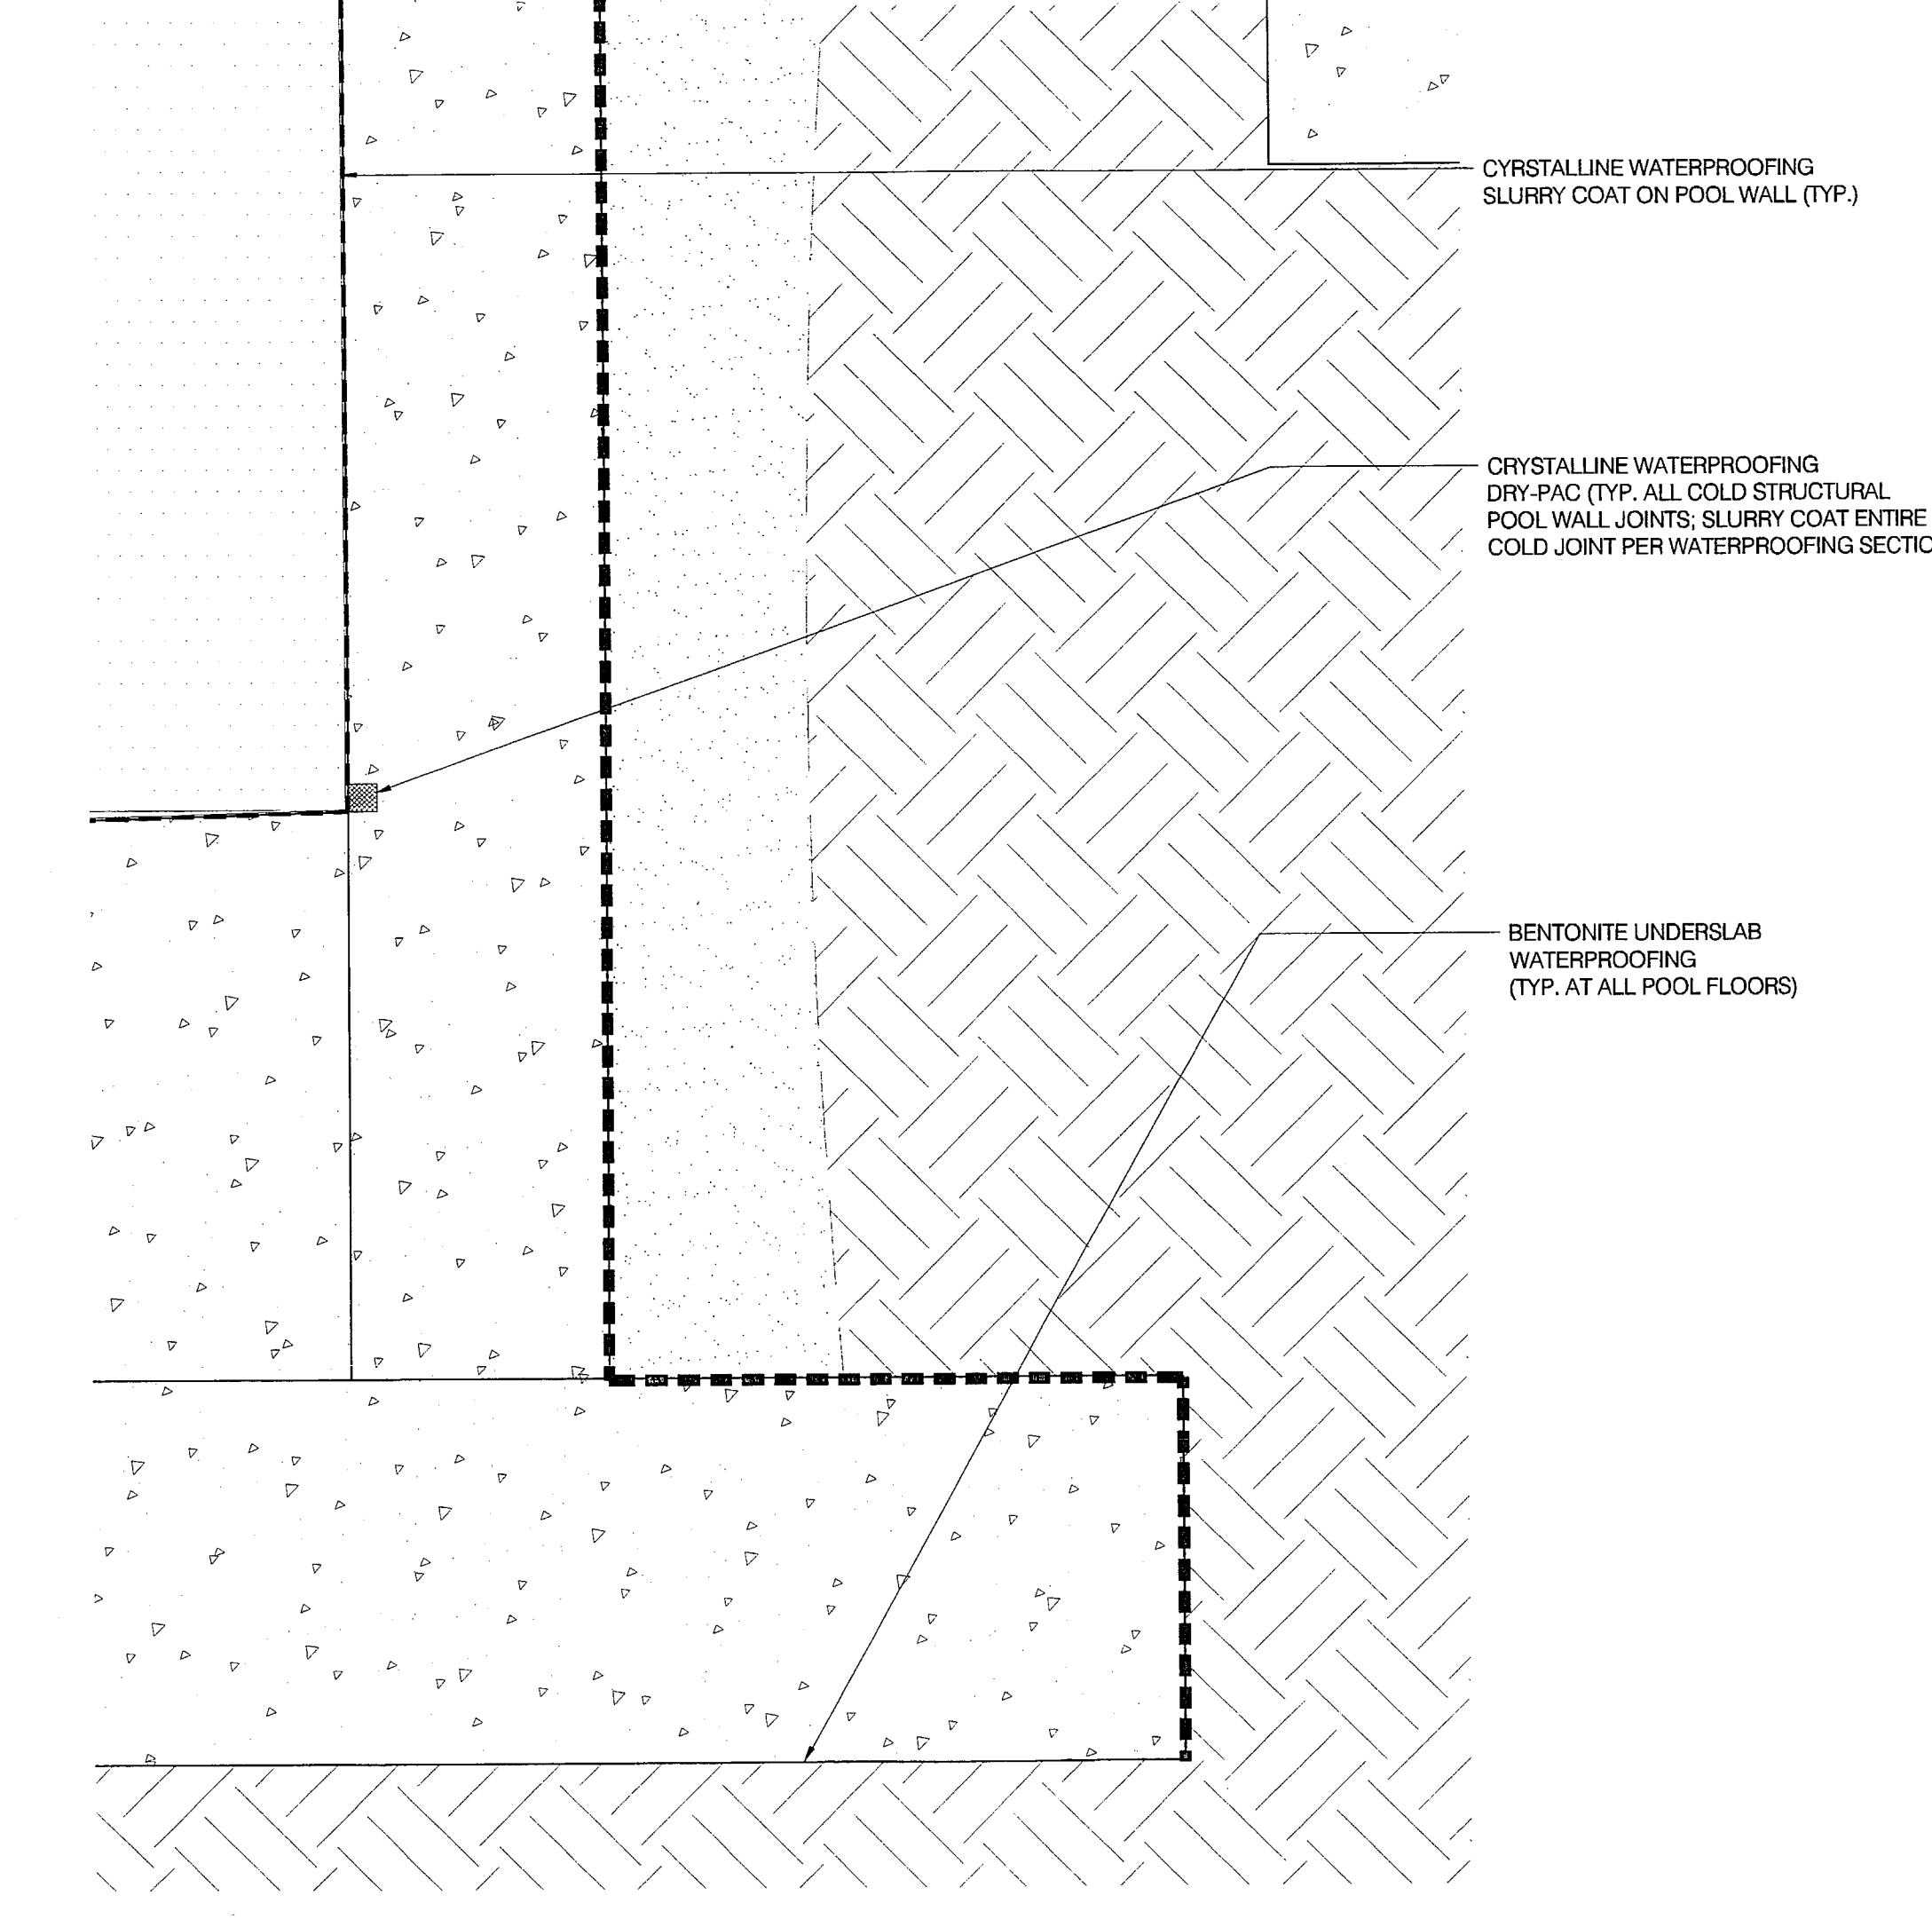

**01** POOL WALL - DIVING END WALL SECTION  
A8.02 1" = 1'-0"

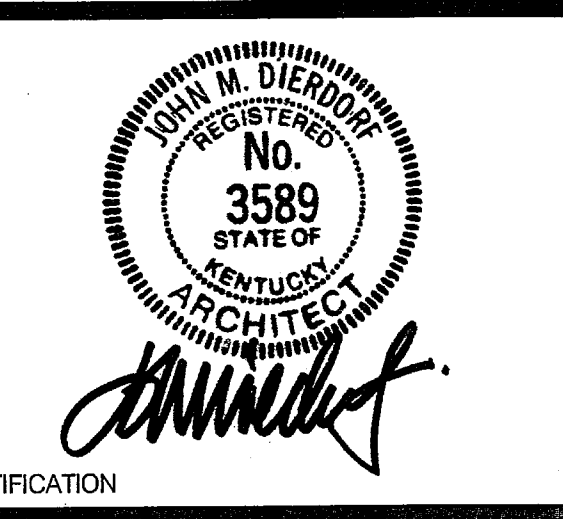

CERTIFICATION  
**CONSTRUCTION  
DOCUMENTS**

**CARDINAL PARK  
NATORIUM**

**UNIVERSITY OF LOUISVILLE**

Project: 03008  
Drawn: D. McCLOSKEY  
Checked: J. LINDSTAEDT  
Scale:  
Issue Date: AUGUST 27, 2003  
Revision:

**DIVING PLATFORMS**

**A8.02**

1/22/03 03:006 - Local NatoriumDraw\CD\0000000000.dwg 08/28/03 3:22PM