

BROWNING DAY MULLINS DIERDORF ARCHITECTS


Browning Day Mullins Dierdorf Architects
Architecture
Landscape Architecture
Planning

334 North Senate Avenue
Indianapolis, Indiana 46204
P: 317.634.5030
F: 317.634.5409
E-Mail: jindstaed@bdmd.com


Circle Design Group, Inc.
Mechanical Electrical Plumbing Engineers
5510 South East Street, Suite F
Indianapolis, Indiana 46227
P: 317.781.8200
F: 317.781.8201
E-Mail: kerry@circledesigngroup.com

Lawson Elser Engineering Consultants
Structural Engineers
650 East Carmel Drive, Suite 150
Carmel, Indiana 46032
P: 317.574.9429
F: 317.574.9431
E-Mail: mlawson@lawsonelser.com

Skees Engineering, Inc.
Civil Engineers
400 Blankenshaker Parkway, Suite 300
Louisville, KY 40243
P: 502.254.2344
F: 502.254.3008
E-Mail: cmckinnon@skees.com

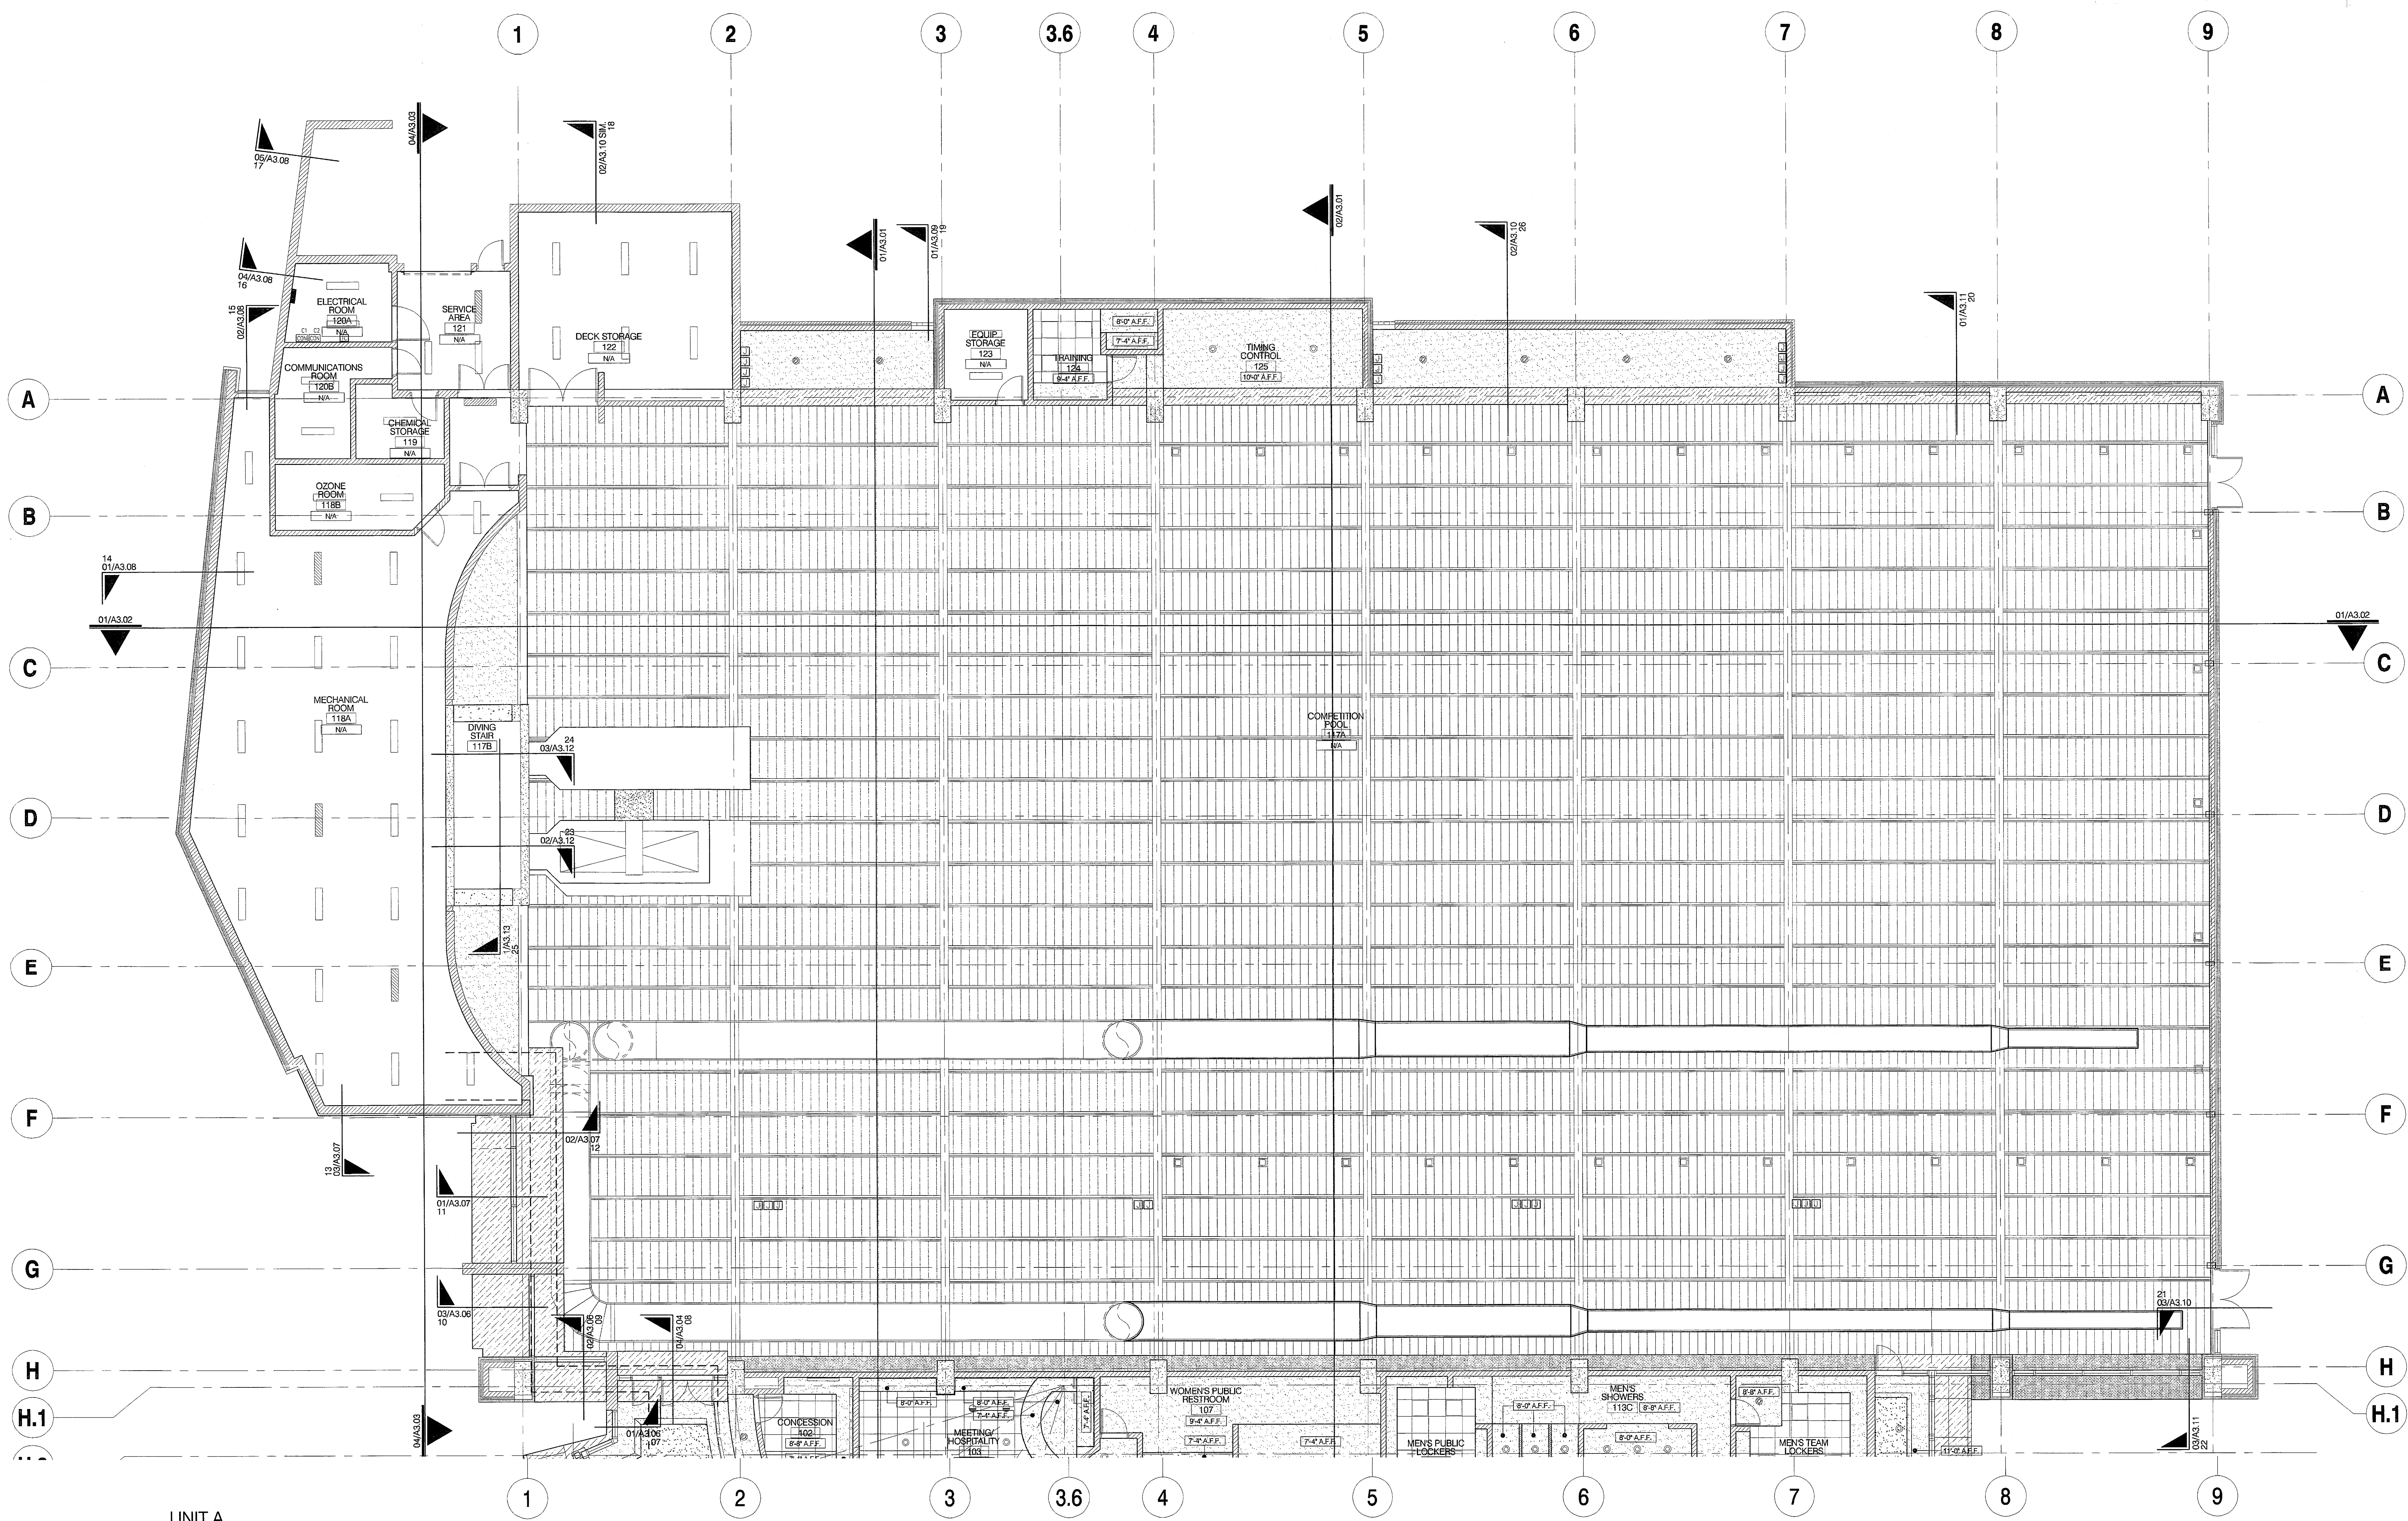

01 UNIT A REFLECTED CEILING PLAN
A7.01 1/8" = 1'-0"

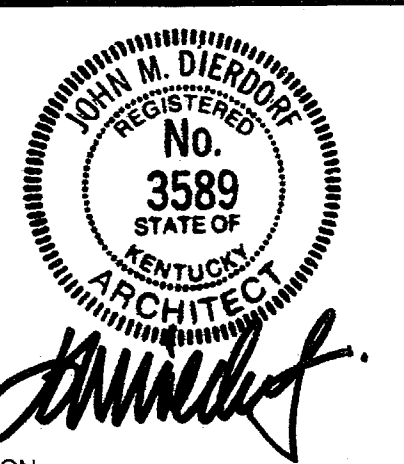

CERTIFICATION
CONSTRUCTION DOCUMENTS

CARDINAL PARK NATATORIUM

UNIVERSITY OF LOUISVILLE

Project: 03006
Drawn: D. MCCLOSKEY
Checked: J. LINDSTADT
Scale:
Issue Date: AUGUST 27, 2003
Revision:

MAIN LEVEL RCP
UNIT A

A7.01