


GENERAL NOTES:

- 1. PENDANT MOUNT TYPE "H" LIGHT FIXTURES AT 6'-0" BELOW ROOF DECK. MAINTAIN 5'-0" DISTANCE FROM WATERS EDGE BELOW.

PLAN NOTES:

- 1. NATATORIUM LIGHTING CONTROL SWITCH. INTERFACE TO LIGHTING CONTROLLER "C2" IN ELECTRICAL ROOM. REFERENCE SHEET E201.
- 2. MOUNT FIXTURE +12'-0" AFF TO CENTER OF FIXTURE. SEE CIRCUIT INFORMATION ON SHEET E201.
- 3. CONDUIT AND WIRING TO PANEL "H1". REFERENCE SHEET E203.
- 4. LOBBY LIGHTING CONTROL STATION.
- 5. NOT USED.
- 6. FLUSH MOUNTED JUNCTION BOX FOR UNDERWATER LIGHT FIXTURE TO BE LOCATED +12" TO CENTER ABOVE DECK. BOX TO HAVE TREATED WIRING WITH INTEGRAL GROUND LUGS AND GASKETED TO MEET THE REQUIREMENTS OF NEC. REFERENCE HYDREL 482716. STRAIN RELIEF TO BE PROVIDED WITH EACH BOX.
- 7. CONDUIT AND WIRE TO PANEL "L1" VA LIGHTING CONTROLLER "C1" IN ELECTRICAL ROOM. SEE SHEET E301 FOR CONTROLLER DETAILS.
- 8. CIRCUIT CONTINUED FROM SHEET E202.
- 9. WALL MOUNT FIXTURE ABOVE DOOR (APPROXIMATELY 6'-8" AFF).
- 10. CONDUIT AND WIRE TO PANEL "H1", CIRCUIT #31. REFERENCE SHEET E203.
- 11. MOUNT FIXTURE +13'-0" AFF.
- 12. 3 #10 AND 1 #10 GROUND TO PANEL "H1" VA LIGHTING CONTROLLER "C2" IN ELECTRICAL ROOM. SEE SHEET E301 FOR CONTROLLER DETAILS.
- 13. NOT USED.
- 14. INSTALL FIXTURE 24" BELOW WATER SURFACE.
- 15. MOUNT +10'-0" AFF.
- 16. MOUNT AS HIGH AS POSSIBLE.
- 17. MOUNT IN ARCHITECTURAL COVE.
- 18. MOUNT ON WALL BELOW CABINET.
- 19. MOUNT UNDER WRITING SURFACE.
- 20. MOUNT +24" AFF.
- 21. MOUNT +5'-8" AFF.

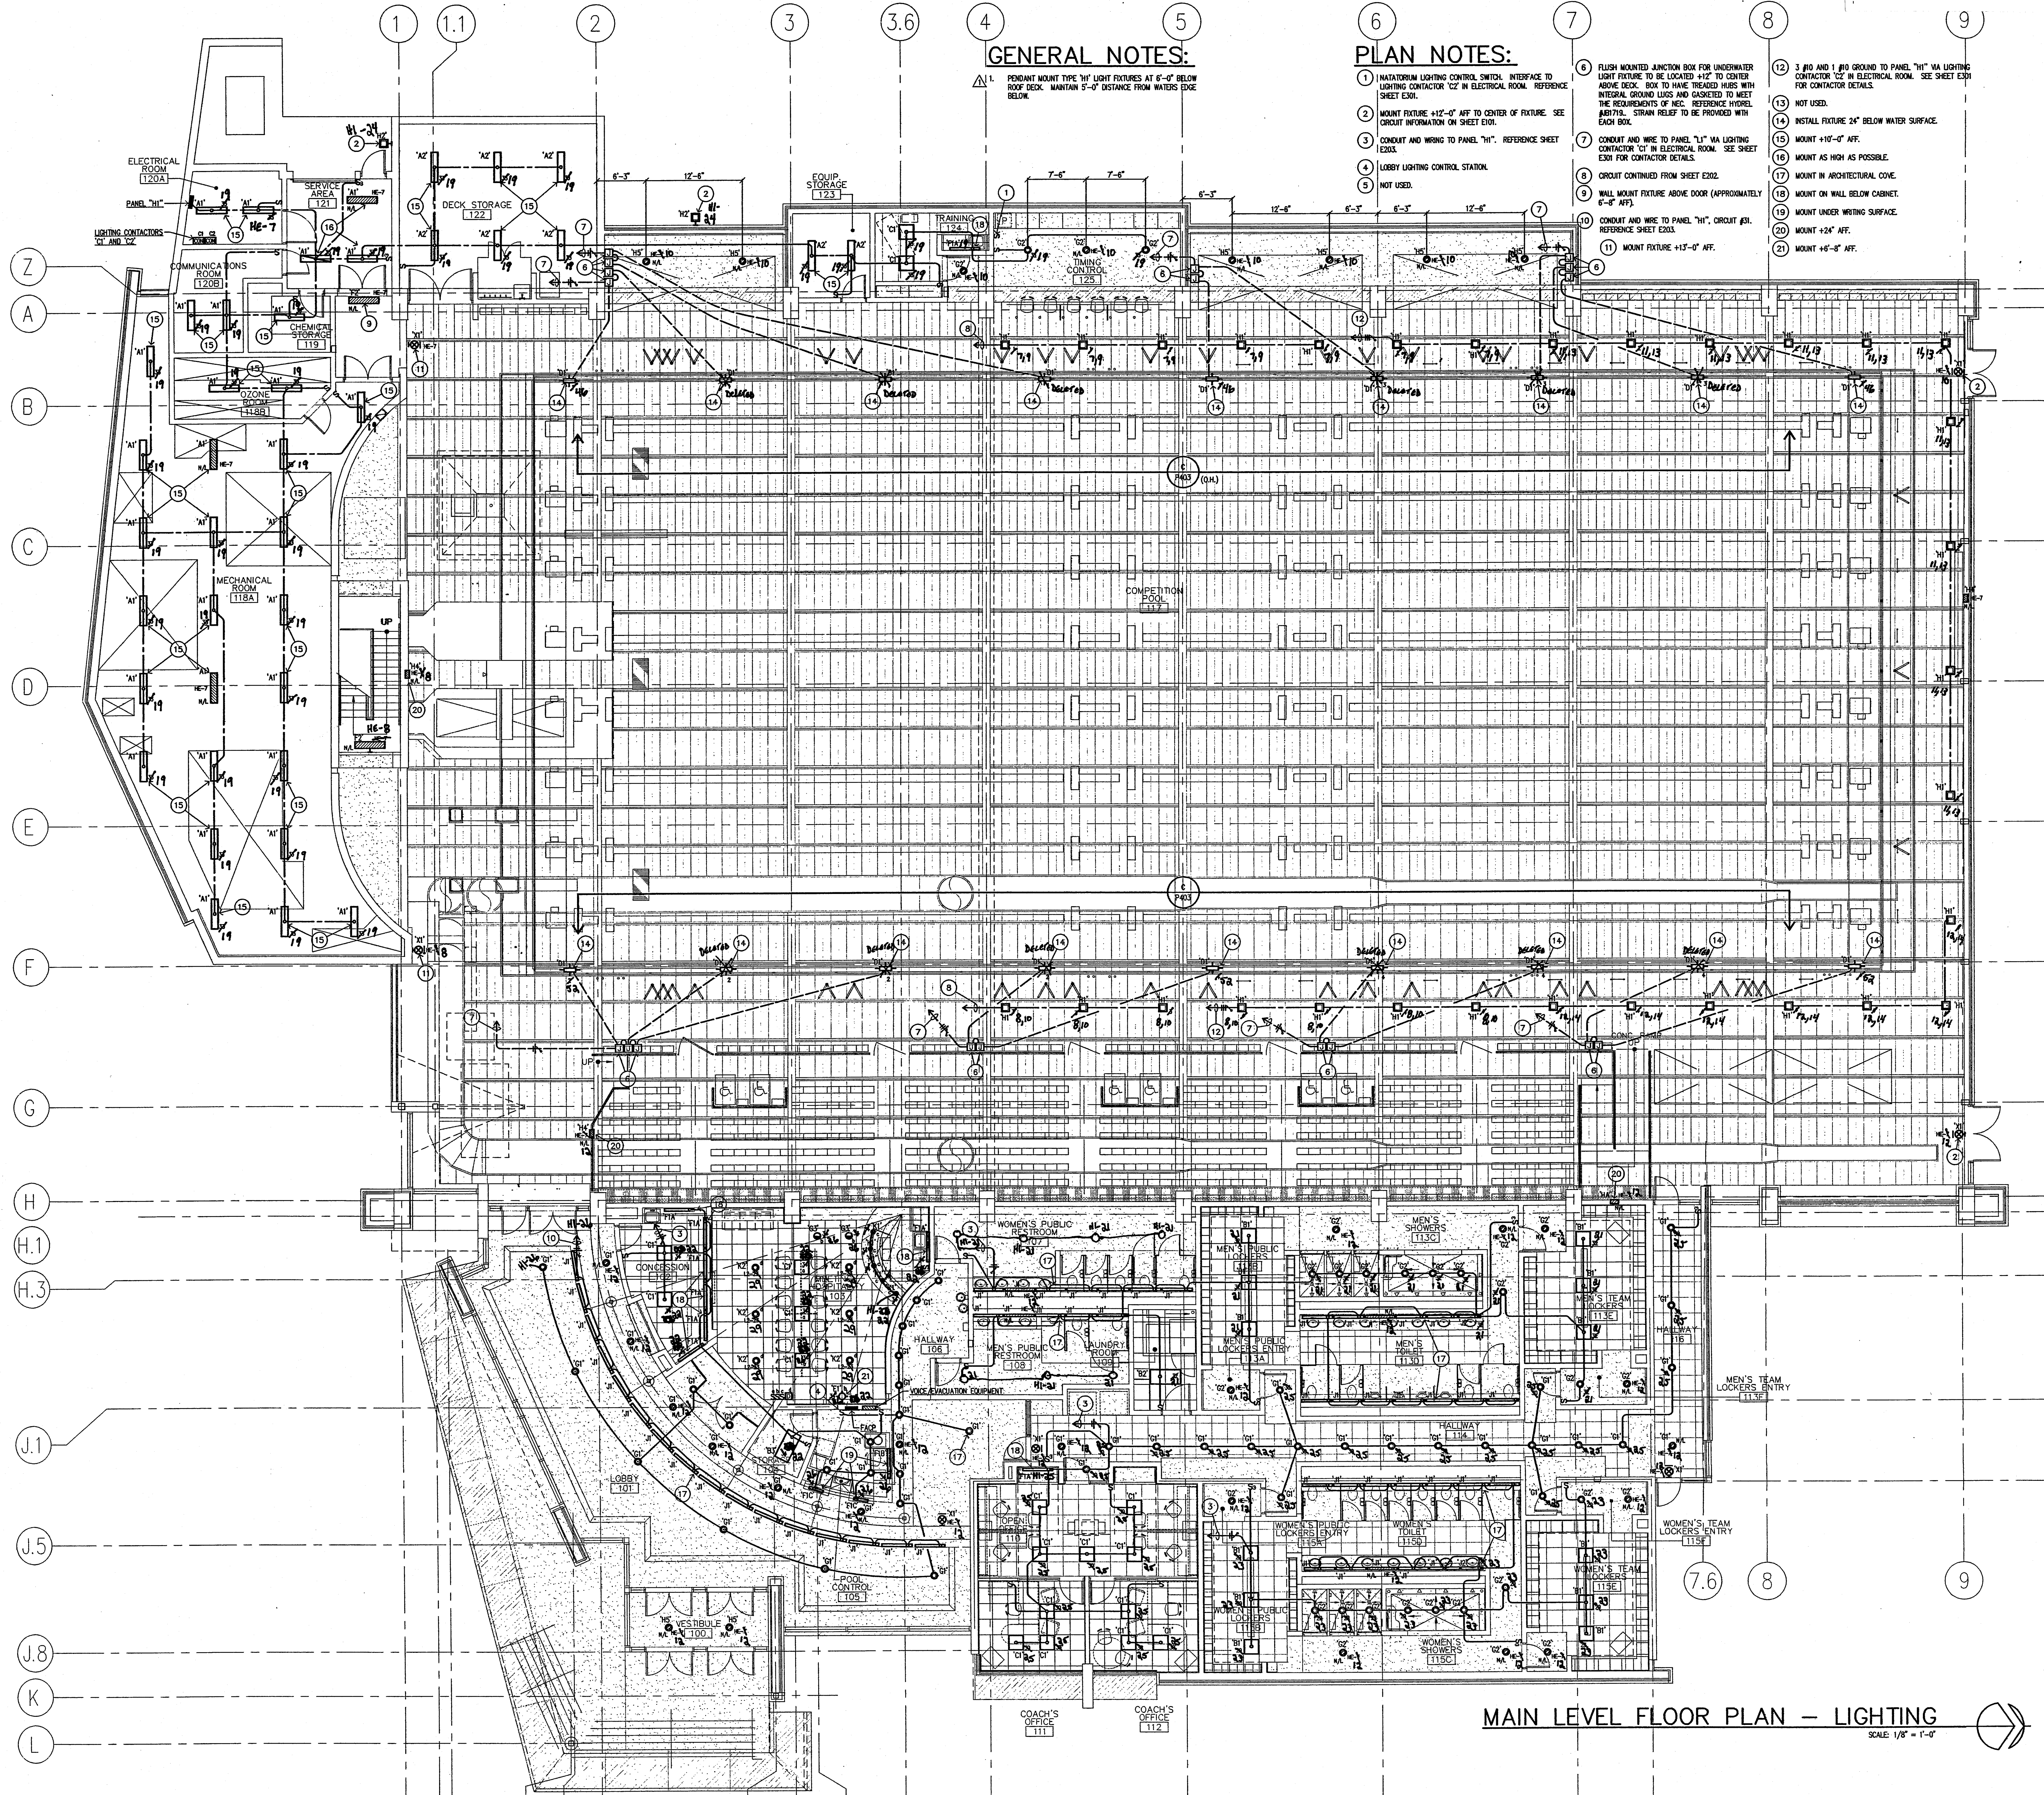

MAIN LEVEL FLOOR PLAN - LIGHTING
SCALE: 1/8" = 1'-0"

THIS SET IS A COMPILATION OF THE ORIGINAL BIDDING DOCUMENTS AND ADDENDA ONE THROUGH SEVEN. IT IS PROVIDED FOR CONVENIENCE ONLY. THE ARCHITECTS AND ENGINEERS SHALL NOT BE RESPONSIBLE FOR OMISSIONS FROM THE ORIGINAL BIDDING DOCUMENTS. REFER TO THE ORIGINAL BIDDING DOCUMENTS AND ADDENDA FOR RECORD DOCUMENTS AND CONTRACT DOCUMENTS.

CERTIFICATION
CONSTRUCTION DOCUMENTS

CARDINAL PARK NATATORIUM

UNIVERSITY OF LOUISVILLE

Project: 03005
 Drawn: LARRY STUFFLE
 Checked: JEFF WYLLIE
 Scale: 1/8" = 1'-0"
 Issue Date: AUGUST 28, 2003
 Revisions: 10.20.03 ADDENDUM #4
 03.30.04 TRAILER SET

MAIN LEVEL FLOOR PLAN LIGHTING
E201