


GENERAL NOTES:

1. PENDANT MOUNT TYPE "H" LIGHT FIXTURES AT 8'-0" BELOW ROOF DECK.
MAINTAIN 5'-0" DISTANCE FROM WATERS EDGE BELOW.

PLAN NOTES:

- 1 WALL MOUNT LIGHT FIXTURE IN STAIRWELL AT EACH DIVING PLATFORM
EXIT LANDING. TYPICAL OF THREE.
- 2 CIRCUIT CONTINUED ON SHEET E201.
- 3 #10 AND #1 #10 GROUND TO PANEL "H" VIA LIGHTING CONTACTOR "C2"
IN ELECTRICAL ROOM. SEE SHEET E301 FOR CONTACTOR DETAILS.
- 4 CONDUIT AND WIRING DOWN TO PANEL "H" IN ELECTRICAL ROOM.
- 5 MOUNT +10'-0" AFF AFTER ALL DUCT WORK IS INSTALLED.

302-01-12 Natatorium-Orig-2003-Elect-Light-E202-uppr mech m p1-BD-TIFF

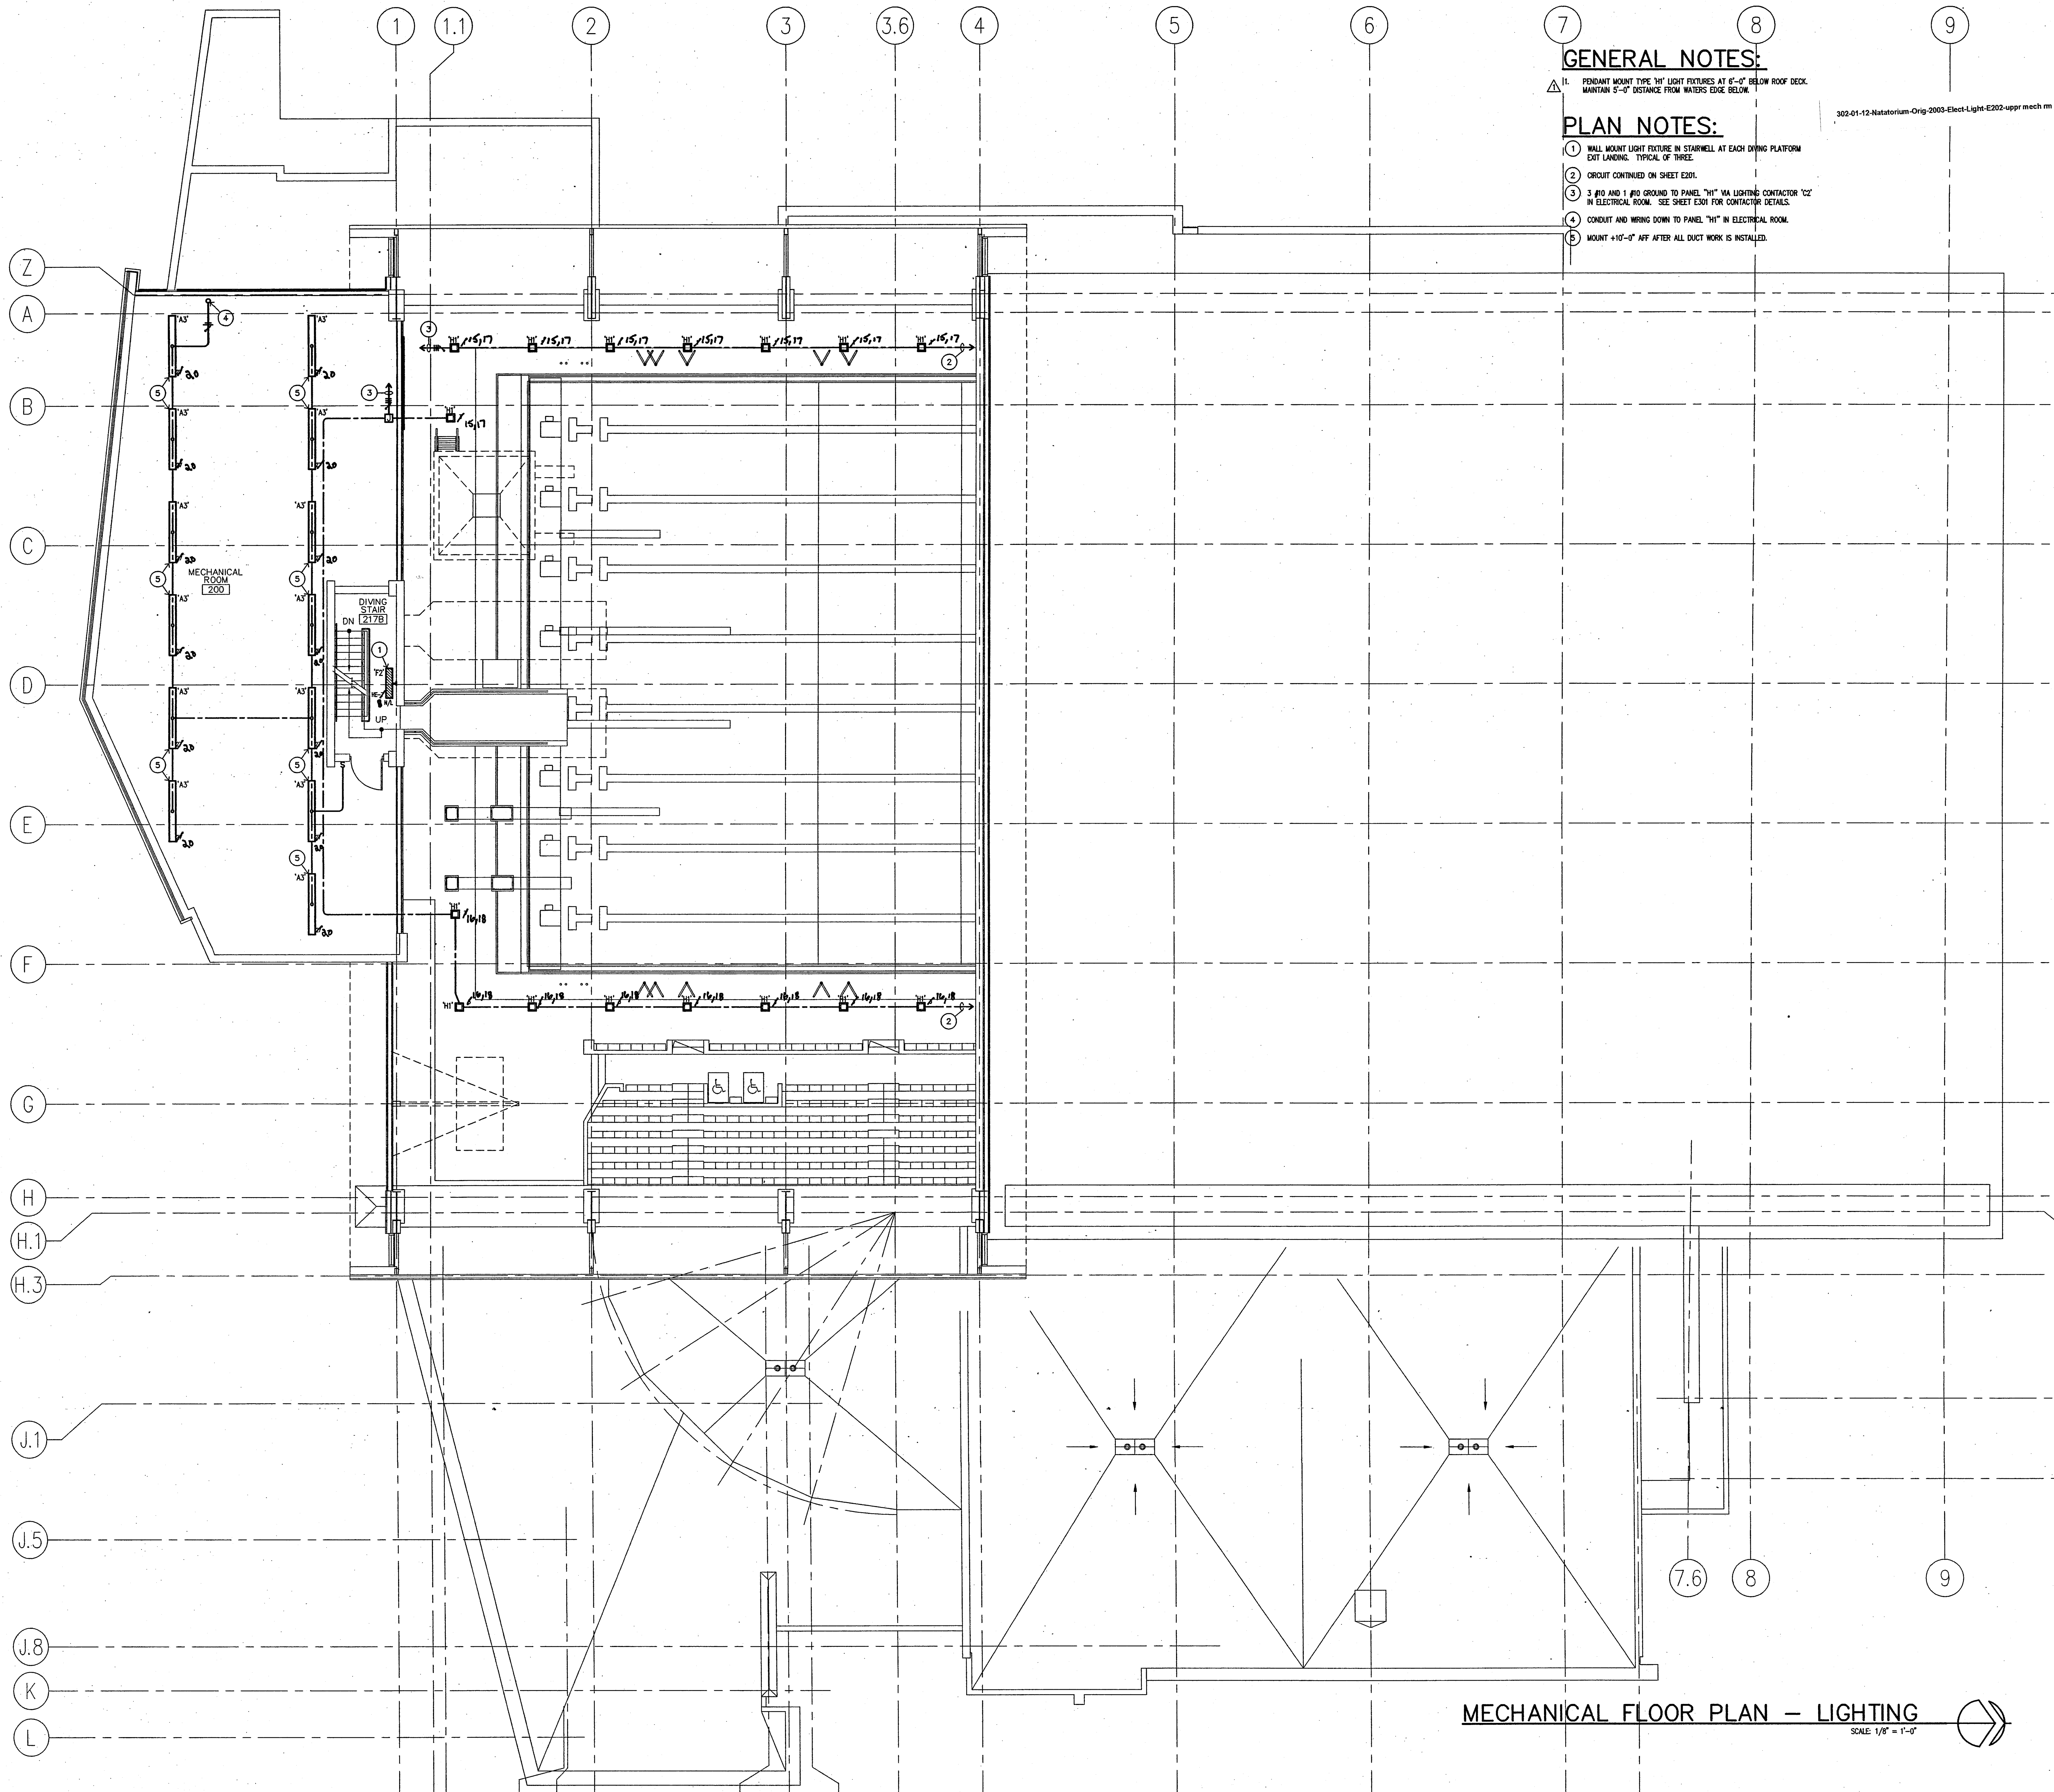

THIS SET IS A COMPILATION OF THE ORIGINAL BIDDING DOCUMENTS AND ADDENDA ONE THROUGH SEVEN. IT IS PROVIDED FOR CONVENIENCE ONLY. THE ARCHITECTS AND ENGINEERS SHALL NOT BE RESPONSIBLE FOR OMISSIONS FROM THE ORIGINAL BIDDING DOCUMENTS. REFER TO THE ORIGINAL BIDDING DOCUMENTS AND ADDENDA FOR RECORD DOCUMENTS AND CONTRACT DOCUMENTS.

**CERTIFICATION
CONSTRUCTION
DOCUMENTS**

**CARDINAL PARK
NATATORIUM**

UNIVERSITY OF LOUISVILLE

Project: 03006
Drawn: LARRY STUFFLE
Checked: JEFF WYLIE
Scale: 1/8" = 1'-0"
Issue Date: AUGUST 28, 2003
Revision: 10.20.03 ADDENDUM #1
03.30.04 TRAILER SET

**MECHANICAL
FLOOR PLAN
LIGHTING
E202**

G:\elect\03006\E202.dwg, 03/29/2004 01:47:51 PM, Danyie Zybert