

Browning Day Mullins Dierdorf Inc
Architecture
Landscape Architecture
Planning

334 North Senate Avenue
Indianapolis, IN 46204
P: 317.836.5030
F: 317.834.5409
E-MAIL: jimdiedt@bmd.com

Circle Design Group, Inc.
MEP Engineer

5510 S. East Street, Suite F
Indianapolis, Indiana 46227
PHONE: 317.781.6200
FAX: 317.781.6201
E-MAIL: kerry@circledesigngroup.com

Lawson Elser Engineering Consultants
Structural Engineers

850 East Carmel Drive, Suite 310
Carmel, Indiana 46032
P: 317.574.8409
F: 317.574.8431
E-MAIL: mlawson@lawsonelser.com

Skees Engineering Inc.
Civil Engineers


400 Blankenbaker Parkway, Suite 300
Louisville, KY 40243
P: 802.284.2344
F: 802.284.2008
E-MAIL: dmckinnon@skees.com

GENERAL NOTES: PLAN NOTES:

- 1. INSTALL DOUBLE GANG BOX WITH 3/4" CONDUIT TO ACCESSIBLE SPACE ABOVE CEILING FOR DATA/COMMUNICATION AND OUTLETS. INSTALL PULL STRING IN CONDUIT.
- 2. 4" X 4" X 6" PVC BOX (CARLON #899NRT) 18" FROM BULKHEAD EDGE.
- 3. SINGLE GANG BOX IN CABINET. INSTALL 3/4" CONTROL CONDUIT TO TELEVISION LOCATION.
- 4. 2" X 4" WALL J-BOX FOR PACE CLOCK. MOUNT AT +5'-7" AFF.
- 5. 12" X 12" X 6" PVC BOX. (CARLON #899R)
- 6. 4" X 4" X 6" DECK BOX. (CARLON #899NR)

- 7. 11" X 15" X 7" BULKHEAD INTERFACE.
- 8. MOUNT TO MILLWORK AT +4" AFF.
- 9. 3" CONDUIT WITH PULL STRING TO COMMUNICATIONS ROOM FOR DATA/COMMUNICATION SERVICE.
- 10. 4-3" CONDUITS, STUB TO ACCESSIBLE SPACE ABOVE CONCESSION 102 CEILING, THROUGH CHASE IN SOUTHWEST CORNER OF ROOM.
- 11. 4" X 12" WIRE BASKET FOR DATA/COMMUNICATION SERVICE INSTALLED ABOVE CEILING.
- 12. NOT USED.
- 13. NOT USED.
- 14. TWO WAY COMMUNICATION TO POOL CONTROL.
- 15. PUSH BUTTON DOOR CONTROL FOR:
 - a. DOOR 114A
 - b. DOOR 114B
 - c. DOOR 1218
- 16. IN CEILING PLENUM ABOVE FOR SHUTDOWN OF AHU.

- 17. STUB TWO-3/4" CONDUITS TO A POINT 6"-1" FROM EXTERIOR WALL AND CAP ACCORDINGLY. INSTALL TO ACCESSIBLE SPACE ABOVE CEILING.
- 18. NOT USED.
- 19. NOT USED.
- 20. NOT USED.
- 21. SUSPEND 15" LOUSPEAKER AT 28'-0" ABOVE DECK WITH REQUIRED AIRCRAFT CABLE AND FITTINGS.
- 22. SUSPEND 12" LOUSPEAKER AT 28'-0" ABOVE DECK WITH REQUIRED AIRCRAFT CABLE AND FITTINGS.
- 23. MASTER INTERCOM FOR TWO WAY COMMUNICATION TO DOOR 1218 AND DOOR 1170. REFERENCE PHONE MODEL LAF-5.

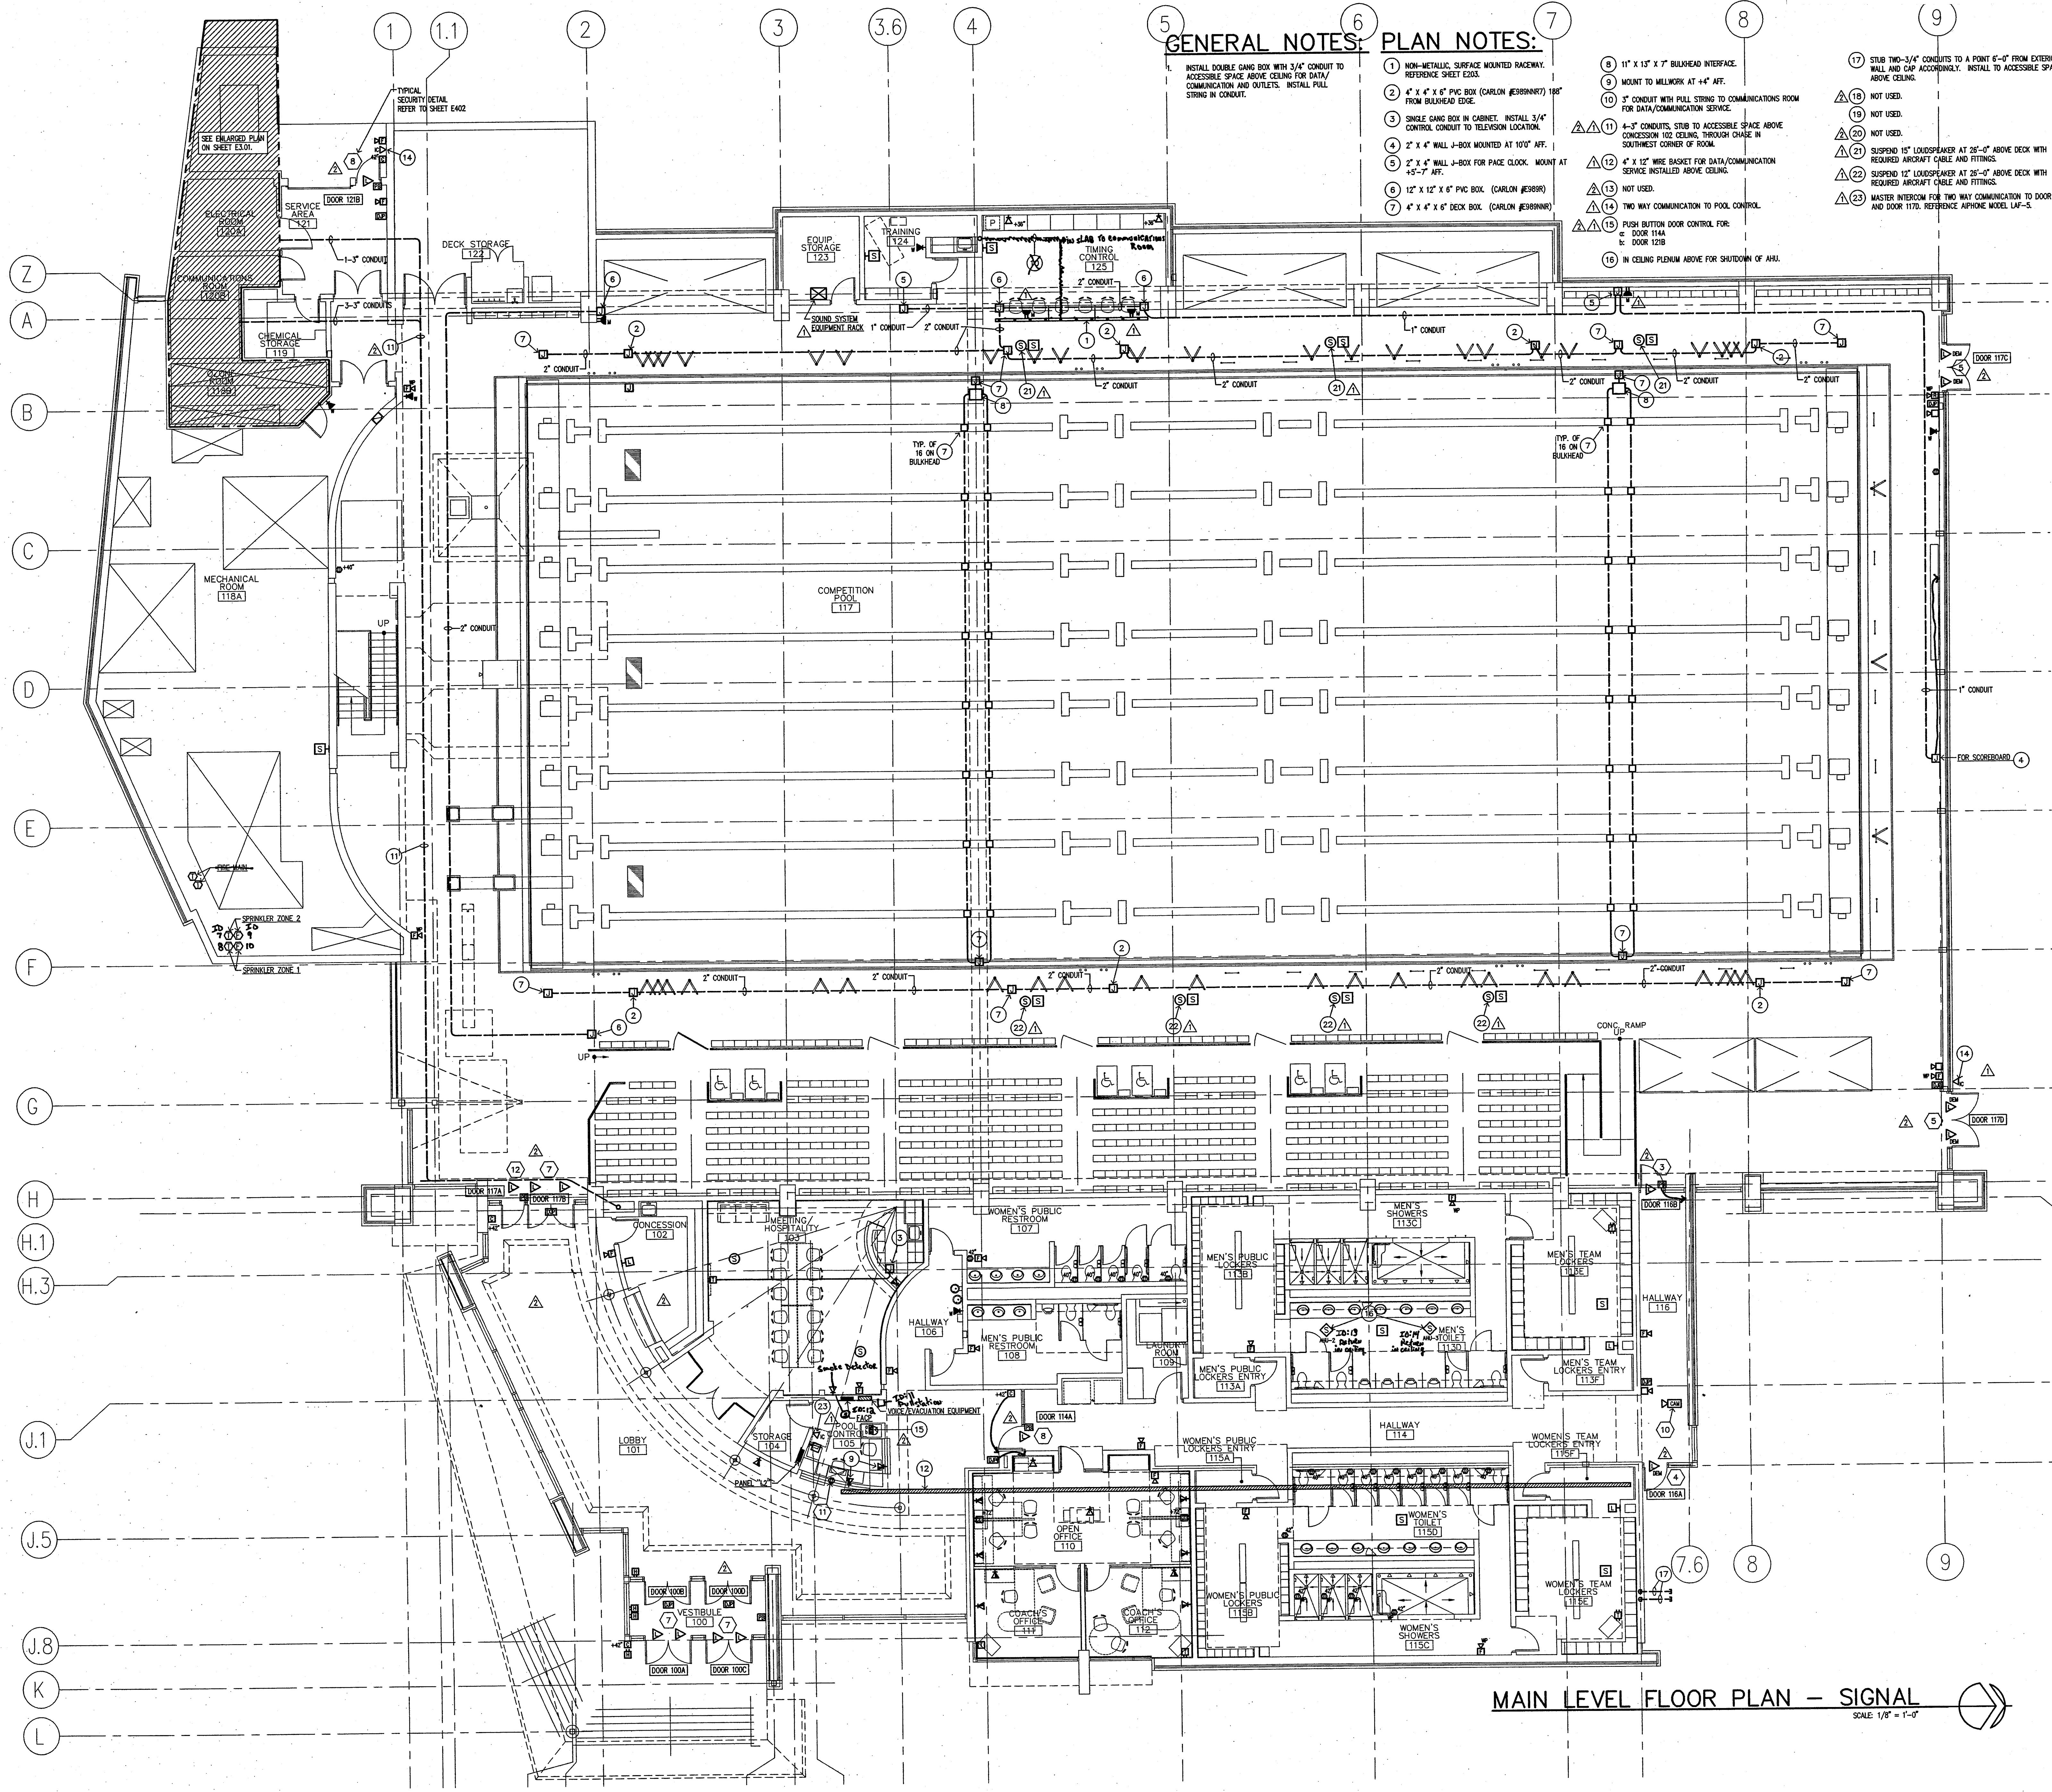

MAIN LEVEL FLOOR PLAN - SIGNAL
SCALE: 1/8" = 1'-0"

THIS SET IS A COMPILATION OF THE ORIGINAL BIDDING DOCUMENTS AND ADDENDA ONE THROUGH SEVEN. IT IS PROVIDED FOR CONVENIENCE ONLY. THE ARCHITECTS AND ENGINEERS SHALL NOT BE RESPONSIBLE FOR OMISSIONS FROM THE ORIGINAL BIDDING DOCUMENTS. REFER TO THE ORIGINAL BIDDING DOCUMENTS AND ADDENDA FOR RECORD DOCUMENTS AND CONTRACT DOCUMENTS.

**CERTIFICATION
CONSTRUCTION
DOCUMENTS**

**CARDINAL PARK
NATATORIUM**

UNIVERSITY OF LOUISVILLE

Project: 03006
 Drawn: LARRY STUFFLE
 Checked: JEFF WYLIE
 Scale: 1/8" = 1'-0"
 Issue Date: AUGUST 28, 2003
 Revisor: 10.7.03 ADDENDUM #2
 10.20.03 ADDENDUM #4
 03.30.04 TRAILER SET

**MAIN LEVEL FLOOR
PLAN - SIGNAL**

E205