

302-01-12-Natorium-Orig-2003-Elect-signal-E206-uppr mech m pl-BD-TFF

THIS SET IS A COMPILATION OF THE ORIGINAL BIDDING DOCUMENTS AND ADDENDA ONE THROUGH SEVEN. IT IS PROVIDED FOR CONVENIENCE ONLY. THE ARCHITECTS AND ENGINEERS SHALL NOT BE RESPONSIBLE FOR OMISSIONS FROM THE ORIGINAL BIDDING DOCUMENTS. REFER TO THE ORIGINAL BIDDING DOCUMENTS AND ADDENDA FOR RECORD DOCUMENTS AND CONTRACT DOCUMENTS.


**CERTIFICATION**  
**CONSTRUCTION DOCUMENTS**

**CARDINAL PARK NATATORIUM**

**UNIVERSITY OF LOUISVILLE**

Project: 03008  
Drawn: LARRY STUFFLE  
Checked: JEFF WYLE  
Scale: 1/8" = 1'-0"  
Issue Date: AUGUST 28, 2003  
Revisions:  $\Delta$  10.7.03 ADDENDUM #2  
 $\Delta$  03.30.04 TRAILER SET

**MECHANICAL FLOOR PLAN SIGNAL**  
**E206**

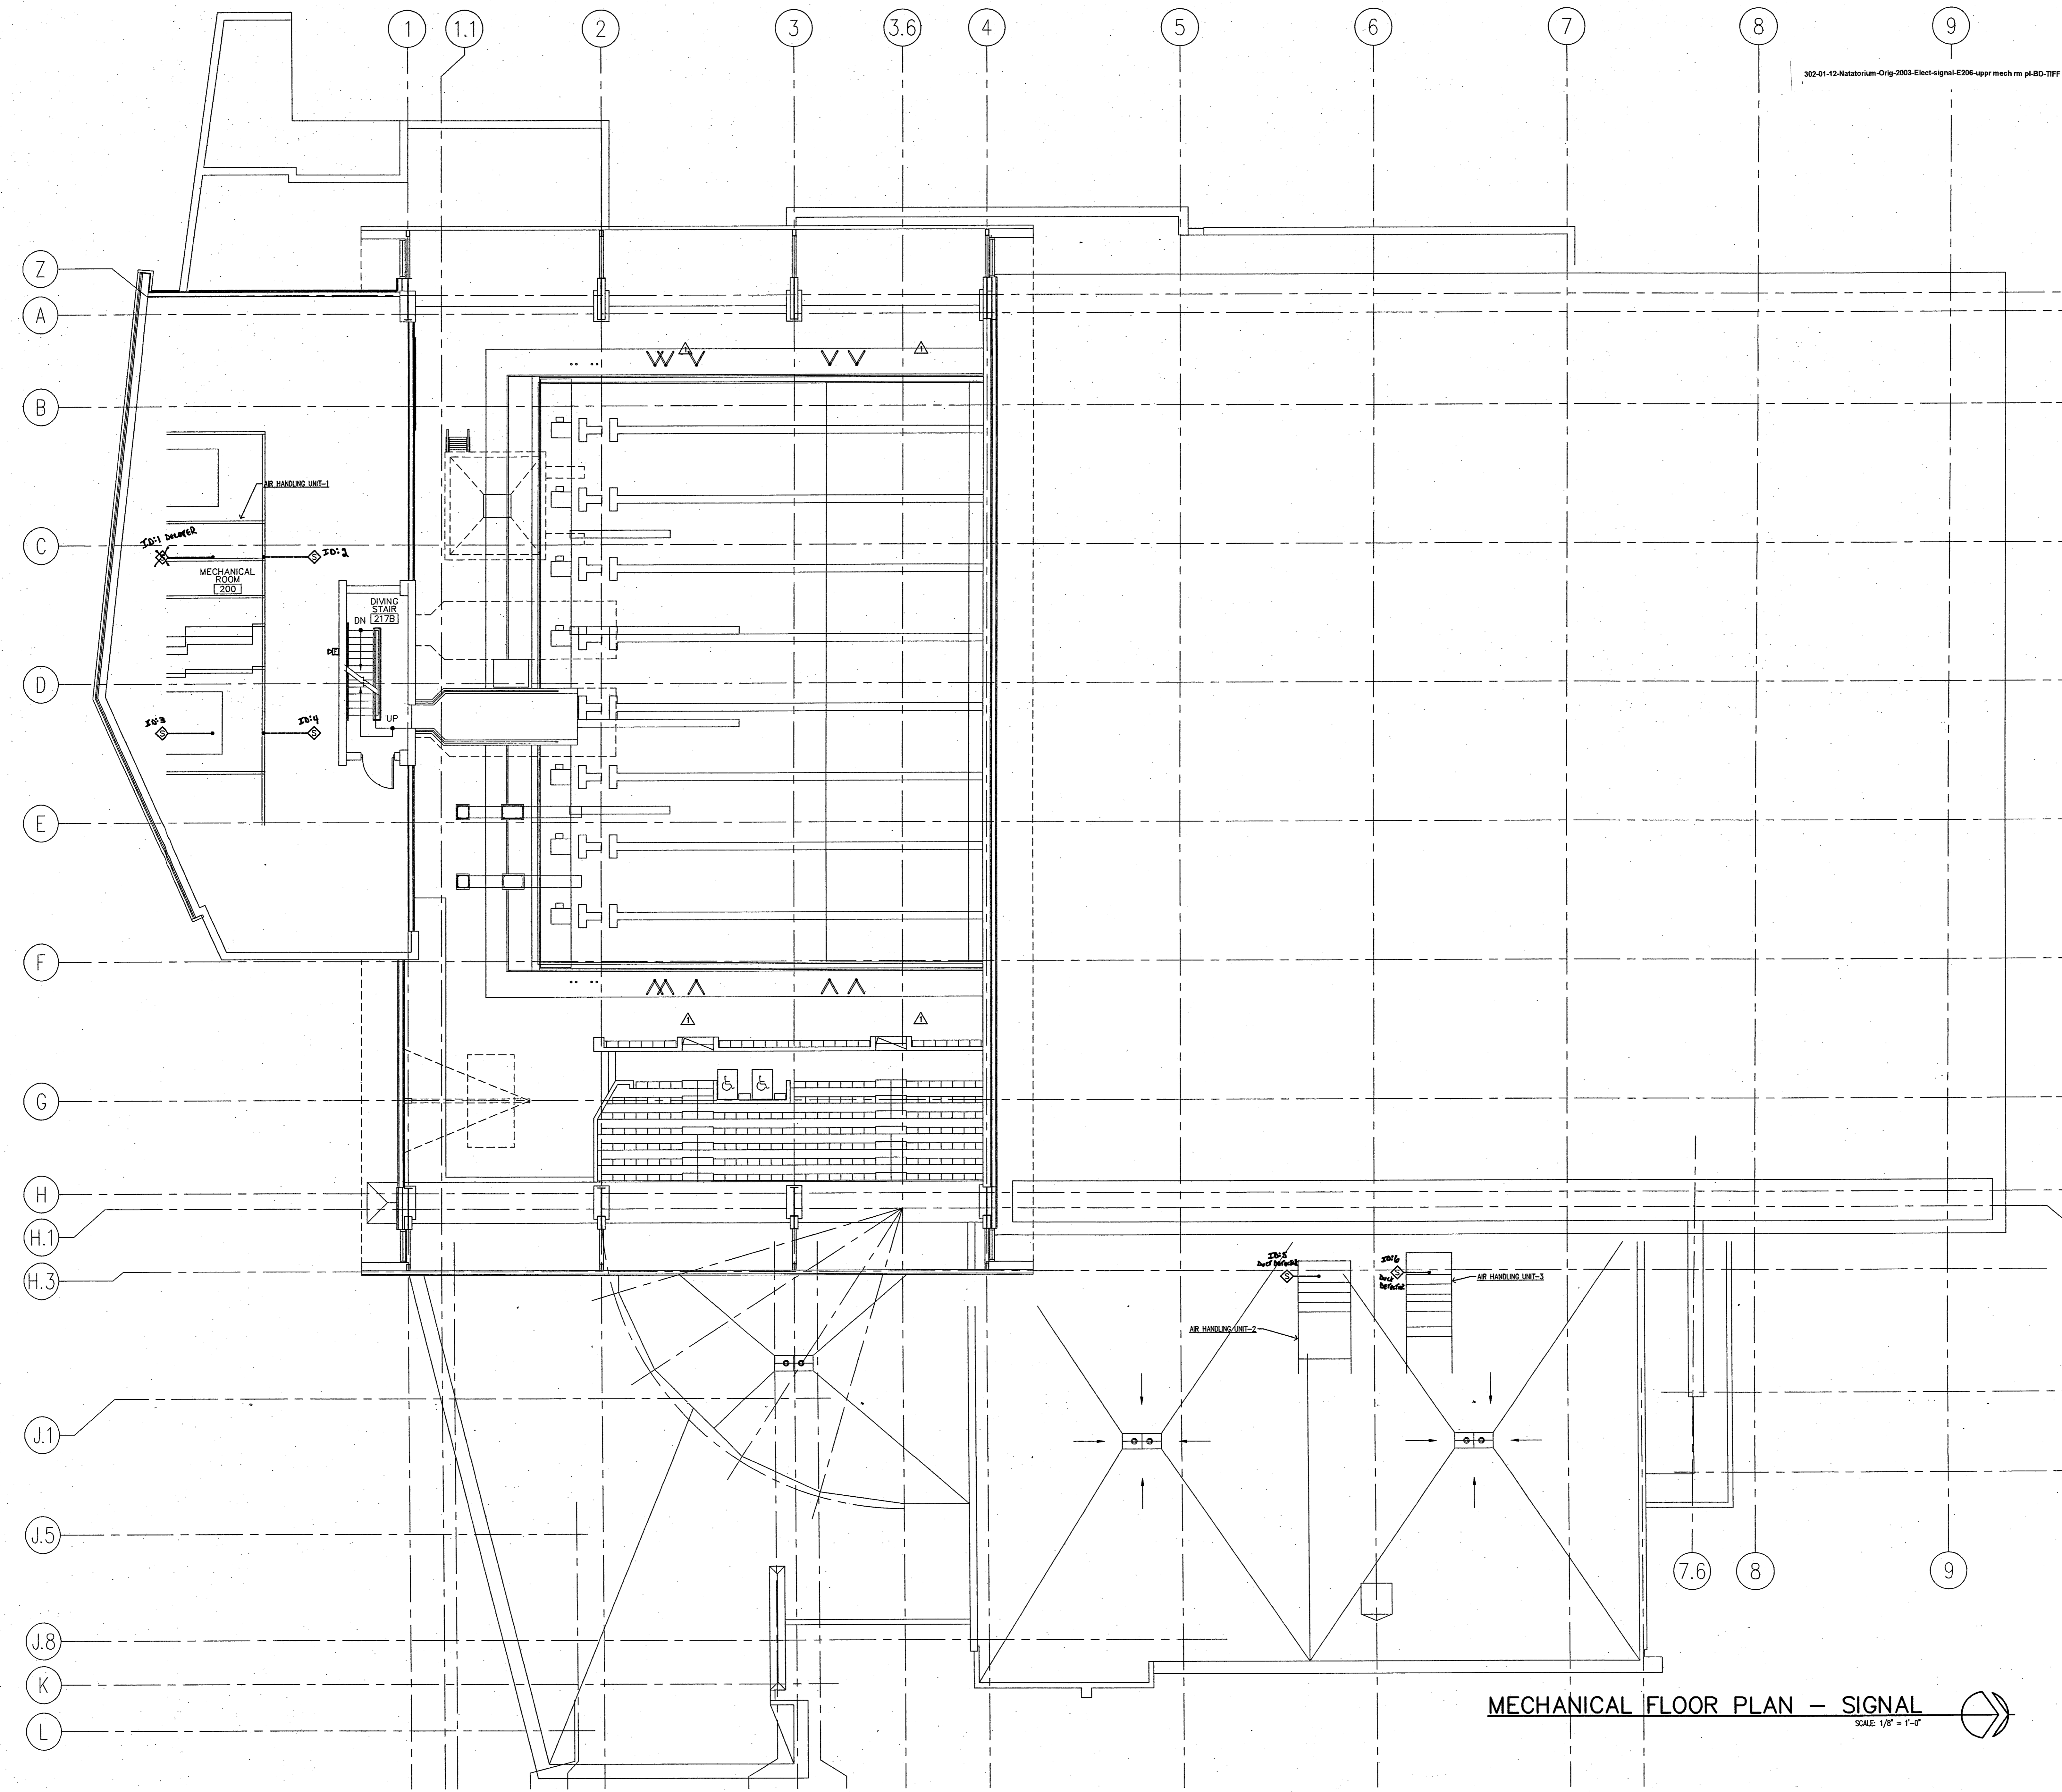

**MECHANICAL FLOOR PLAN - SIGNAL**  
SCALE: 1/8" = 1'-0"

G:\elect\03008\E206.dwg, 03/29/2004, 01:49:09 PM, Darlye Zylbert