



302-01-12-Natatorium-Orig-2003-Mech-duct-H202-uppr mech m pl-BD-TIFF

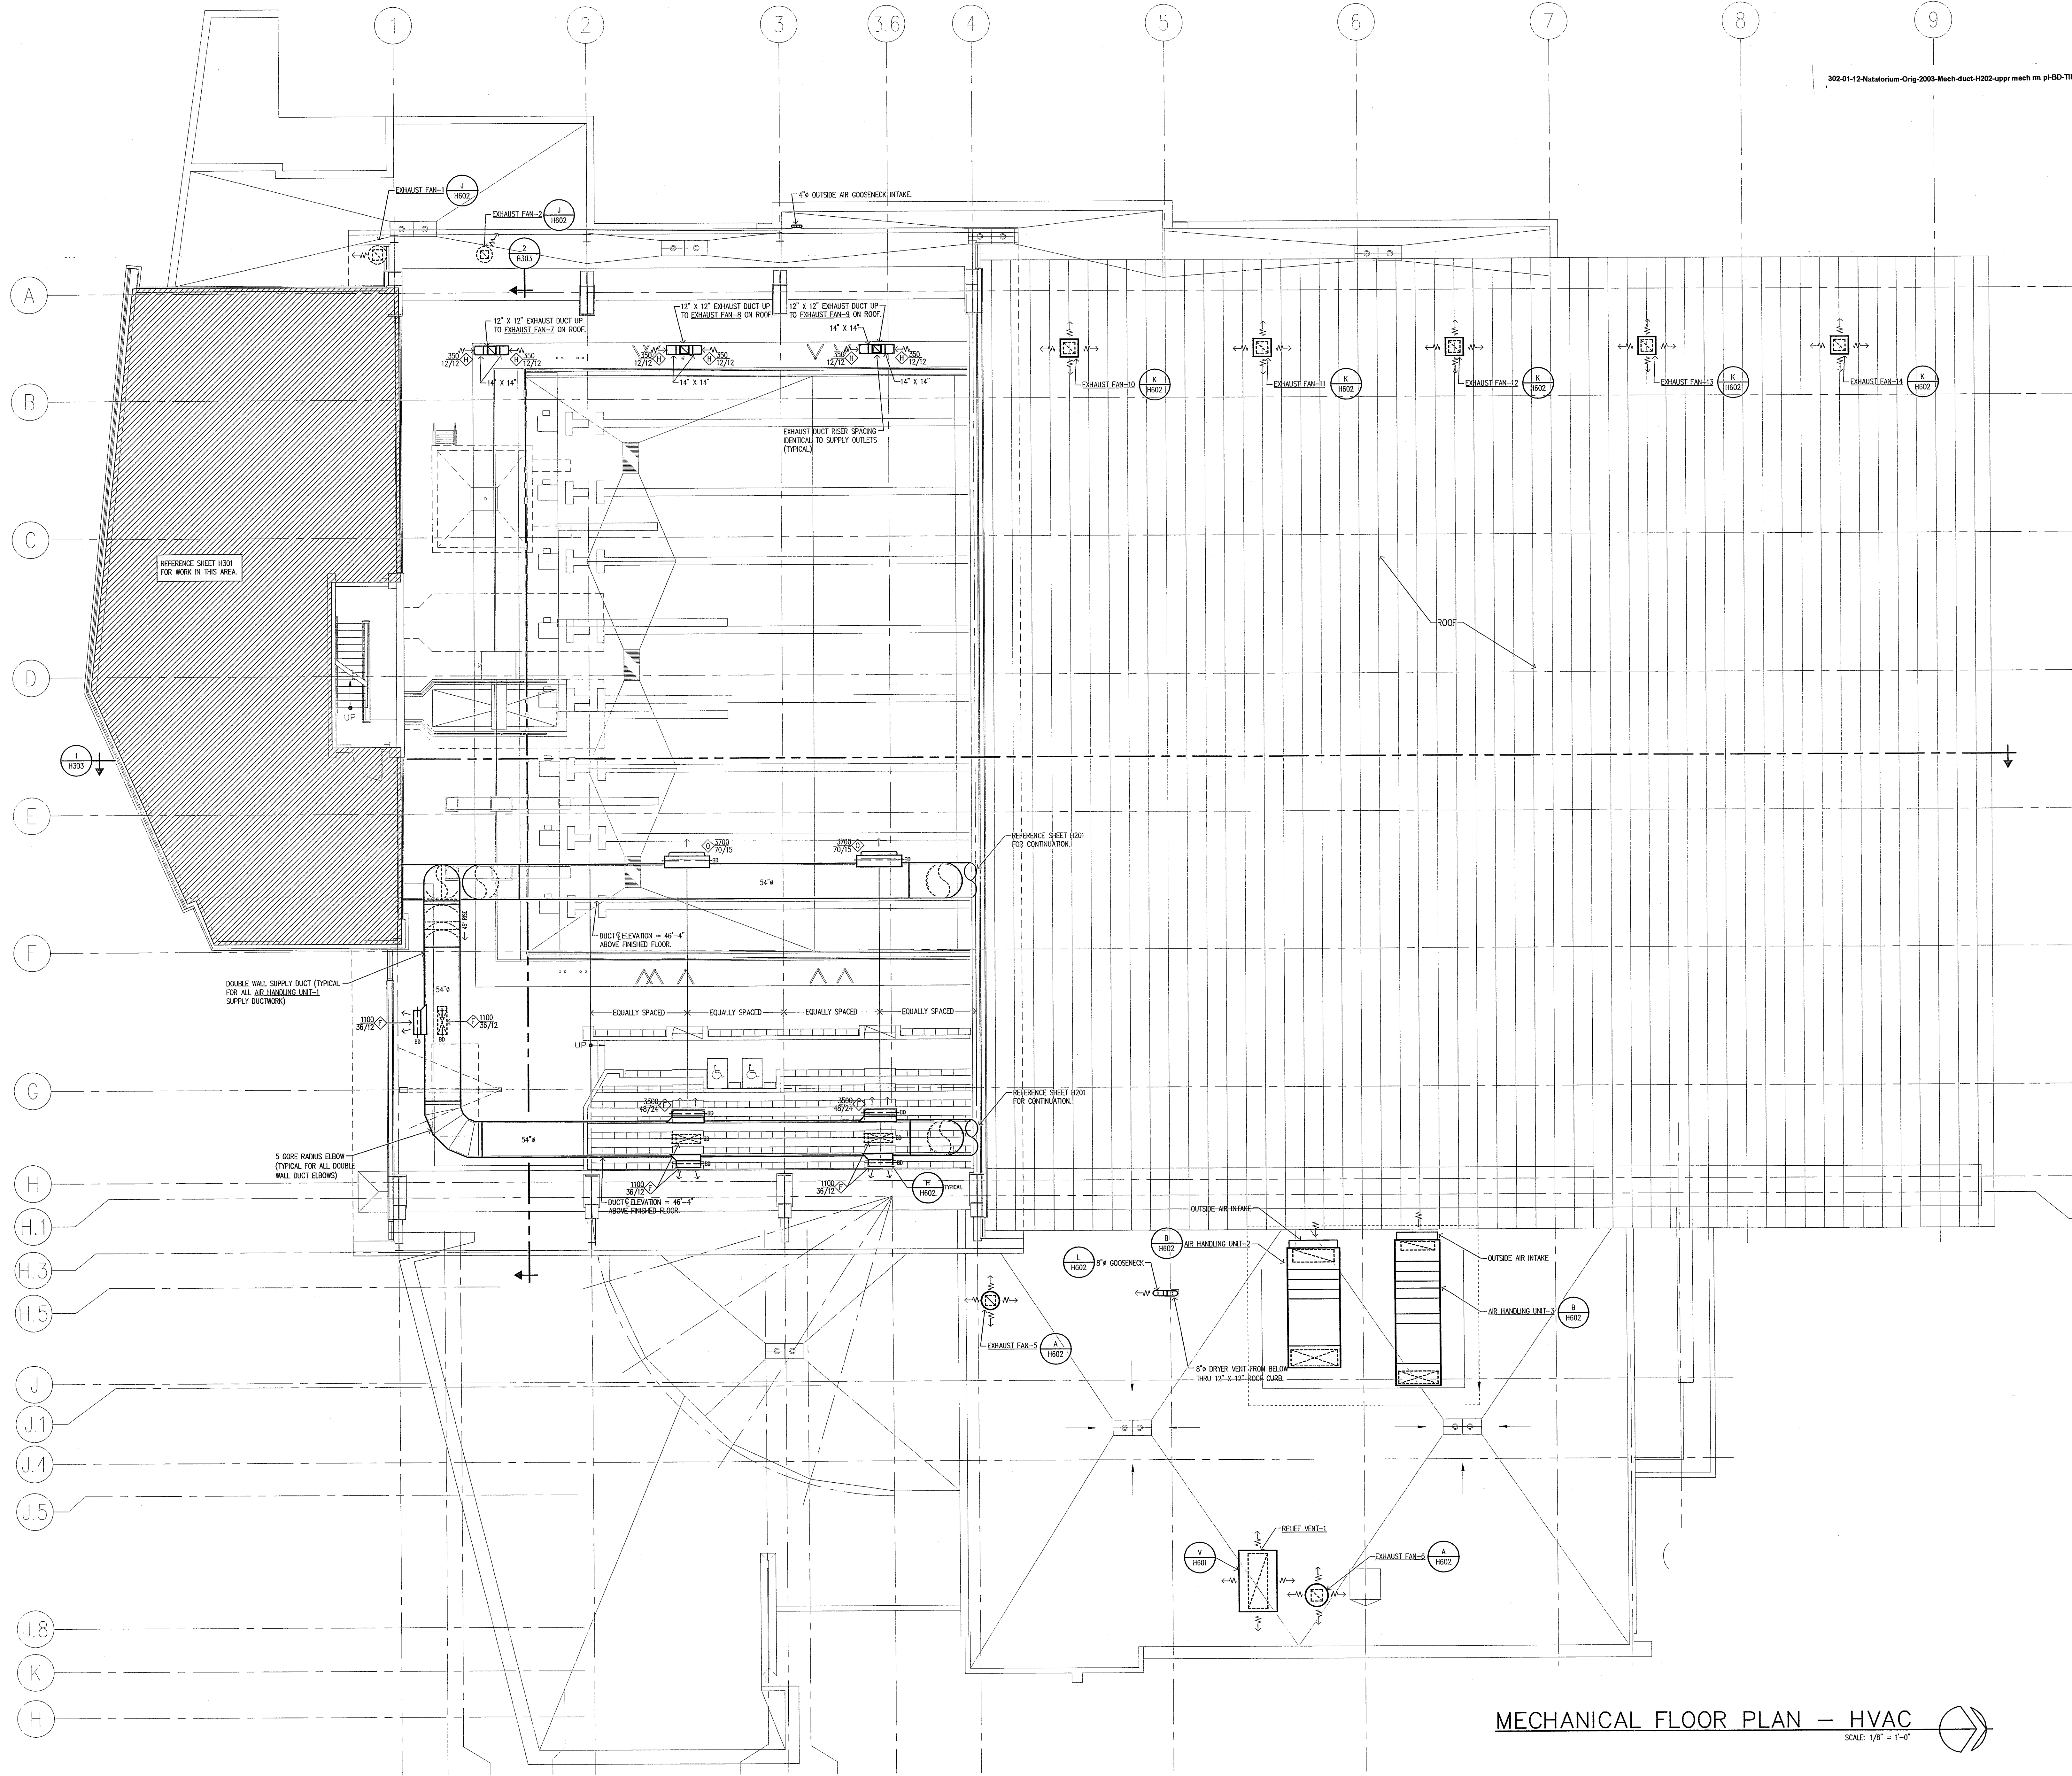

MECHANICAL FLOOR PLAN - HVAC
SCALE: 1/8" = 1'-0"

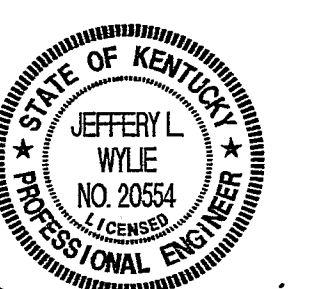

Jeffery L. Wyle

**CONSTRUCTION
DOCUMENTS**

**CARDINAL PARK
NATATORIUM**

UNIVERSITY OF LOUISVILLE

Project: 03006
Drawn: ROBERT E. SMITH
Checked: KERRY L. SMITH
Scale: 1/8" = 1'-0"
Issue Date: AUGUST 28, 2003
Revision:

**MECHANICAL FLOOR
PLAN - HVAC**

H202