



302-01-12-Natatorium-Orig-2003-Mech-hydro-H203-main M pl-BD-TIFF

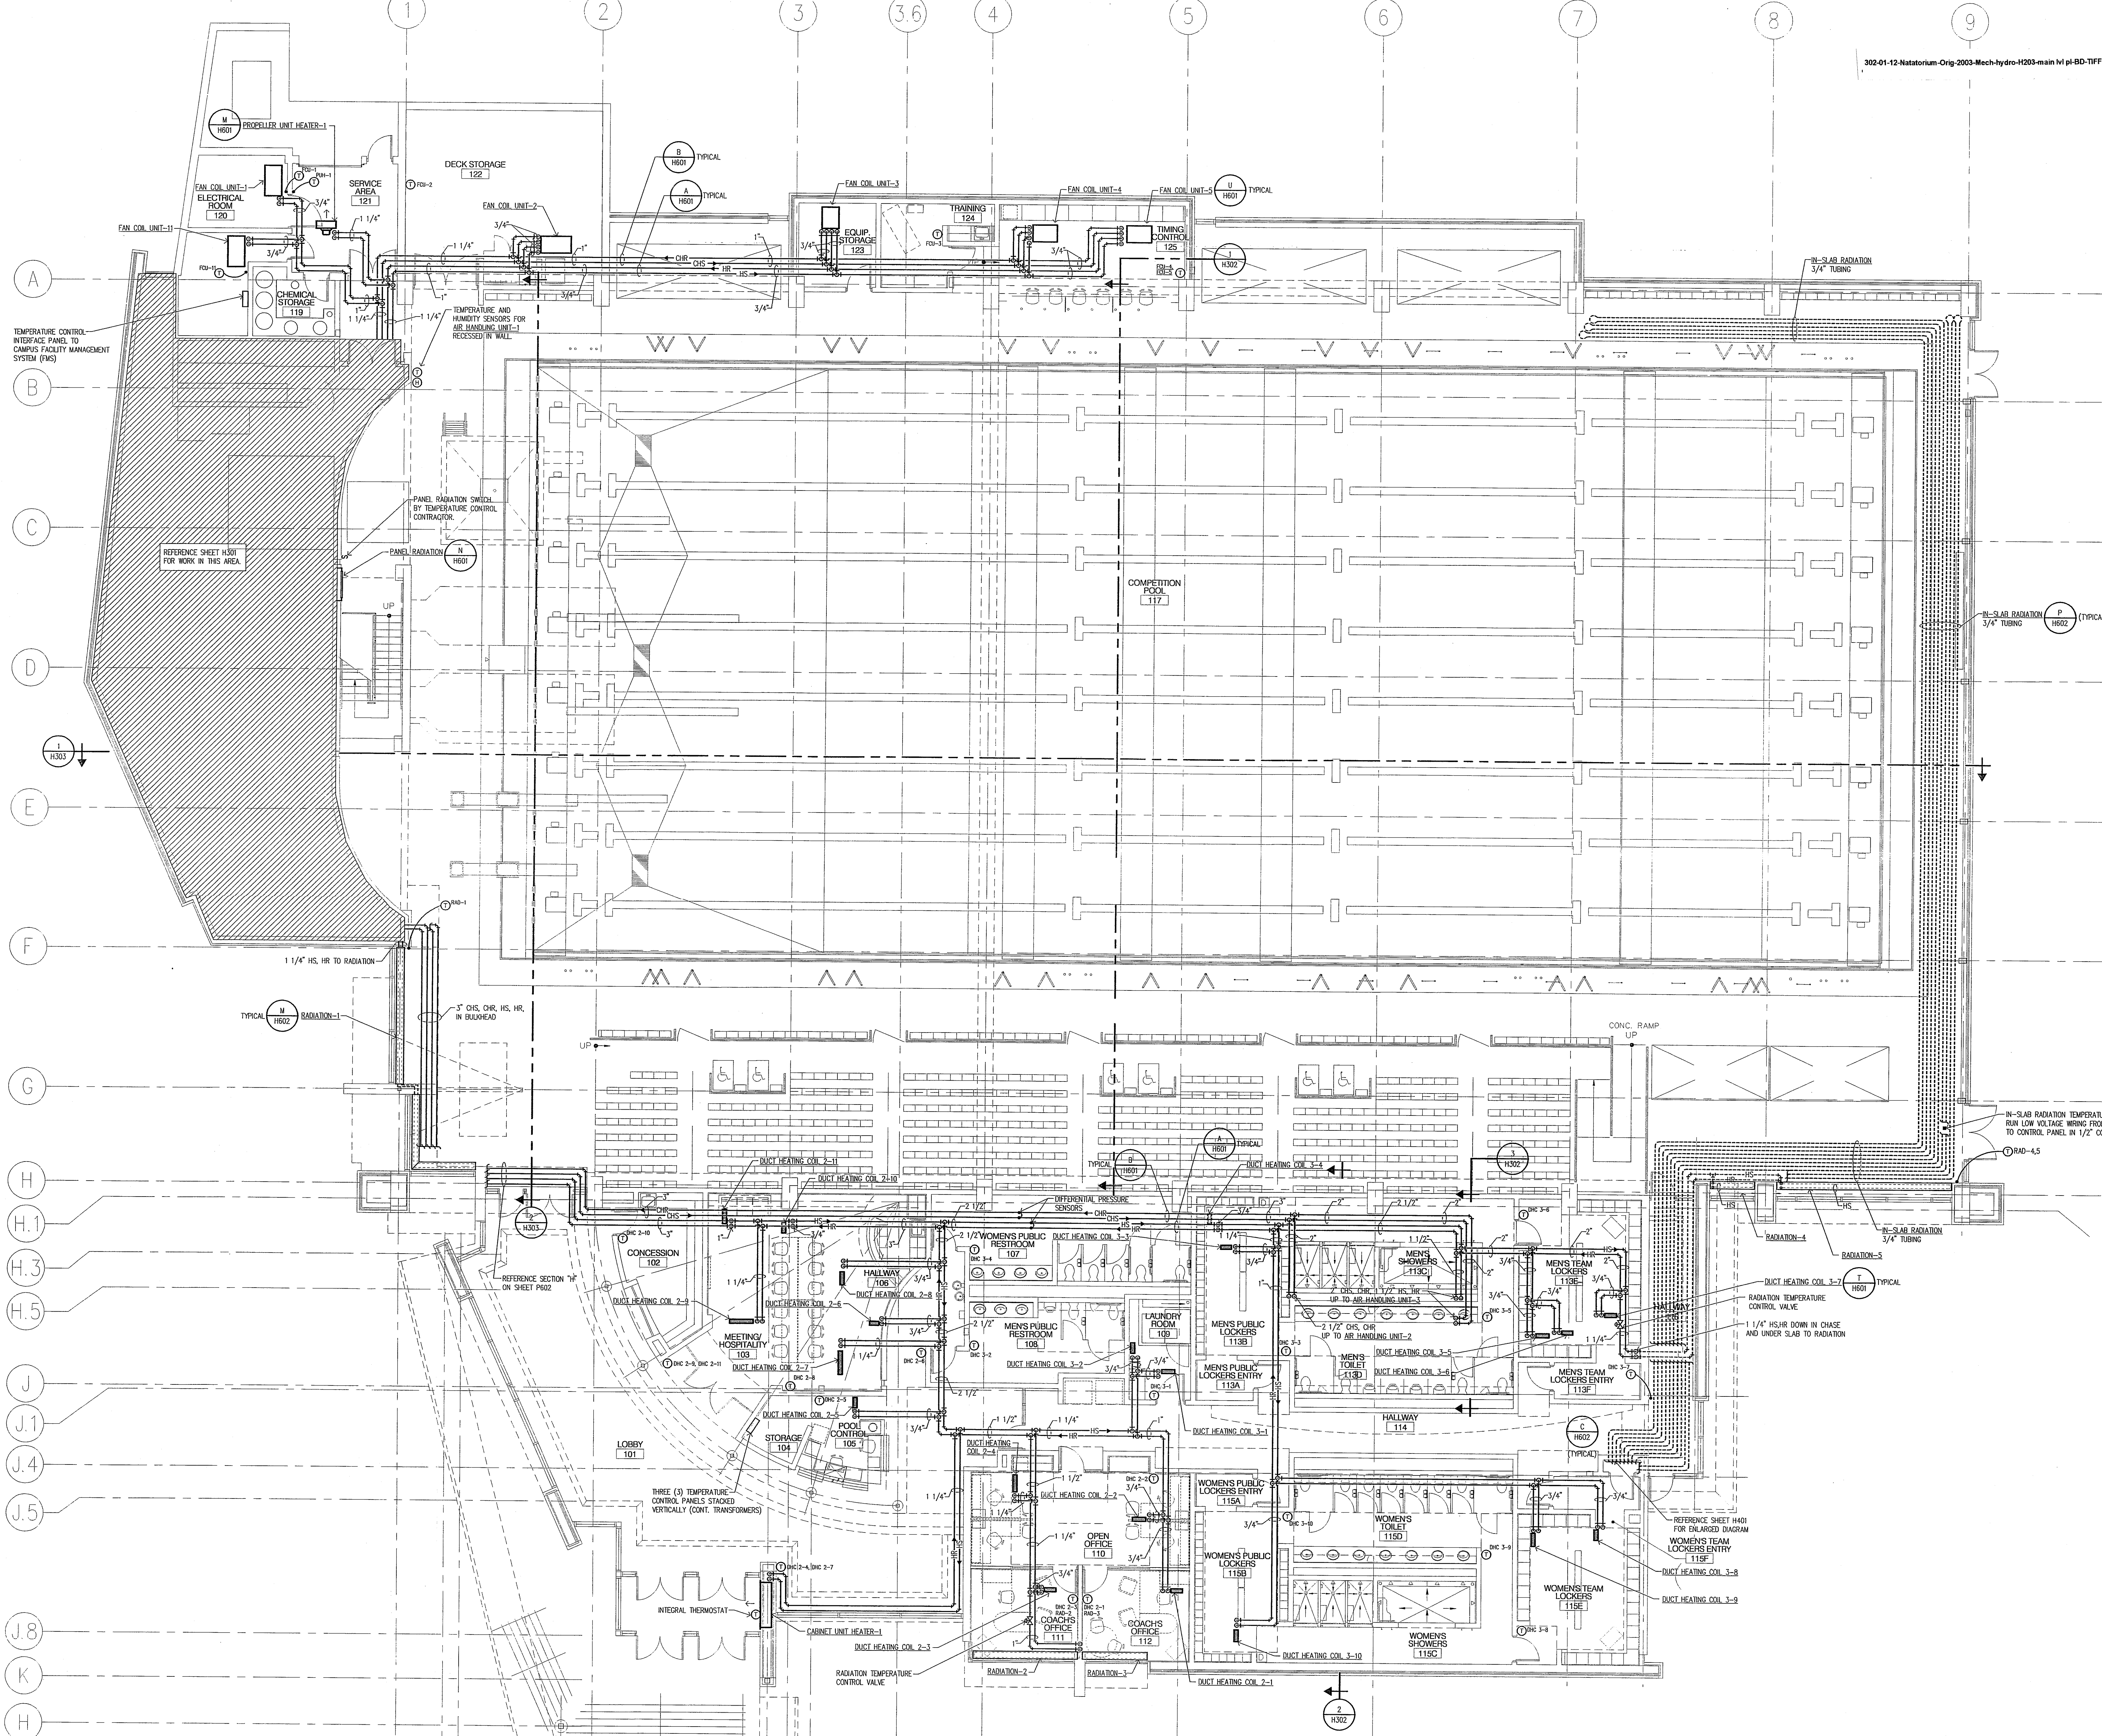

MAIN LEVEL FLOOR PLAN - HVAC PIPING

SCALE: 1/8" = 1'-0"

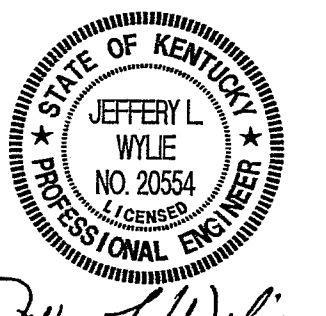

CERTIFICATION
CONSTRUCTION DOCUMENTS

**CARDINAL PARK
NATATORIUM**

UNIVERSITY OF LOUISVILLE

Project: 0306
Drawn: ROBERT E. SMITH
Checked: KERRY L. SMITH
Scale: 1/8" = 1'-0"
Issue Date: AUGUST 28, 2003
Revision:

**MAIN LEVEL FLOOR
PLAN - HVAC PIPING**

H203