

**MICHAEL L. KNOLL**  
ARCHITECT  
316 South Main Street  
Versailles, Kentucky 40383  
Phone: 859-879-1900  
Email: 3mknoll@att.net

**HERRICK & ASSOCIATES**  
Consulting Engineers  
LEXINGTON, KY  
859-271-0483  
DESIGN-ENGINEERING  
501 BROOKFARM CIRCLE  
LEXINGTON, KY 40517  
D. DAVID PRESTON, P.E.



**The McGowan Company**  
Commercial Real Estate

PROJECT: MCGOWAN DEVELOPMENT  
LEXINGTON, KY  
200 BOLLIVAR STREET  
LEXINGTON, KENTUCKY  
DRAWING: ROOF PLAN FOR VTR'S & DRAINS

DATE: 1/10/03  
DRAWN BY: MLK  
REVISIONS:

SHEET NO.  
**P-10**

Job # 8101 Document # 34238  
234 C-1

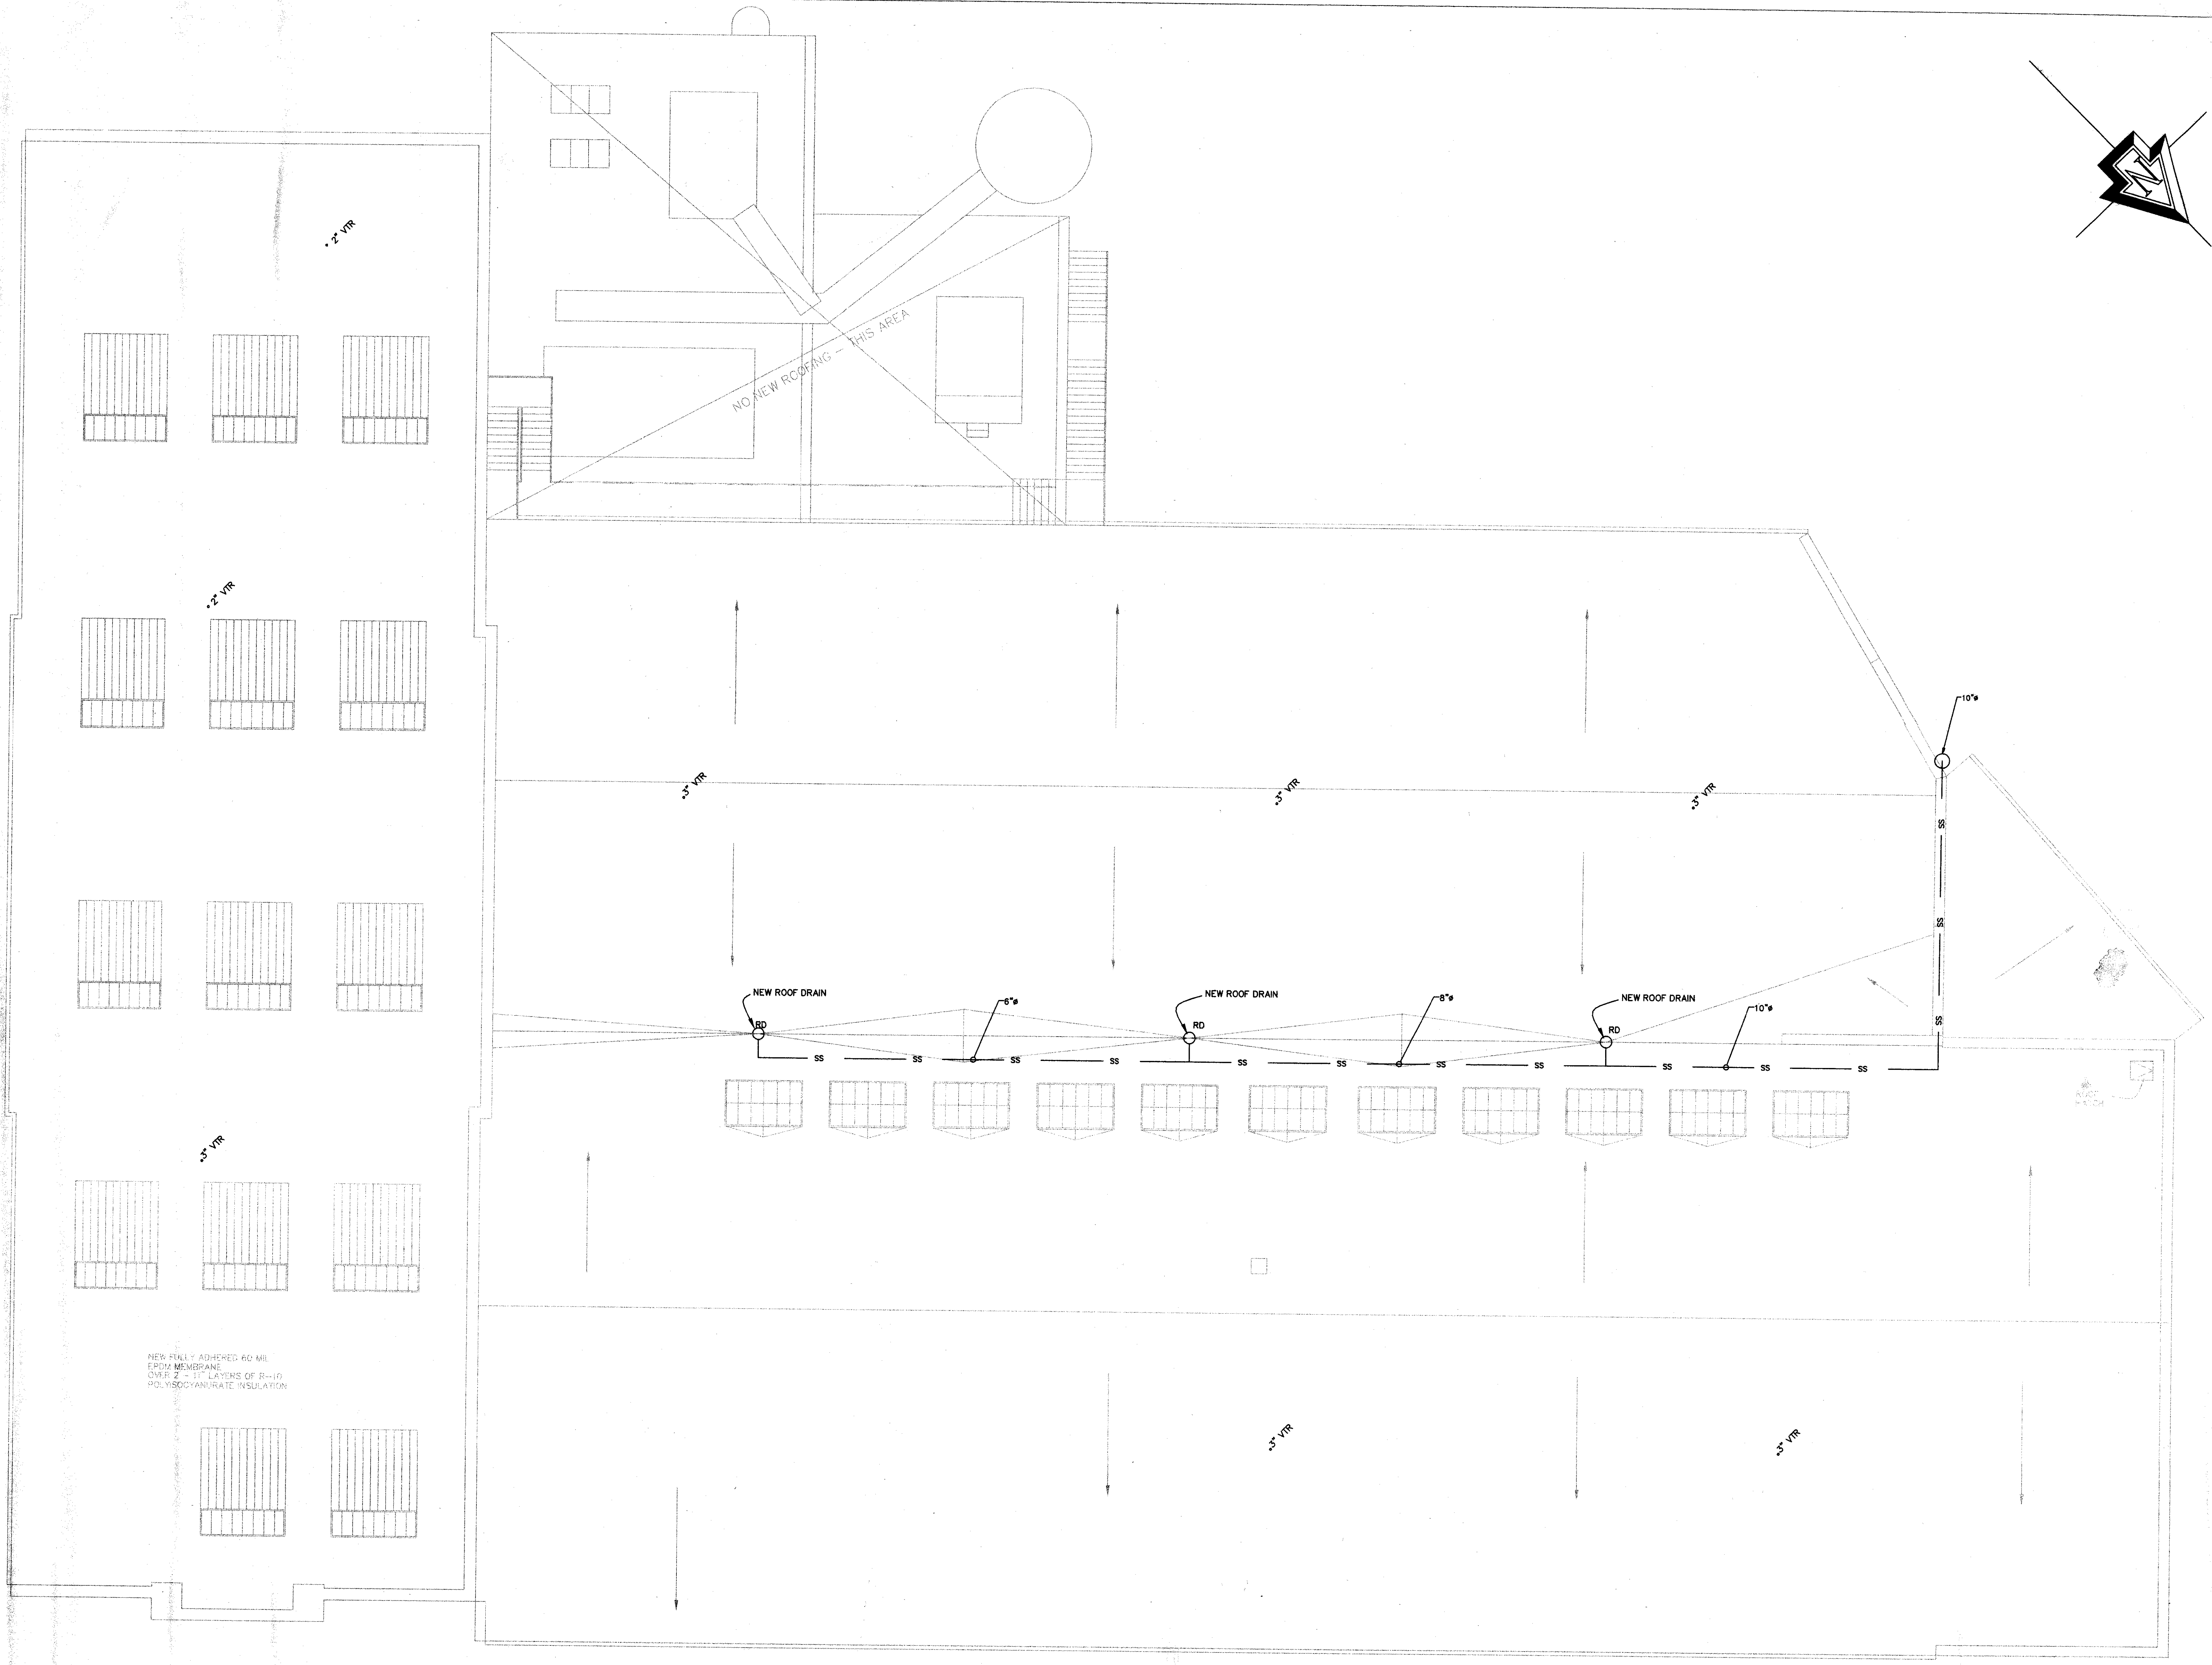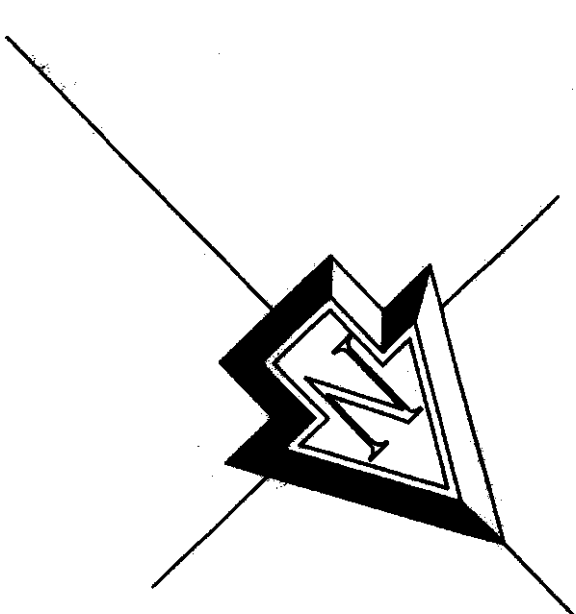

AS-BUILT DRAWING

1/8" = 1' M

HVAC SECOND FLOOR