


1 2ND LEVEL REFLECTED CEILING PLAN- LOW
A-6.2b 1/8" = 1'-0"

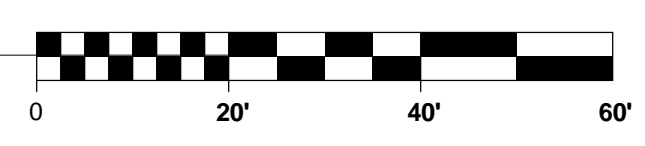

REFLECTED CEILING PLAN LEGEND

- NOTES**
REFER TO M.E.P. DRAWINGS FOR EXACT QTY. AND LOCATION OF MECH., ELEC., AND FIRE-PROTECTION WORK. PROVIDE SLOTTED CHANNEL FRAMING SUPPORTS FOR CEILING MOUNTED ITEMS. TYPICAL. FULL HEIGHT DRYWALL (NON-RATED) SMOKE TIGHT. ONE HOUR RATING. NEW GYPSUM BOARD CEILING / SOFFIT. EXISTING GYPSUM BOARD CEILING / SOFFIT. 2x2 ACOUSTIC PANEL CEILING. ROLLER SHADE. PENDANT MOUNT FLUORESCENT LIGHT FIXTURE. 2x2 RECESSED FLUORESCENT LIGHT FIXTURE. 2x4 RECESSED FLUORESCENT LIGHT FIXTURE. RECESSED DOWNLIGHT. LINEAR FLUORESCENT LIGHT FIXTURE (IN GRID & PENDANT MOUNT). 1x4 SURFACE MOUNTED FLUORESCENT LIGHT FIXTURE. 4" SURFACE MOUNTED STRIP LIGHT FIXTURE. COVE LIGHT. PENDANT WALL WASH.

- HIGH VOLUME FAN
WALL MOUNTED LIGHT FIXTURE
WALL MOUNTED EXIT LIGHT FIXTURE
CEILING MOUNTED EXIT LIGHT FIXTURE
2x2 RETURN AIR GRILL
1x1 RETURN AIR GRILL
2x2 SUPPLY DIFFUSER
1x1 SUPPLY DIFFUSER
ACOUSTICAL CEILING MOUNTED POWER DROP. SEE ELECTRICAL DWGS.
TRACK LIGHT
WALL WASHER

- GENERAL NOTES**
1. SEE A-10 FOR ACCESSORY SCHEDULE.
2. CLEAN, REPAIR, PREPARE, AND PAINT ALL GYPSUM BOARD SOFFIT AND CEILING SURFACES.
3. CEILING AND SOFFIT SURFACES MAY BE PAINTED A DIFFERENT COLOR THAN ADJACENT WALL COLOR.
4. VERIFY EXISTING SUBSTRATES ARE DRY AND FREE FROM LEAKS BEFORE REPAIRING GYPSUM BOARD SURFACES OR INSTALLING NEW CEILING FINISHES. NOTIFY ARCHITECT IF LEAKS, OR WET SURFACES ARE DISCOVERED.
5. ALL WALLS ARE FULL HEIGHT EXCEPT AS NOTED OTHERWISE.
6. SEE MECHANICAL, ELECTRICAL AND PLUMBING SHEETS FOR ALL MEP ITEMS. ALL MEP ITEMS SHOWN ON THE REFLECTED CEILING PLANS ARE FOR REFERENCE ONLY AND SHOULD NOT BE USED FOR CONSTRUCTION.

NOT FOR CONSTRUCTION Job Number: 1205 Date: 05/2013
Revision: Drawn By: Author Checked By: Checker
212 North Upper Street
Lexington, Kentucky 40507-1001
p.502/252-2340
www.omniarchitects.com
Omni ARCHITECTS
PHASE 3 - CONSTRUCTION DOCUMENTS
50% REVIEW SUBMITTAL
A-6.2b