
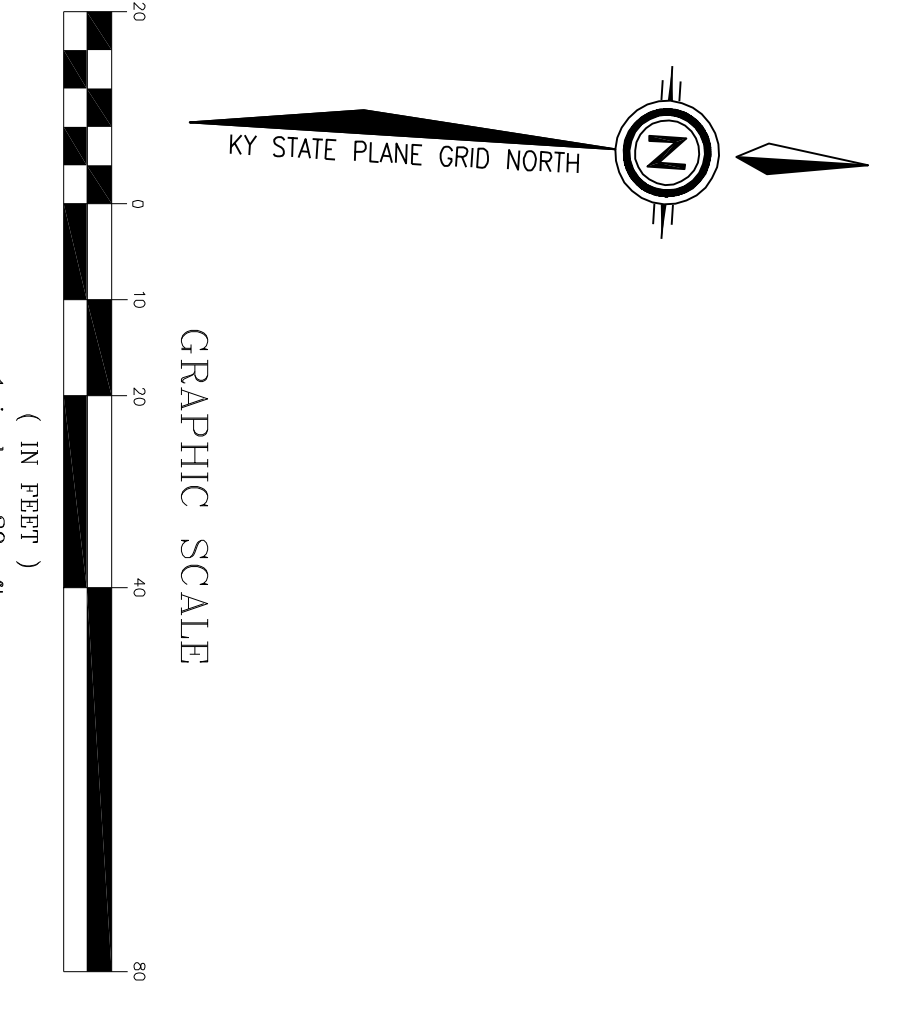


- UTILITY OWNERS**
- TELEPHONE**
- KENTUCKY JUNITES
500 STONE ROAD
LEXINGTON, KY
BRENN SPICER TEL
(859) 278-8333
 - WASTE WATER
AMERICAN WATER
COMPANY
2200 RICHMOND ROAD
LEXINGTON, KY
(859) 288-6362
 - CABLE TELEVISION
TRANSPORATION CABINET
2544 PALMWOOD DRIVE
LEXINGTON, KY
(859) 514-1400
 - STATE ROADS
DEPARTMENT OF HIGHWAYS
763 NEW CIRCLE ROAD NW
LEXINGTON, KENTUCKY
(859) 258-3410
 - NATURAL GAS
COLUMBIA GAS COMPANY
2001 WERCER ROAD
BROWN STONE
LEXINGTON, KY
(859) 288-0253
- TELEPHONE**
- 130 WEST NEW CIRCLE ROAD
LEXINGTON, KY
1-859-957-6290
 - 2544 PALMWOOD DRIVE
LEXINGTON, KY
(859) 514-1400

- LEGEND**
- PC PAVEMENT
 - PP CONCRETE PAVEMENT
 - CP WINDING CLAY PIPE
 - M1 MANHOLE
 - FL. SURFACE ELEVATION (TOP-OF-CURB)
 - FL. SURFACE ELEVATION (TOP-OF-SUB)
 - CHIMNEY TRAIL
 - WATER LINE
 - SEWER LINE
 - UNDERGROUND TELEPHONE/CABLE
 - UNDERGROUND ELECTRICAL
 - ODDIOUS TREE (LAYER TREE)
 - COMFUSION TREE (EVERGREEN)
 - INDICATES OPEN OR OUTLET
 - INDICATES TANK
 - BRACKETED DIMENSIONS ARE PER RECORD SURVEY
 - PER RECORD SURVEY - NOT CONSIDERED HIS SURVEY

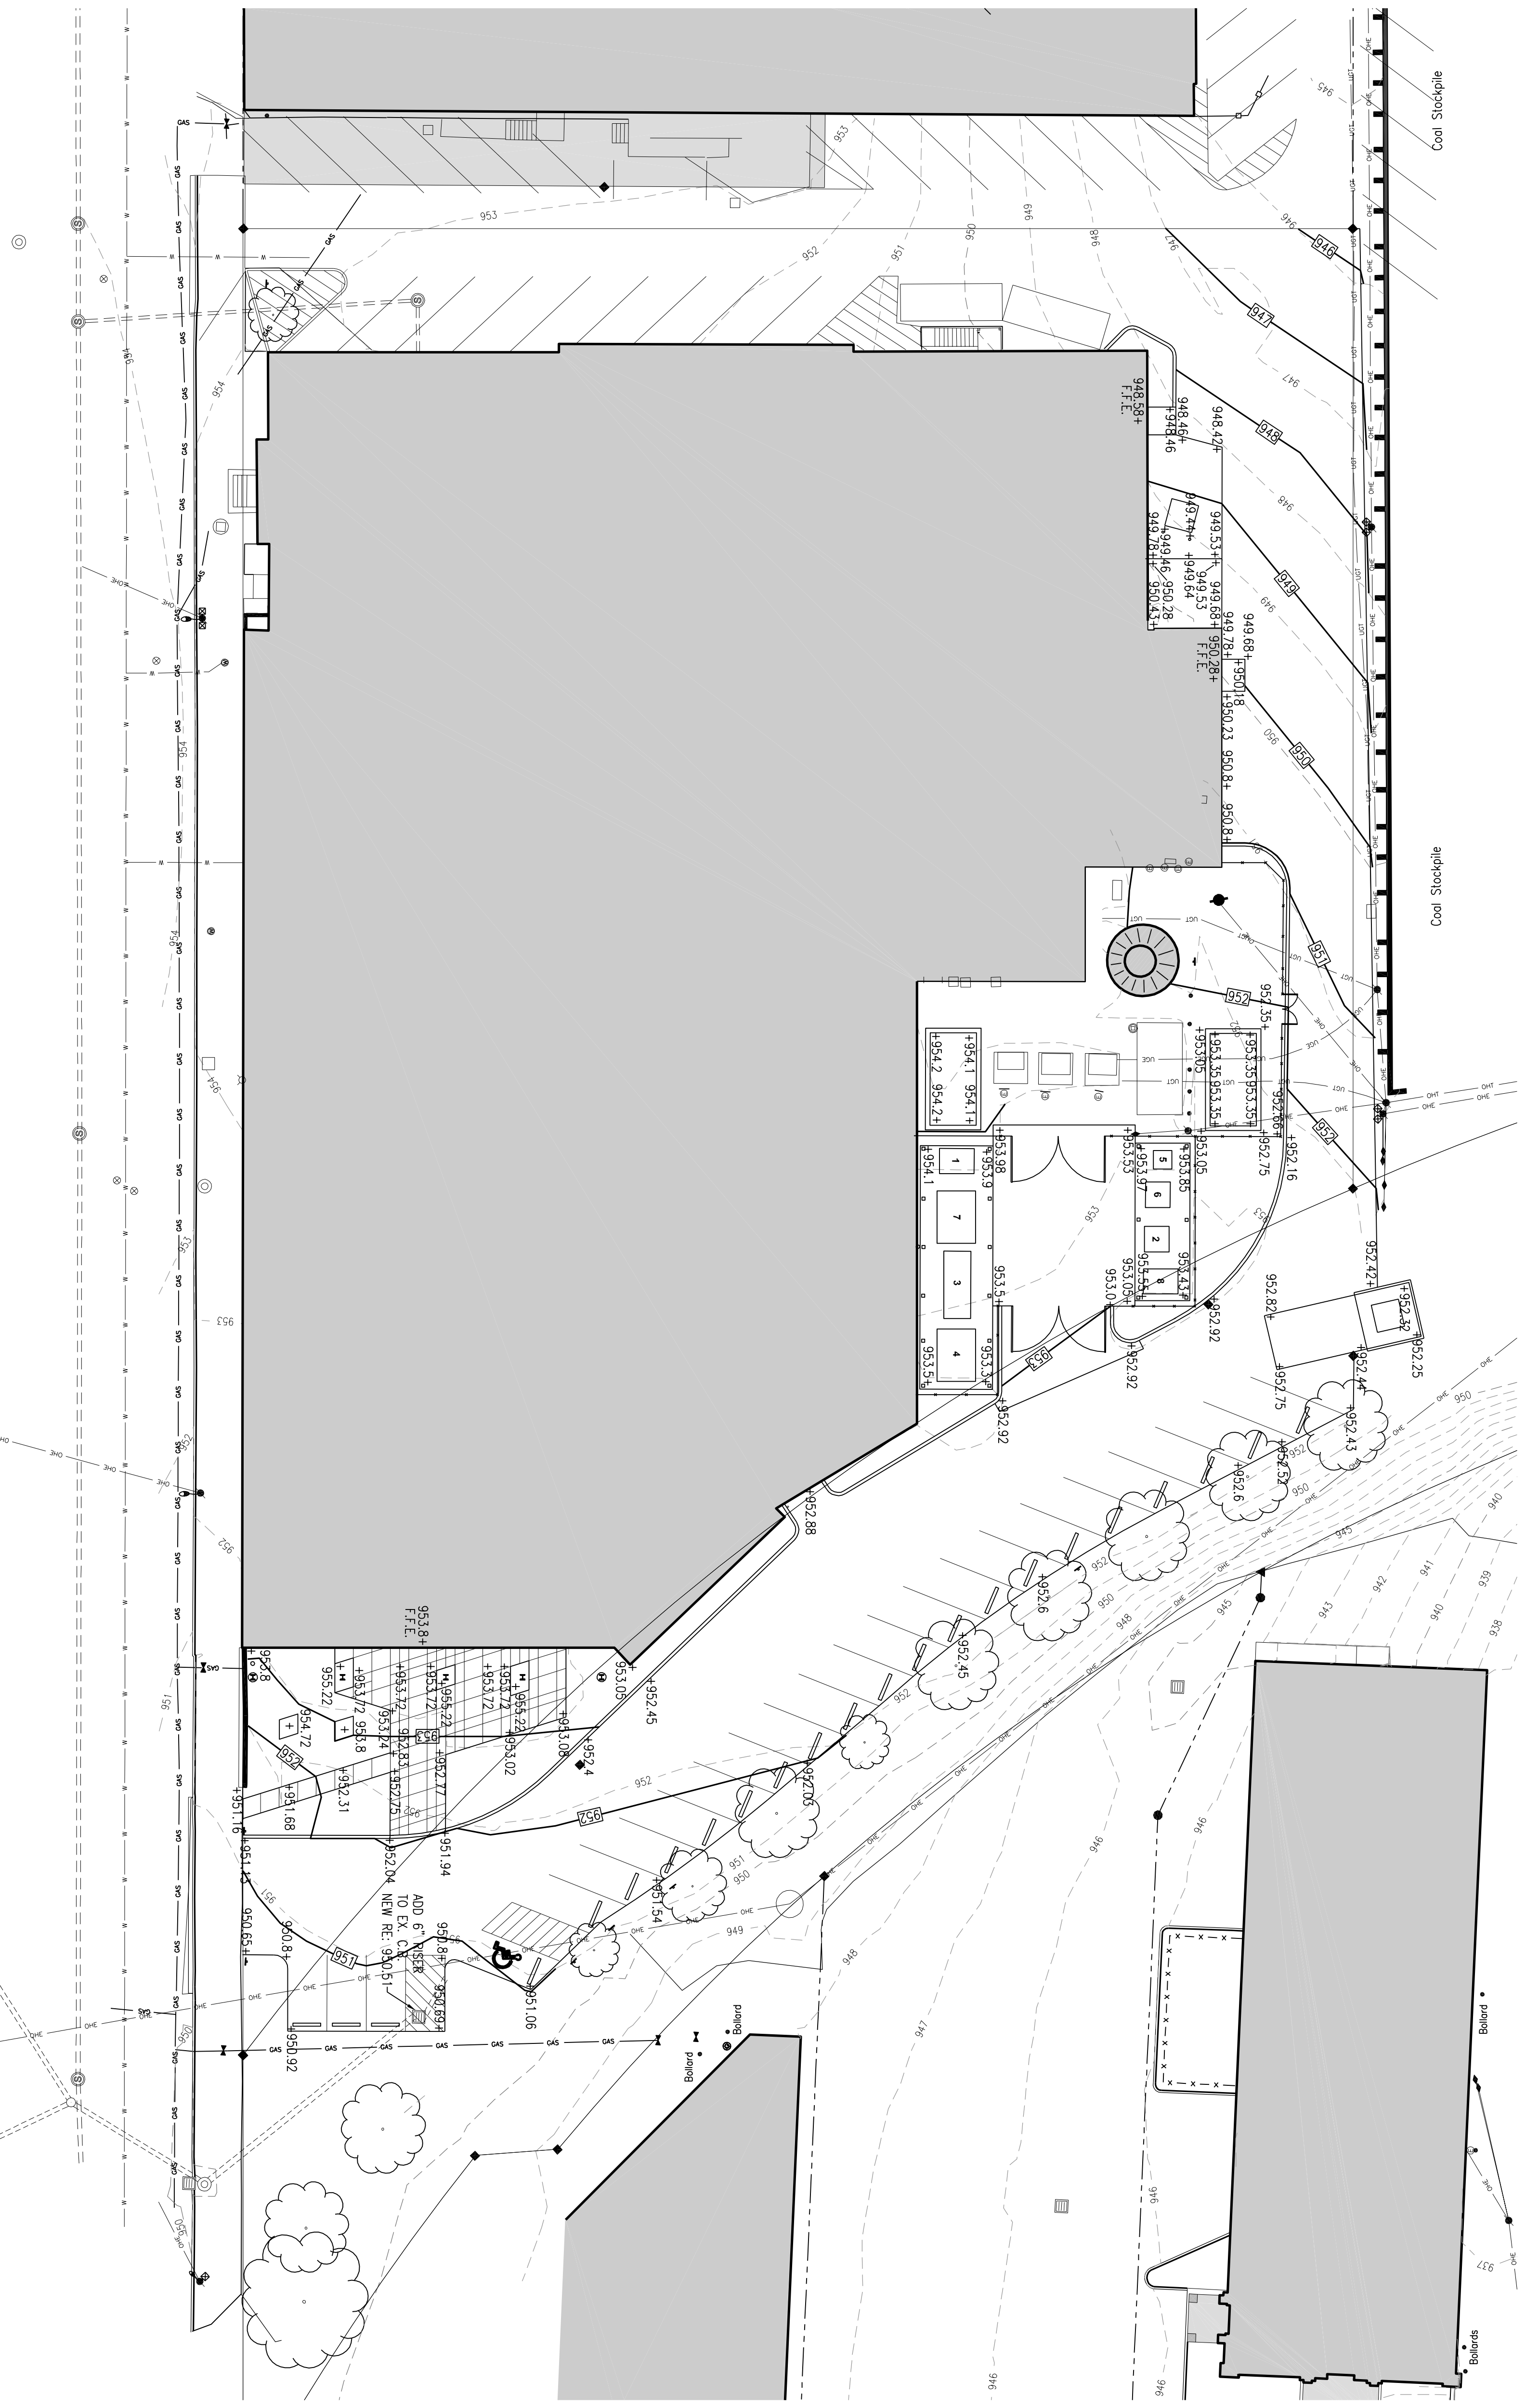

UNIVERSITY LOFTS - Renovate Academic Facility UK School of Art & Visual Studies

Grading & Drainage Plan NOT FOR CONSTRUCTION Job Number: 1205 Date: 05/03/2013 Drawn By: KLV Checked By: KLV Revision:

C400
50% CONSTRUCTION DOCUMENTS



212 North Upper Street
Lexington, Kentucky 40507-1001
p 859.252.8664 f 859.253.2358
www.omniarchitects.com



This Drawing and the Design shown hereon are the property of Omni Architects. The reproduction, copying or other use of this Drawing or Design without the written consent of Omni Architects is prohibited.

