

- GENERAL DEMOLITION NOTES
- HEAVY DASHED LINES INDICATE ITEMS FOR REMOVAL (U.O.N.) AND LIGHT SOLID LINES INDICATE EXISTING ITEMS TO REMAIN.
 - THE CONTRACTOR SHALL MAINTAIN THE CONTINUITY OF EXISTING CIRCUITS THAT CONTAIN DEVICES OR EQUIPMENT THAT ARE TO REMAIN. WHEN DEMOLITION OF AN ELECTRICAL DEVICE (OR CIRCUIT) IS INDICATED ON THE DRAWINGS, THE CONTRACTOR SHALL INSURE THAT OTHER DEVICES OR EQUIPMENT "UPSTREAM" OR "DOWNSTREAM" ON THE CIRCUITS SHALL REMAIN IN "PRE-DEMOLITION" WORKING ORDER. "LEFT-OVER" CIRCUIT BREAKERS SHALL REMAIN AND BE LABELED AS SPARES IN THEIR PANELS. PROVIDE NEW TYPEWRITTEN DIRECTORIES FOR ALL PANELS AFFECTED.
 - LOCATIONS OF DEVICES, CONNECTIONS, ETC., INDICATED ON THIS DRAWING WERE TAKEN FROM VARIOUS SOURCES. THEY ARE DIAGRAMMATIC ONLY AND ARE SUBJECT TO VARIATION FROM EXISTING CONDITIONS. CERTAIN EXISTING ELEMENTS MAY NOT BE INDICATED AT ALL. THE CONTRACTOR PROPOSING TO DO ANY PART OF THE WORK INDICATED HERE-ON SHALL VISIT THIS SITE AND DETERMINE TO HIS SATISFACTION THAT THEY MAY COMPLETE ALL WORK REQUIRED FOR THE BID WHICH HE PROPOSES.
 - REMOVE ALL ASSOCIATED CONDUIT AND CONDUCTORS FOR DEVICES/FIXTURES/ETC. BEING REMOVED, WHETHER INDICATED OR NOT (U.O.N.).
 - COORDINATE DISPOSAL OF ALL FIXTURES, DEVICES, ETC. (INDICATED FOR DEMOLITION) WITH THE OWNER.
 - CONTRACTOR TO VERIFY THAT THERE ARE NO ELECTRICAL CIRCUITS IN CHASES BEING REMOVED UNDER DEMOLITION WHICH MUST REMAIN IN SERVICE AND CANNOT BE REMOVED. SHOULD SUCH CIRCUITS BE ENCOUNTERED, THE CONTRACTOR IS TO REROUTE AND RECONNECT AS REQUIRED TO MAINTAIN SERVICE.
 - THE CONTRACTOR SHALL REFER TO THE ARCHITECTURAL PLANS FOR AREAS IN WHICH THE CEILING IS REMAINING. THE CONTRACTOR IS RESPONSIBLE FOR REMOVING THE EXISTING CEILING AS REQUIRED, TEMPORARILY SUPPORT LIGHTS, DIFFUSERS, CEILING ETC. REPLACE BROKEN CEILING TILES WITH NEW. FIELD VERIFY EXACT REQUIREMENTS.
 - ALL OUTAGES SHALL BE SCHEDULED THROUGH THE UK CPMD PROJECT REPRESENTATIVE FOR PROPER COORDINATION. A REQUEST FOR AN OUTAGE SHALL BE SUBMITTED IN WRITING A MINIMUM OF TWO WEEKS IN ADVANCE.

- ELECTRICAL DEMO FIRST FLOOR PLAN TAGGED NOTES (X)
- EXISTING BOILER ROOM. REMOVE ALL EXISTING ELECTRICAL LIGHTS AND DEVICES FROM THIS SPACE. NOTE THAT MOST DEVICES HAVE BEEN PREVIOUSLY REMOVED.
 - EXISTING TRANSFER SWITCH TO BE REMOVED.
 - EXISTING PANEL TO BE REMOVED.
 - EXISTING PANEL TO BE REMOVED. PANEL TO BE SAVED AND REUSED.
 - EXISTING FREE STANDING SWITCH GEAR TO REMAIN.
 - FIRE ALARM CONTROL PANEL TO BE REMOVED.
 - EXISTING ELEVATOR TO REMAIN. MAINTAIN POWER, CONTROL, AND SYSTEMS (I.E. NEW FIRE ALARM AND VOICE) FUNCTIONALITY.

1 ELECTRICAL DEMO FIRST FLOOR PLAN
1/8" = 1'-0"

UNIVERSITY LOFTS - Renovate Academic Facility UK School of Art & Visual Studies

ELECTRICAL DEMO FIRST FLOOR PLAN

NOT FOR CONSTRUCTION Job Number: 1205

Date: 03/2013

Drawn By: Author

Checked By: Checker


Revision:



212 North Upper Street
Lexington, Kentucky 40507-1001
p.603.252.2288 f.603.252.2288
www.omniarchitects.com

PRE-DESIGN

E2.1

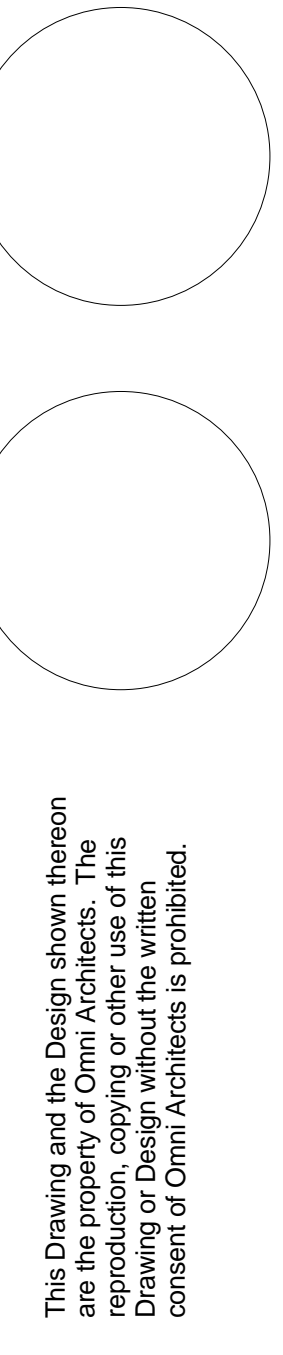

This Drawing and the Design shown thereon are the property of Omni Architects. The reproduction, copying or other use of this drawing without the written consent of Omni Architects is prohibited.