

1 LIGHTING DESIGN FIRST FLOOR PLAN TAGGED NOTES  
 PROVIDE PROTECTIVE SWITCH FOR WHITE LIGHT SOURCE.

1 LIGHTING DESIGN-FIRST FLOOR PLAN  
 1/8" = 1'-0"

# UNIVERSITY LOFTS - Renovate Academic Facility UK School of Art & Visual Studies

LIGHTING DESIGN FIRST FLOOR PLAN

NOT FOR CONSTRUCTION Job Number: 1205 Date: 03/2013

Drawn By: Author Checked By: Checker


Revision:

212 North Upper Street  
 Lexington, Kentucky 40507-1001  
 p.603.252.2282  
 www.omniarchitects.com



PRE-DESIGN

**E3.1**

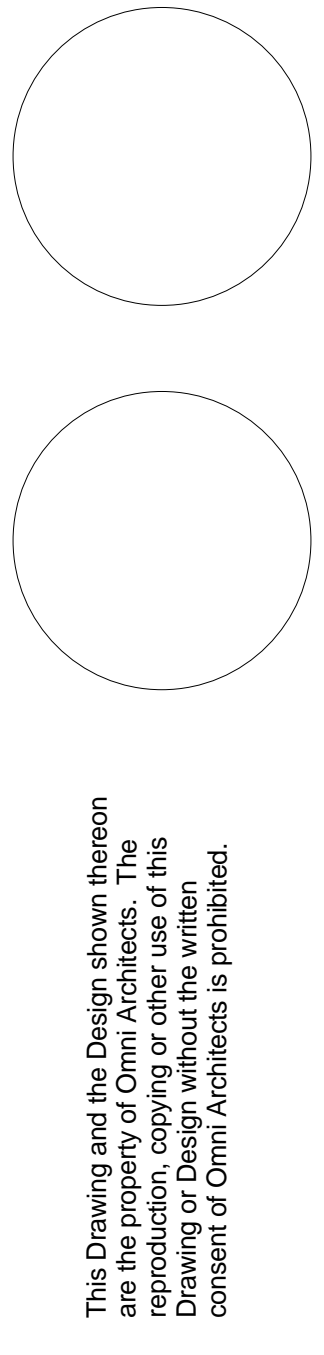

This Drawing and the Design shown thereon are the property of Omni Architects. The reproduction, copying or other use of this drawing without the written consent of Omni Architects is prohibited.