


**AV SYSTEM ABOVE CEILING WIRING DIAGRAM**  
 NOT TO SCALE

- NOTES:**
- A. REFER TO FLOOR PLAN FOR DEVICES TO BE INSTALLED IN EACH ROOM.
  - B. COORDINATE EXACT LOCATION OF ALL DEVICE ROUGH-INS WITH ARCHITECT PRIOR TO INSTALLATION.

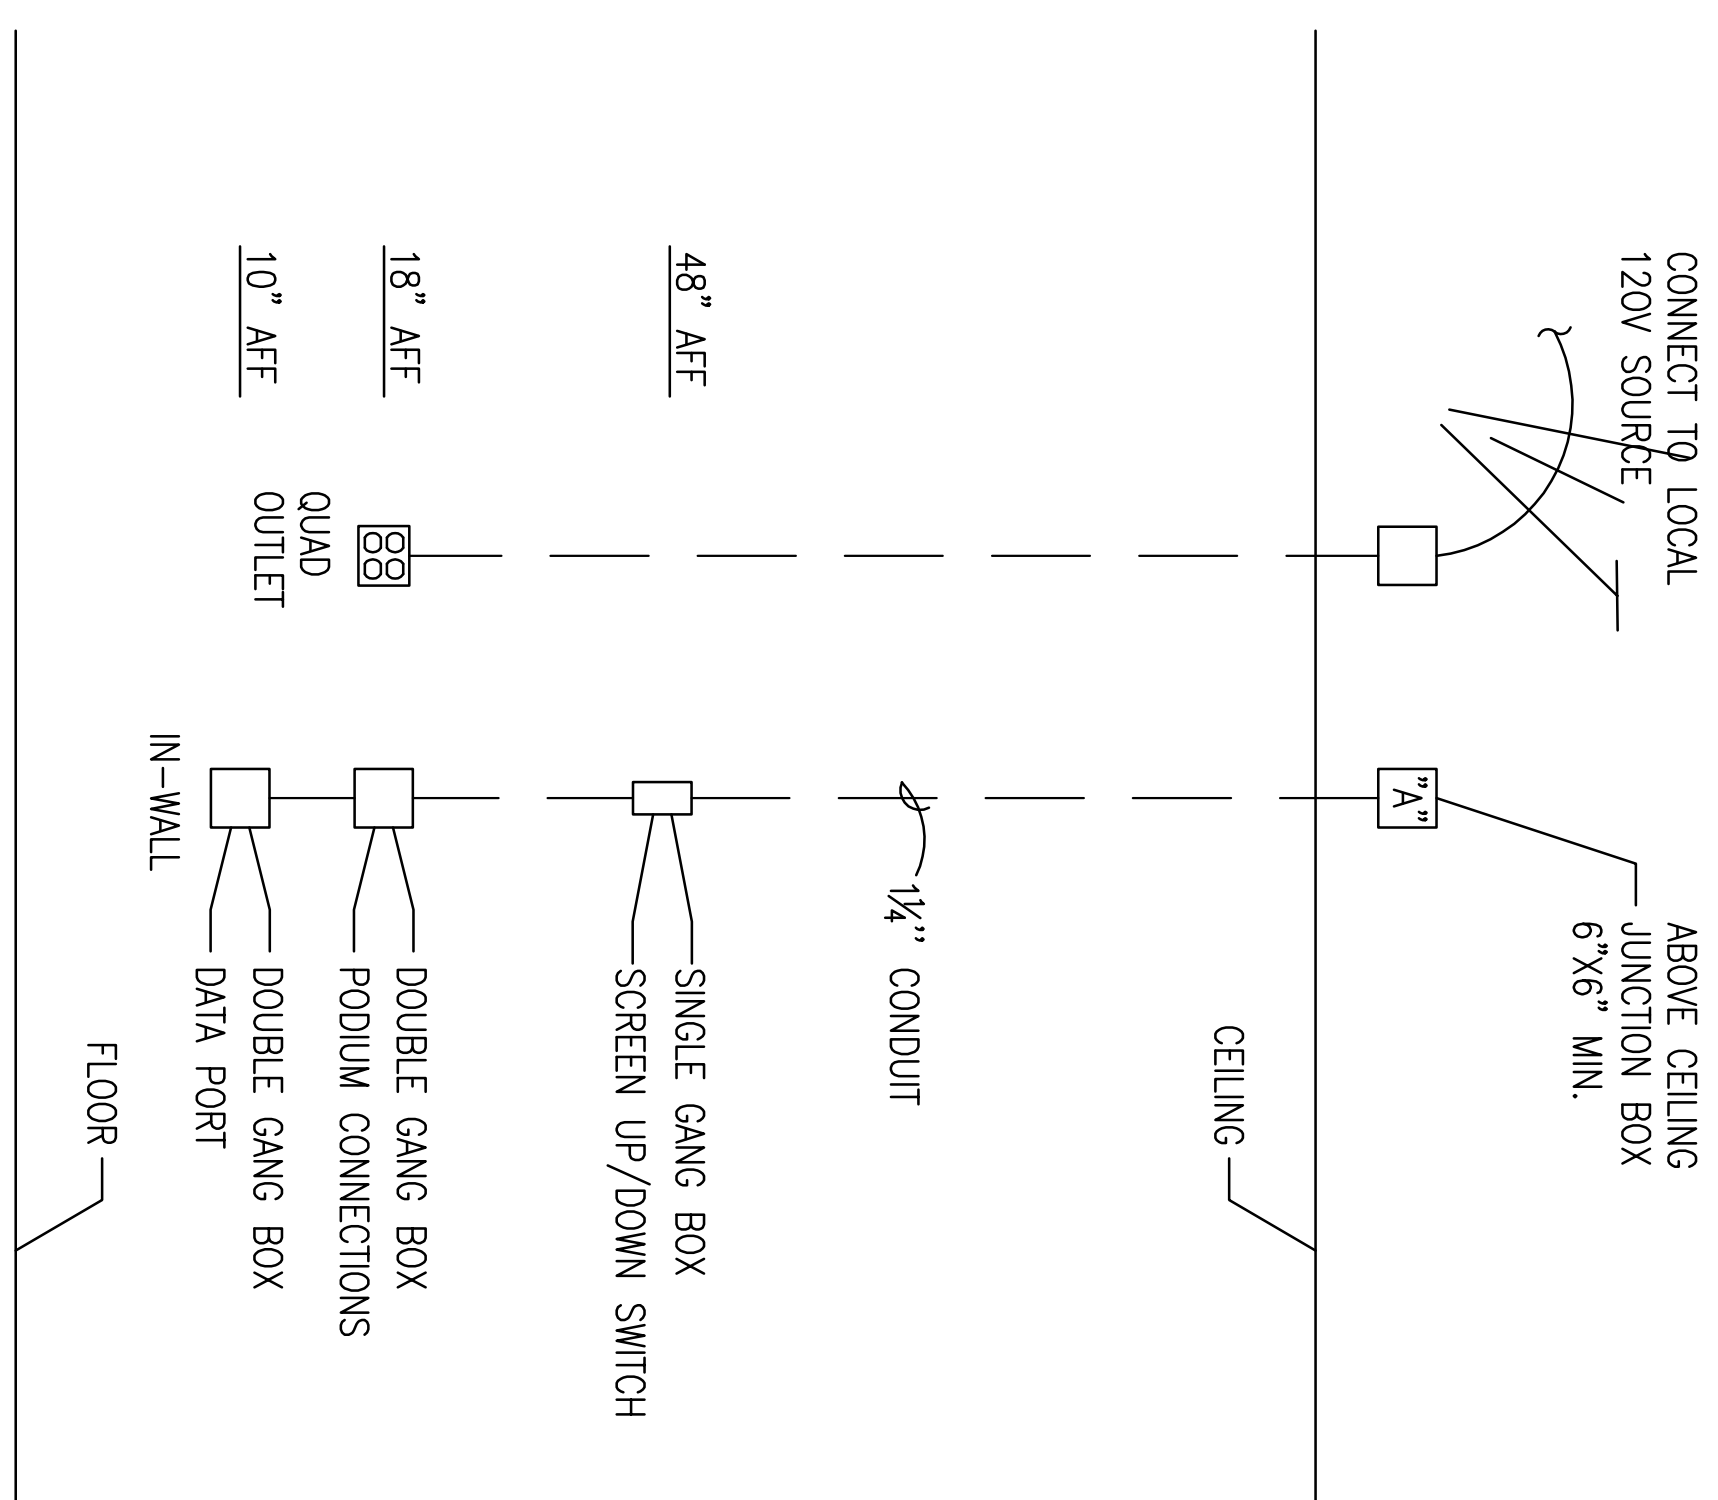

**AV RISER DIAGRAM**  
 NOT TO SCALE

# UNIVERSITY LOFTS - Renovate Academic Facility UK School of Art & Visual Studies

ELECTRICAL DETAILS

NOT FOR CONSTRUCTION Job Number: 1205 Date: 03/2013 Drawn By: CE/CRK Checked By: JMS Revision: XXX

**E6.1**

PRE-DESIGN



212 North Upper Street  
 Lexington, Kentucky 40507-1001  
 p 859.252.6964 f 859.253.2358  
 www.omniarchitects.com

This Drawing and the Design shown thereon are the property of Omni Architects. The reproduction, copying or other use of this Drawing or Design without the written consent of Omni Architects is prohibited.

