

UNIVERSITY LOFTS - Renovate Academic Facility UK School of Art & Visual Studies

FIRE PROTECTION DEMO THIRD FLOOR PLAN

NOT FOR CONSTRUCTION Job Number: 1205

Date: 03/2013

Drawn By: Author

Checked By: Checker


Revision:



212 North Upper Street
Lexington, Kentucky 40507-1001
p.603.252.2282
f.603.252.2288
www.omniarchitects.com

This Drawing and the Design shown thereon are the property of Omni Architects. The reproduction, copying or other use of this drawing without the written consent of Omni Architects is prohibited.

FIRE PROTECTION DEMO THIRD FLOOR PLAN
1/8" = 1'-0"

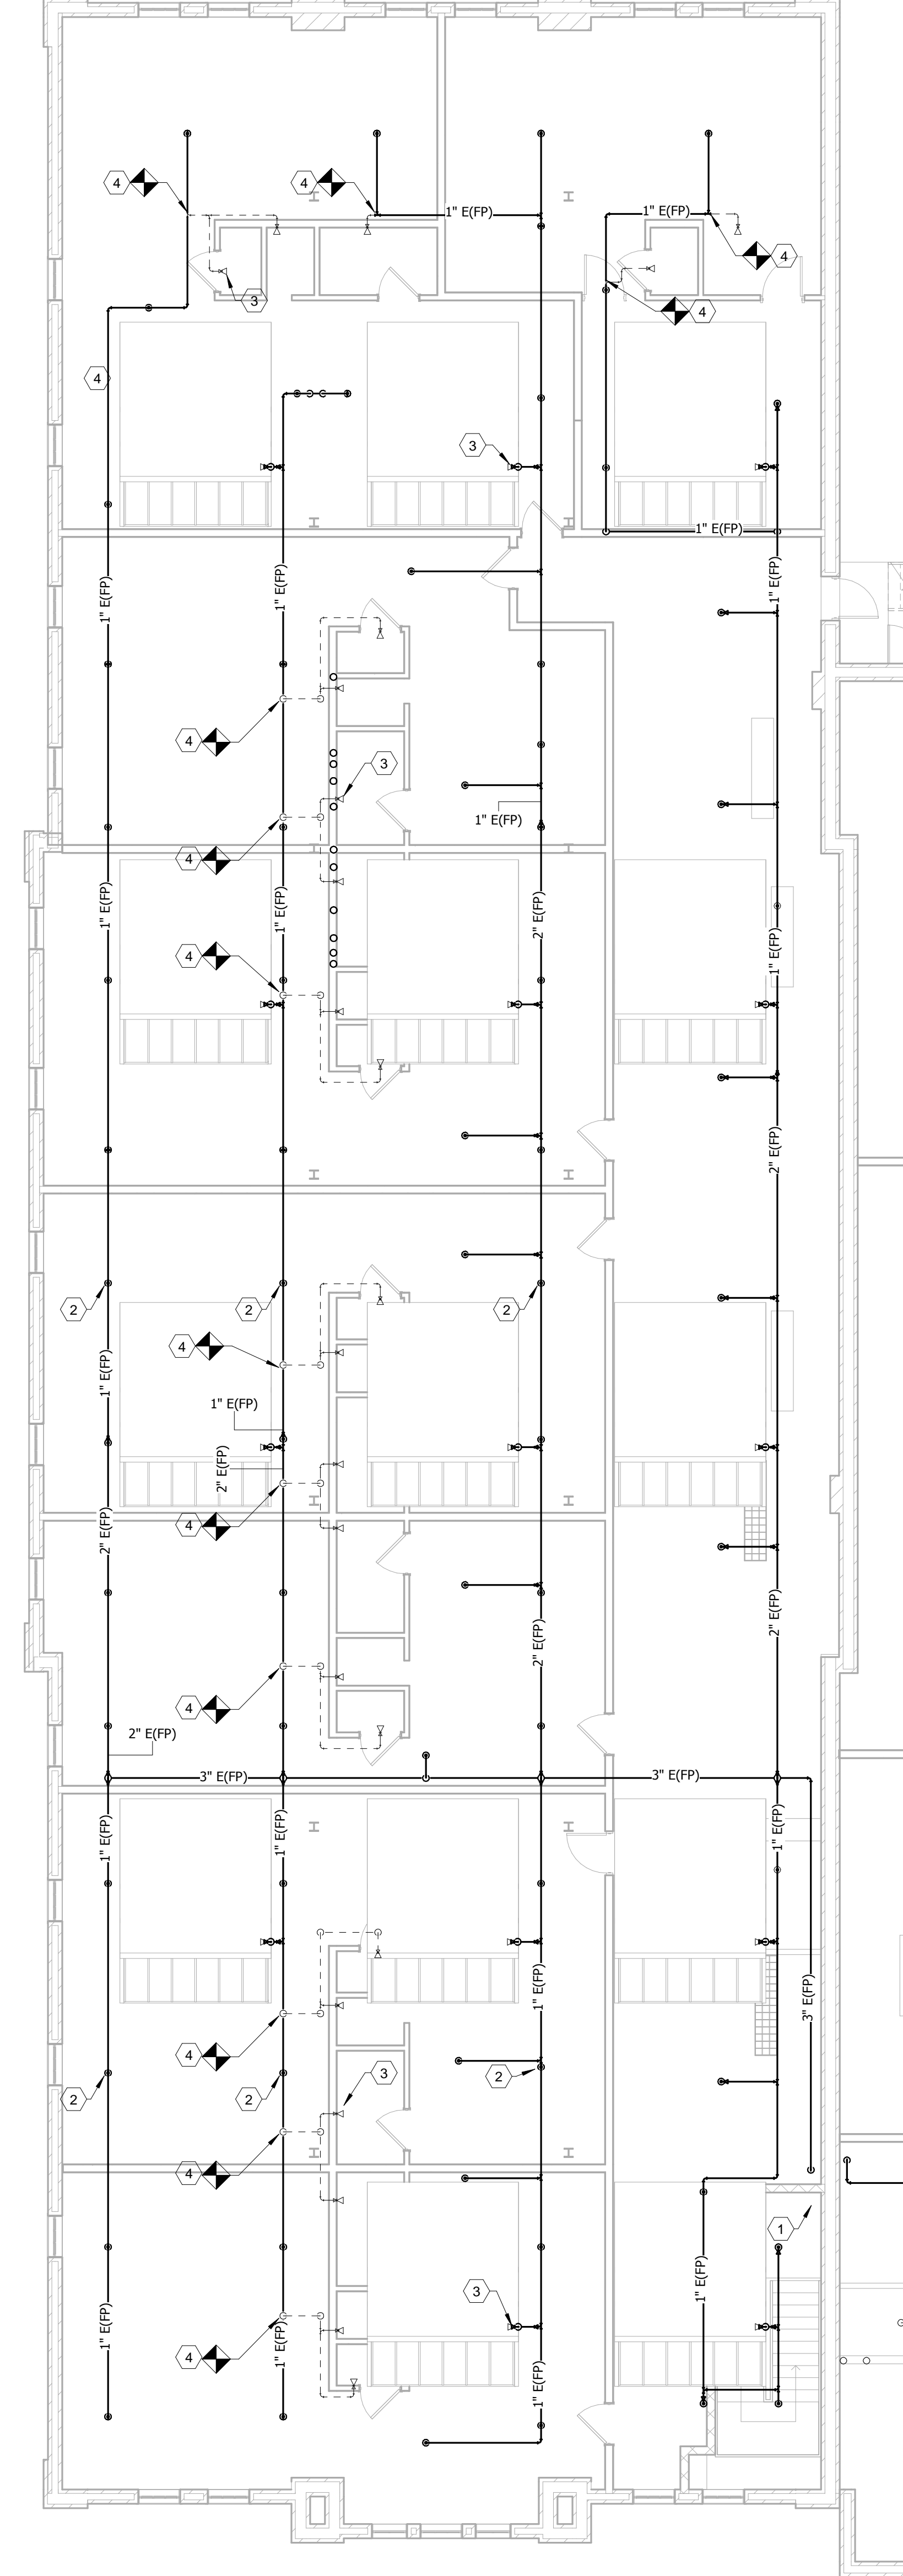

- FIRE PROTECTION DEMO THIRD FLOOR PLAN TAGGED NOTES (X)
- 3" EXISTING FIRE PROTECTION PIPING DOWN TO FIRST FLOOR. REFER TO SHEET FP1.2 FOR CONTINUATION.
 - EXISTING CEILING MOUNTED SPRINKLER HEAD, TYPICAL.
 - EXISTING SIDEWALL MOUNTED SPRINKLER HEAD, TYPICAL.
 - PATCH AND REPAIR FIRE PROTECTION PIPING AS REQUIRED.

FP1.3

PRE-DESIGN