

UNIVERSITY LOFTS - Renovate Academic Facility UK School of Art & Visual Studies

FIRE PROTECTION DESIGN THIRD FLOOR PLAN

NOT FOR CONSTRUCTION Job Number: 1205

Date: 03/2013

Drawn By: Author

Checked By: Checker

Revision:




212 North Upper Street
 Lexington, Kentucky 40507-1001
 p.606.252.2222 f.606.252.2258
 www.omniarchitects.com

This Drawing and the Design shown thereon are the property of Omni Architects. The reproduction, copying or other use of this drawing without the written consent of Omni Architects is prohibited.

PRE-DESIGN

FP2.3

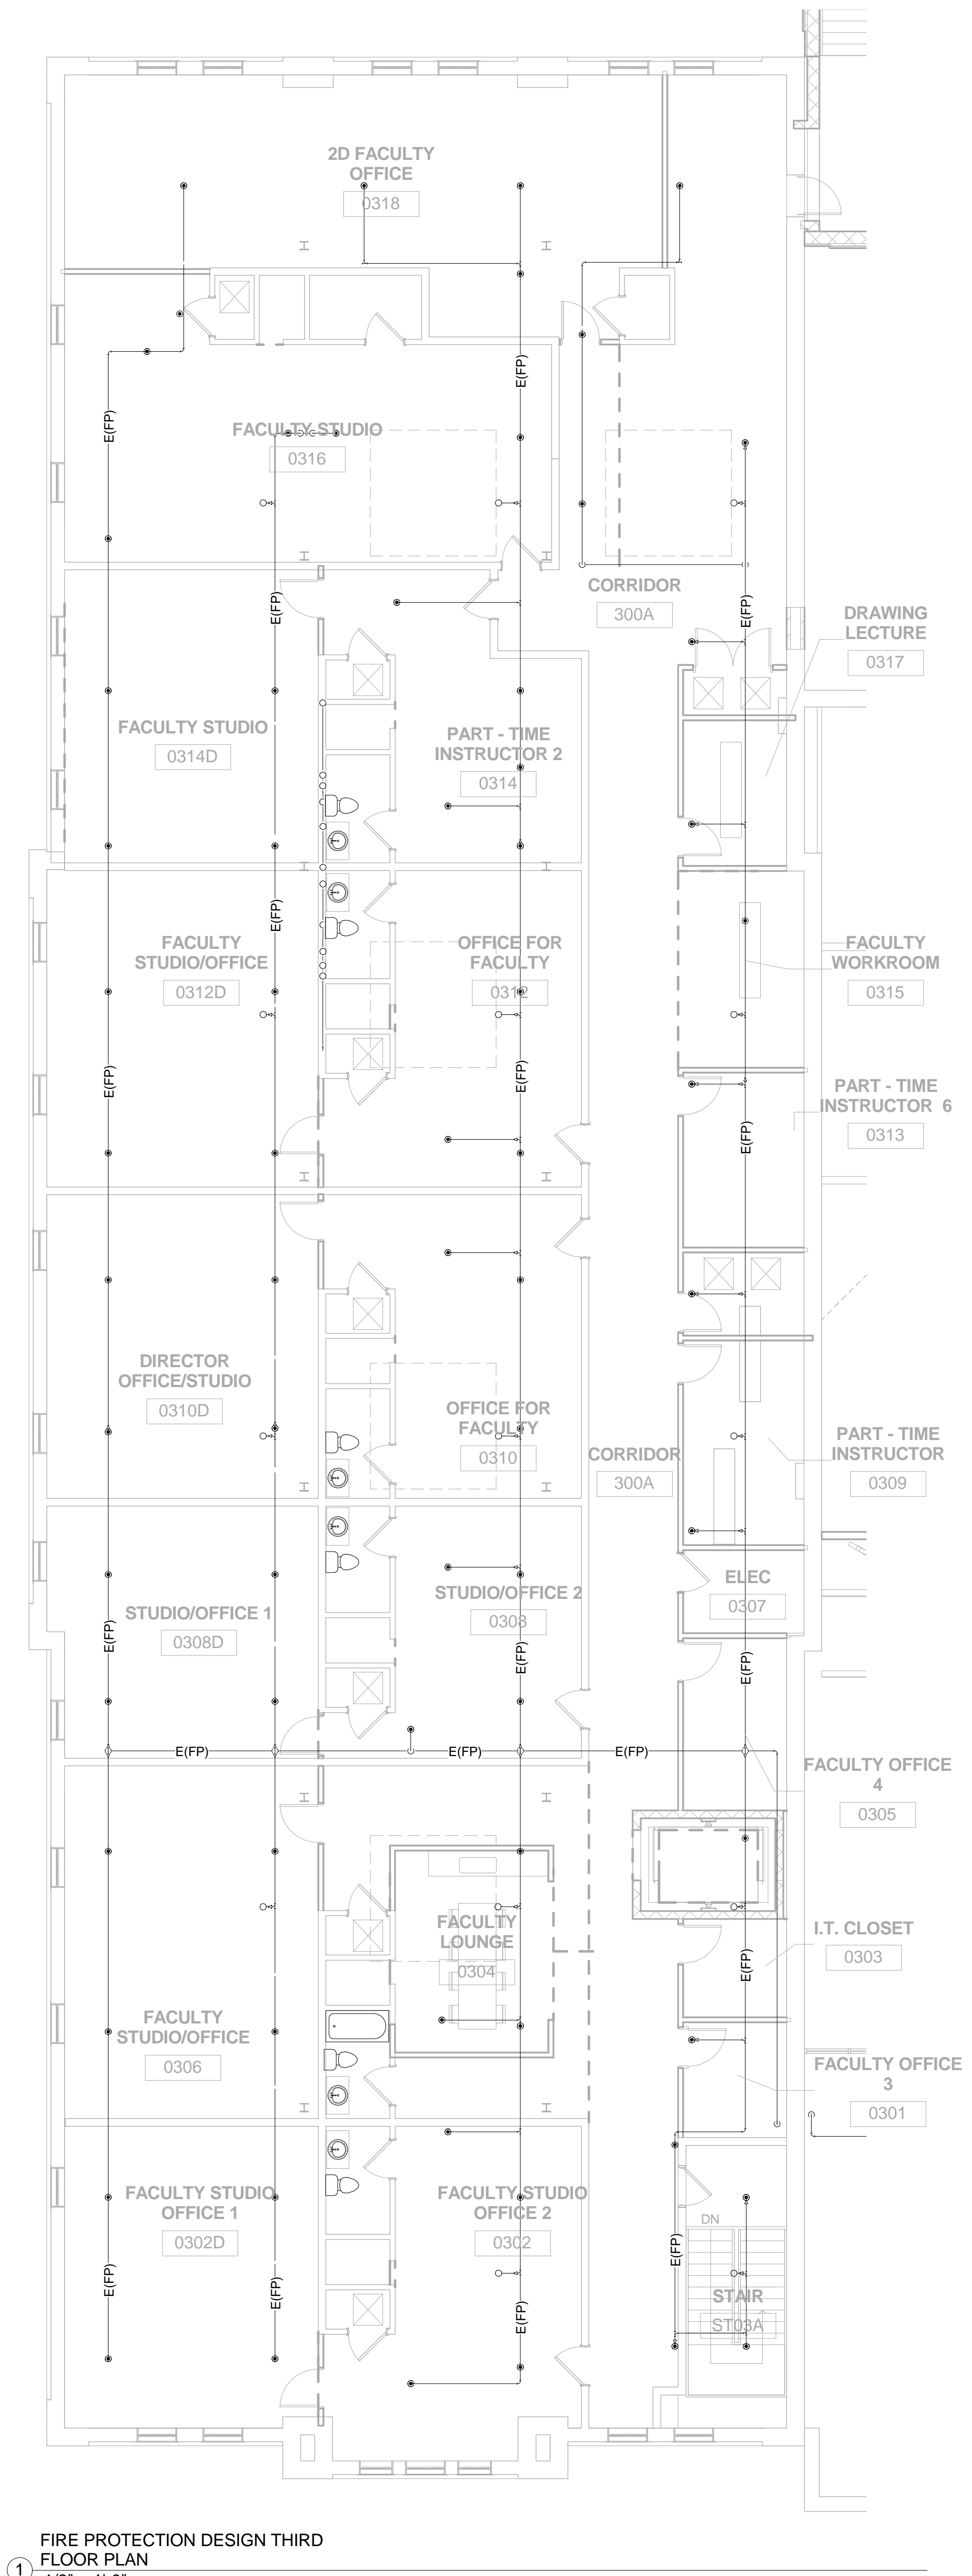

FIRE PROTECTION DESIGN THIRD FLOOR PLAN TAGGED NOTES

FIRE PROTECTION DESIGN THIRD FLOOR PLAN
 1/8" = 1'-0"