

UNIVERSITY LOFTS - Renovate Academic Facility UK School of Art & Visual Studies

AIR DISTRIBUTION DESIGN THIRD FLOOR PLAN

NOT FOR CONSTRUCTION Job Number: 1205

Date: 03/2013

Drawn By: Author

Checked By: Checker

Revision:




212 North Upper Street
 Lexington, Kentucky 40507-1001
 www.omniarchitects.com

This Drawing and the Design shown thereon are the property of Omni Architects. The reproduction, copying or other uses of this drawing without the written consent of Omni Architects is prohibited.

PRE-DESIGN

M3.3

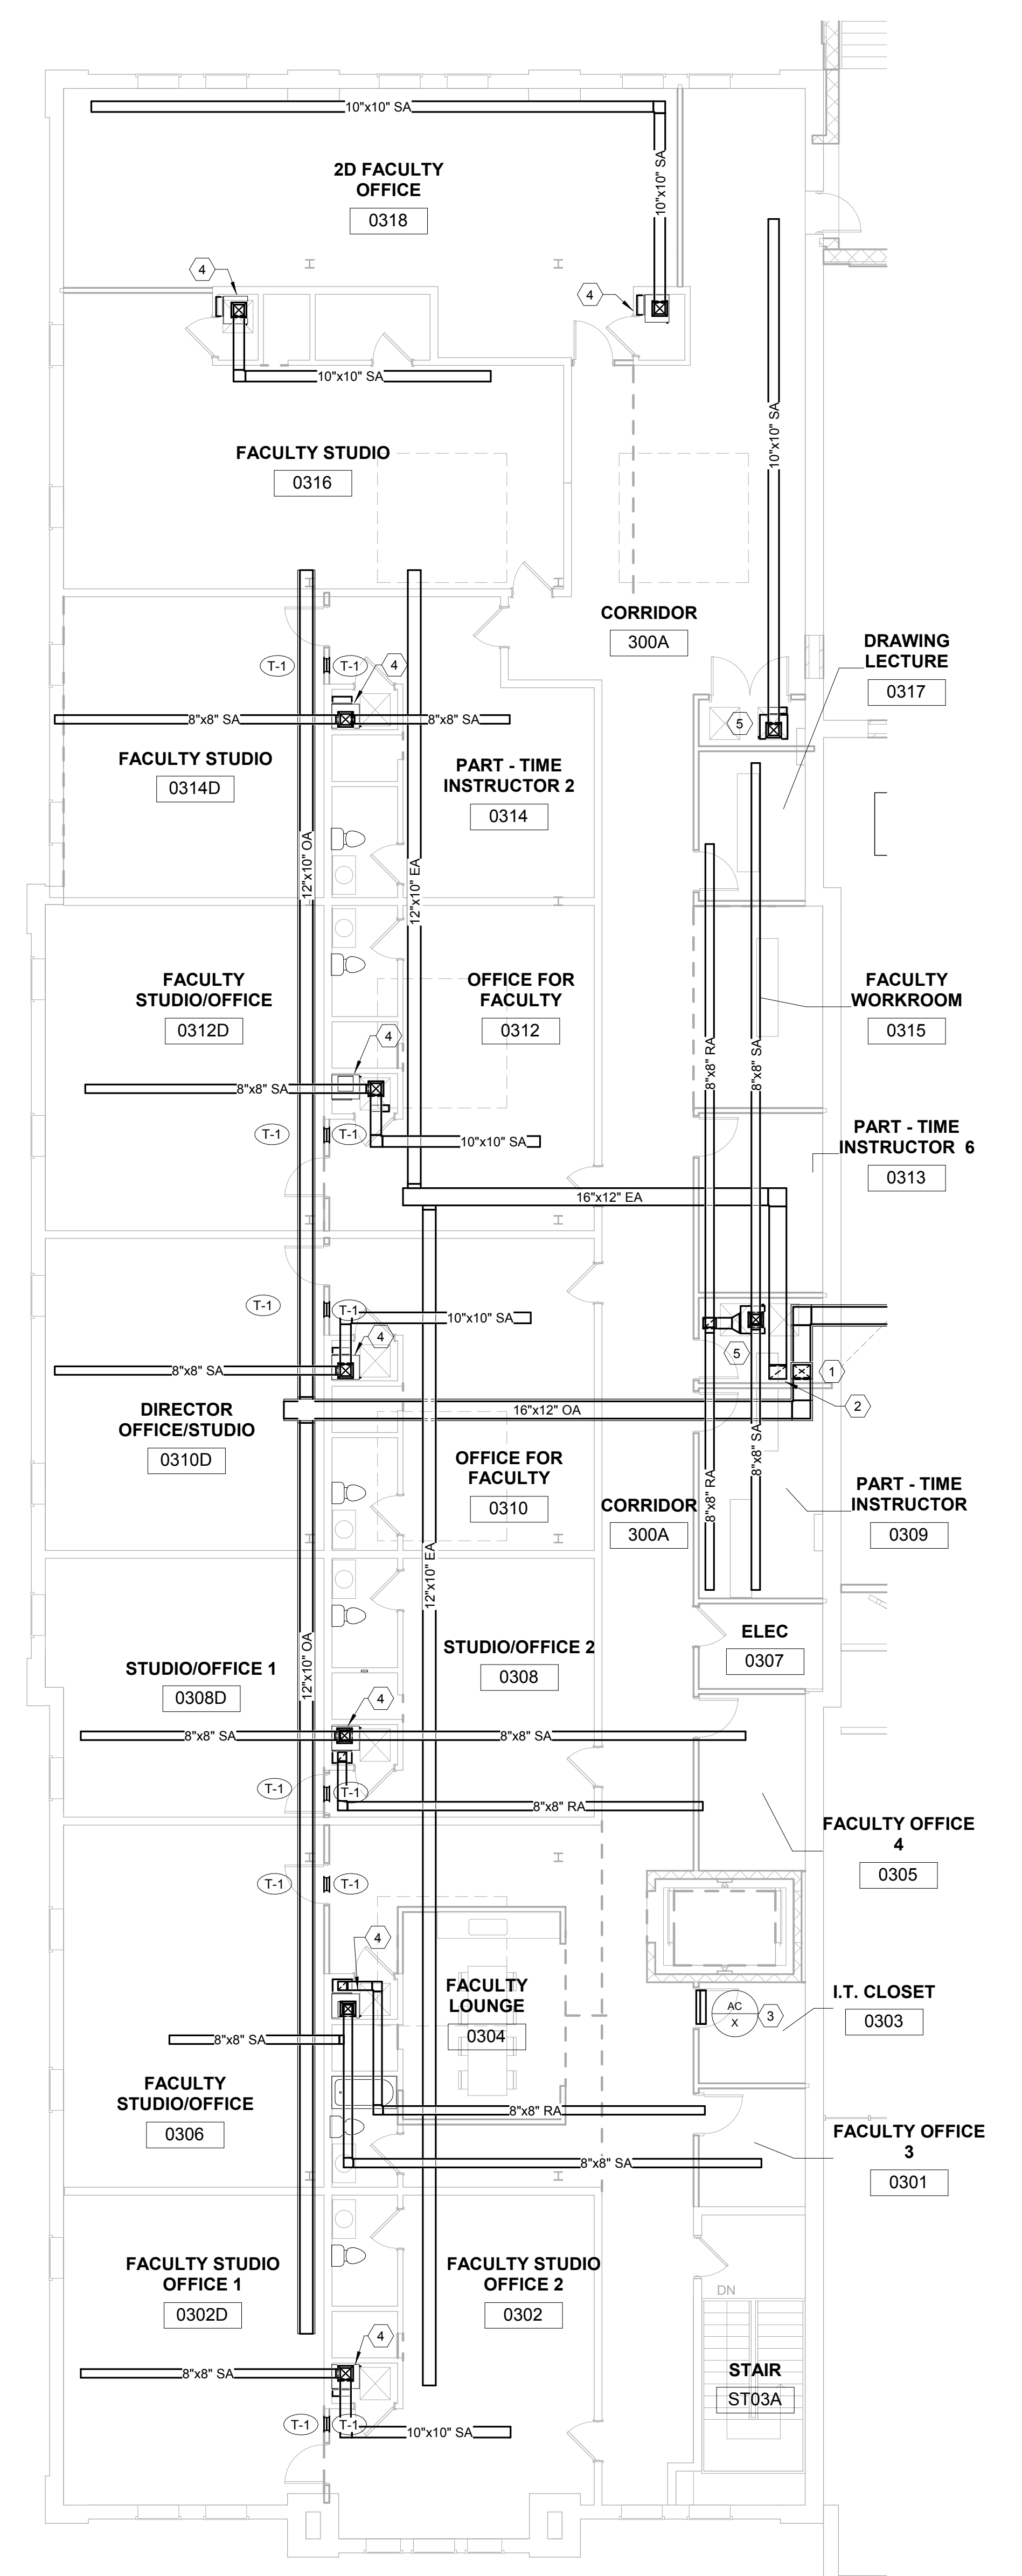

AIR DISTRIBUTION GENERAL NOTES

- A ALL EXPOSED DUCT WORK SHALL BE DUAL-WALL DUCT AND PAINTED. REFER TO SPECIFICATIONS FOR ADDITIONAL INFORMATION. COLOR SELECTED BY ARCHITECT.
- B ALL DARKROOM PENETRATIONS SHALL BE SEALED AIR TIGHT TO PREVENT ILLUMINATION SPILL FROM ADJACENT SPACE.

AIR DISTRIBUTION DESIGN THIRD FLOOR PLAN TAGGED NOTES

- 1 ROUTE OUTSIDE AIR DUCT DOWN. REFER TO AIR DISTRIBUTION SECOND FLOOR PLAN FOR CONTINUATION.
- 2 ROUTE EXHAUST AIR DUCT DOWN. REFER TO AIR DISTRIBUTION SECOND FLOOR PLAN FOR CONTINUATION.
- 3 MOUNT UNIT ABOVE DOOR.
- 4 EXISTING INDOOR UNIT TO REMAIN.
- 5 RELOCATED EXISTING INDOOR UNIT.

1 AIR DISTRIBUTION DESIGN THIRD FLOOR PLAN
 1/8" = 1'-0"