


1 HYDRONIC DESIGN BASEMENT PLAN  
1/8" = 1'-0"

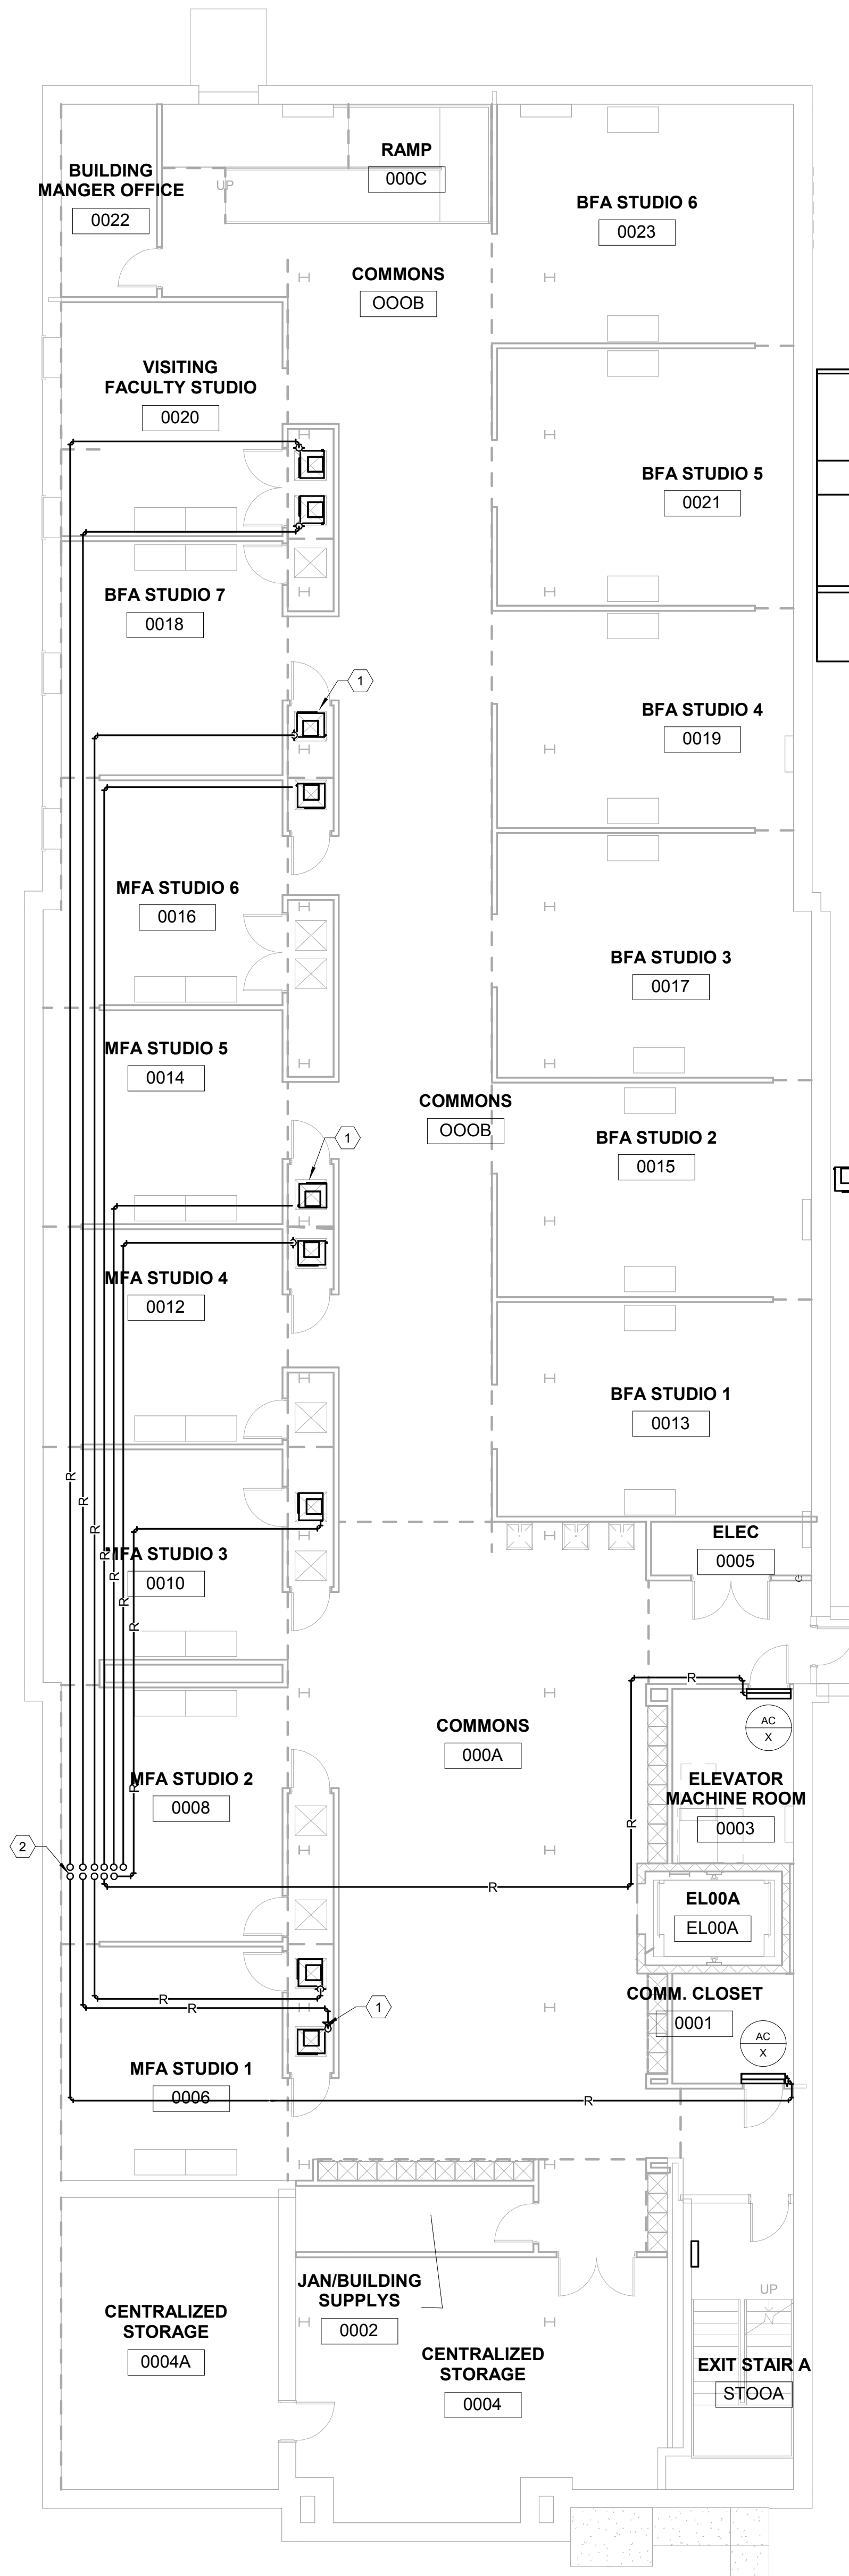

- HYDRONIC DESIGN BASEMENT PLAN TAGGED NOTES
- 1 RELOCATED EXISTING INDOOR UNIT. PROVIDE NEW REFRIGERANT PIPING FROM INDOOR UNIT TO CONDENSING UNIT. TYPICAL.
  - 2 ROUTE REFRIGERANT PIPING UP. REFER TO HVAC PIPING DESIGN FIRST FLOOR PLAN FOR CONTINUATION.

**UNIVERSITY LOFTS - Renovate Academic Facility UK School of Art & Visual Studies**

HVAC PIPING DESIGN BASEMENT PLAN

NOT FOR CONSTRUCTION Job Number: 1205

Date: 03/2013

Drawn By: Author

Checked By: Checker

Revision:



212 North Upper Street  
Lexington, Kentucky 40507-1001  
www.omniarchitects.com

This Drawing and the Design shown thereon are the property of Omni Architects. The reproduction, copying or other use of this drawing without the written consent of Omni Architects is prohibited.

PRE-DESIGN

**M4.0**