

UNIVERSITY LOFTS - Renovate Academic Facility UK School of Art & Visual Studies

HVAC PIPING DESIGN THIRD FLOOR PLAN

NOT FOR CONSTRUCTION Job Number: 1205

Date: 03/2013

Drawn By: Author

Checked By: Checker

Revision:




212 North Upper Street
 Lexington, Kentucky 40507-1001
 www.omniarchitects.com

This Drawing and the Design shown thereon are the property of Omni Architects. The reproduction, copying or other use of this drawing without the written consent of Omni Architects is prohibited.

PRE-DESIGN

M4.3

1 HYDRONIC DESIGN THIRD FLOOR PLAN
 1/8" = 1'-0"

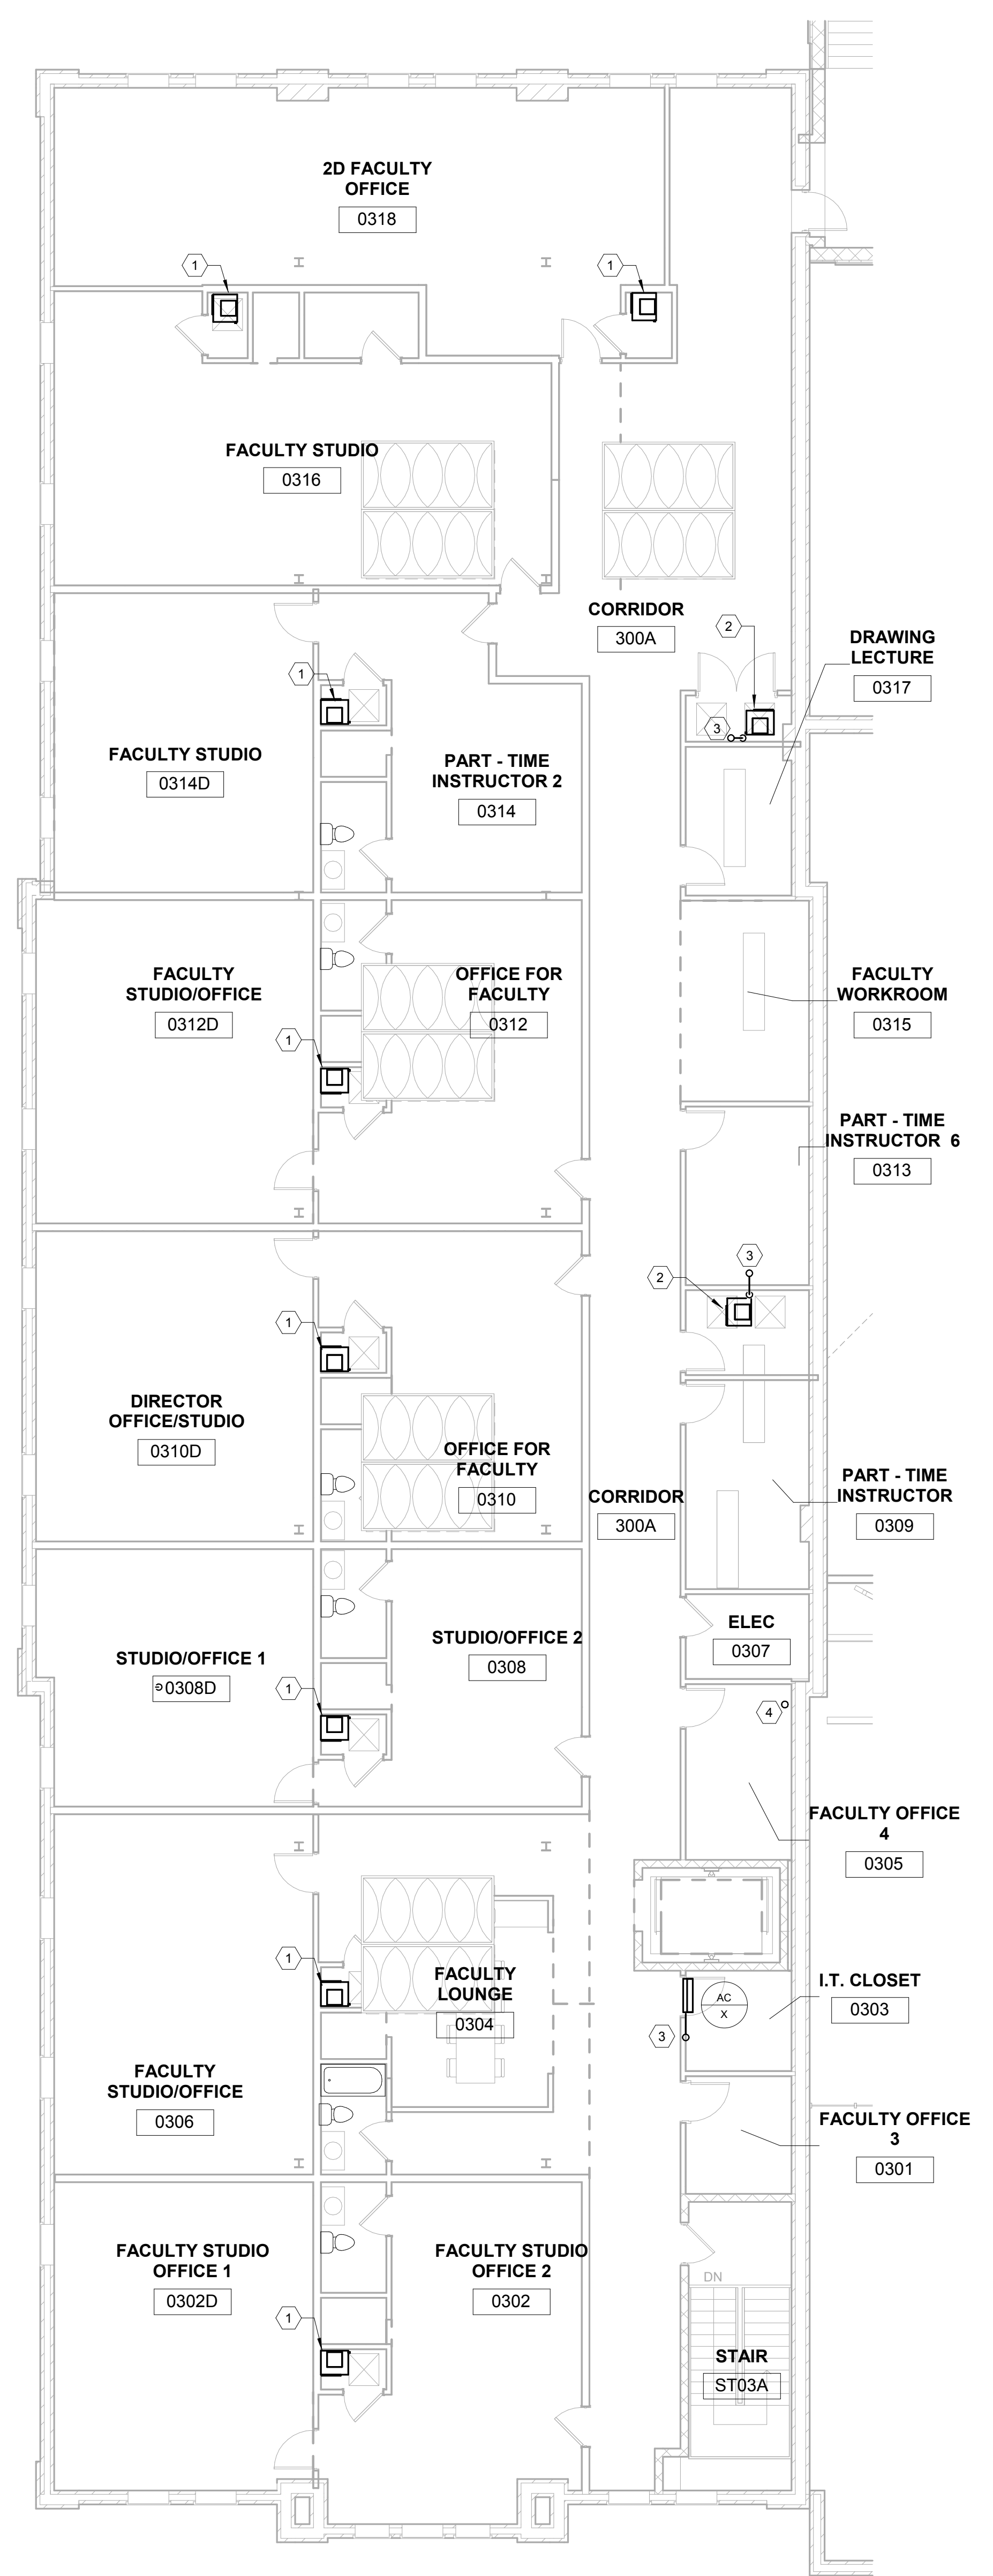

- HYDRONIC DESIGN THIRD FLOOR PLAN TAGGED NOTES (X)
- 1 EXISTING INDOOR UNIT, TO REMAIN, TYPICAL
 - 2 RELOCATED EXISTING INDOOR UNIT, PROVIDE NEW REFRIGERANT PIPING FROM INDOOR UNIT TO CONDENSING UNIT.
 - 3 ROUTE REFRIGERANT PIPING UP, REFER TO MECHANICAL DESIGN ROOF PLAN FOR CONTINUATION.
 - 4 ROUTE REFRIGERANT PIPING UP AND DOWN, REFER TO HYDRONIC DESIGN SECOND FLOOR AND MECHANICAL DESIGN ROOF PLAN FOR CONTINUATION.