

- PLUMBING DESIGN FIRST FLOOR PLAN TAGGED NOTES
- 1 CONNECT TO EXISTING DOMESTIC WATER LINE. FIELD VERIFY EXACT LOCATION FOR TIE-IN.
 - 2 CONNECT TO EXISTING SANITARY LINE. FIELD VERIFY EXACT LOCATION AND DEPTH FOR TIE-IN. REPAIR FLOOR SLAB TO MATCH EXISTING.
 - 3 2" DOMESTIC WATER LINE DOWN. REFER TO PLAN SHEET P3.0 FOR CONTINUATION.
 - 4 REFER TO HOT WATER HEATER DETAIL.
 - 5 DOMESTIC WATER LINE UP AND DOWN. REFER TO PLAN SHEET P3.0 AND P3.2 FOR CONTINUATION.
 - 6 VENT PIPING UP. REFER TO PLAN SHEET P3.2 FOR CONTINUATION.
 - 7 SANITARY PIPING UP. REFER TO PLAN SHEET P3.2 FOR CONTINUATION.
 - 8 2-1/2" COLD WATER LINE DOWN. REFER TO PLAN SHEET P3.0 FOR CONTINUATION.
 - 9 3/4" COMPRESSED AIR LINE UP. REFER TO PLAN SHEET P3.2 FOR CONTINUATION.
 - 10 4" CONCRETE HOUSEKEEPING PAD.
 - 11 2" SANITARY PIPING CONNECTING TO P-11 ON SECOND FLOOR. REFER TO SHEET P3.2 FOR CONTINUATION.
 - 12 3/4" DOMESTIC HOT WATER AND COLD WATER LINES UP TO SINK ON SECOND FLOOR.
 - 13 1/2" DOMESTIC HOT WATER AND COLD WATER LINES UP TO SINK ON SECOND FLOOR.
 - 14 SANITARY DOWN TO BELOW FLOOR SLAB.
 - 15 SANITARY SEWER PIPING ABOVE FIRST FLOOR CEILING.
 - 16 REFER TO PLAN SHEET U1.0 FOR CONTINUATION.
 - 17 2" VENT UP TO 3" VTR.

1 PLUMBING DESIGN FIRST FLOOR PLAN
1/8" = 1'-0"

UNIVERSITY LOFTS - Renovate Academic Facility UK School of Art & Visual Studies

PLUMBING DESIGN FIRST FLOOR PLAN


NOT FOR CONSTRUCTION Job Number: 1205 Date: 03/2013

Drawn By: Author Checked By: Checker Revision:

PRE-DESIGN



212 North Upper Street
Lexington, Kentucky 40507-1001
p.603.252.2252 f.603.252.2258
www.omniarchitects.com

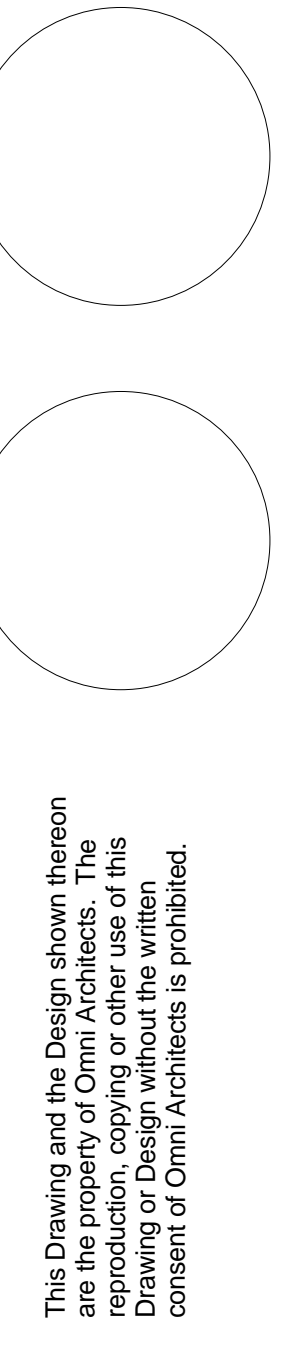

This Drawing and the Design shown thereon are the property of Omni Architects. The reproduction, copying or other use of this drawing without the written consent of Omni Architects is prohibited.