


2 WALL SECTION  
3/4" = 1'-0"



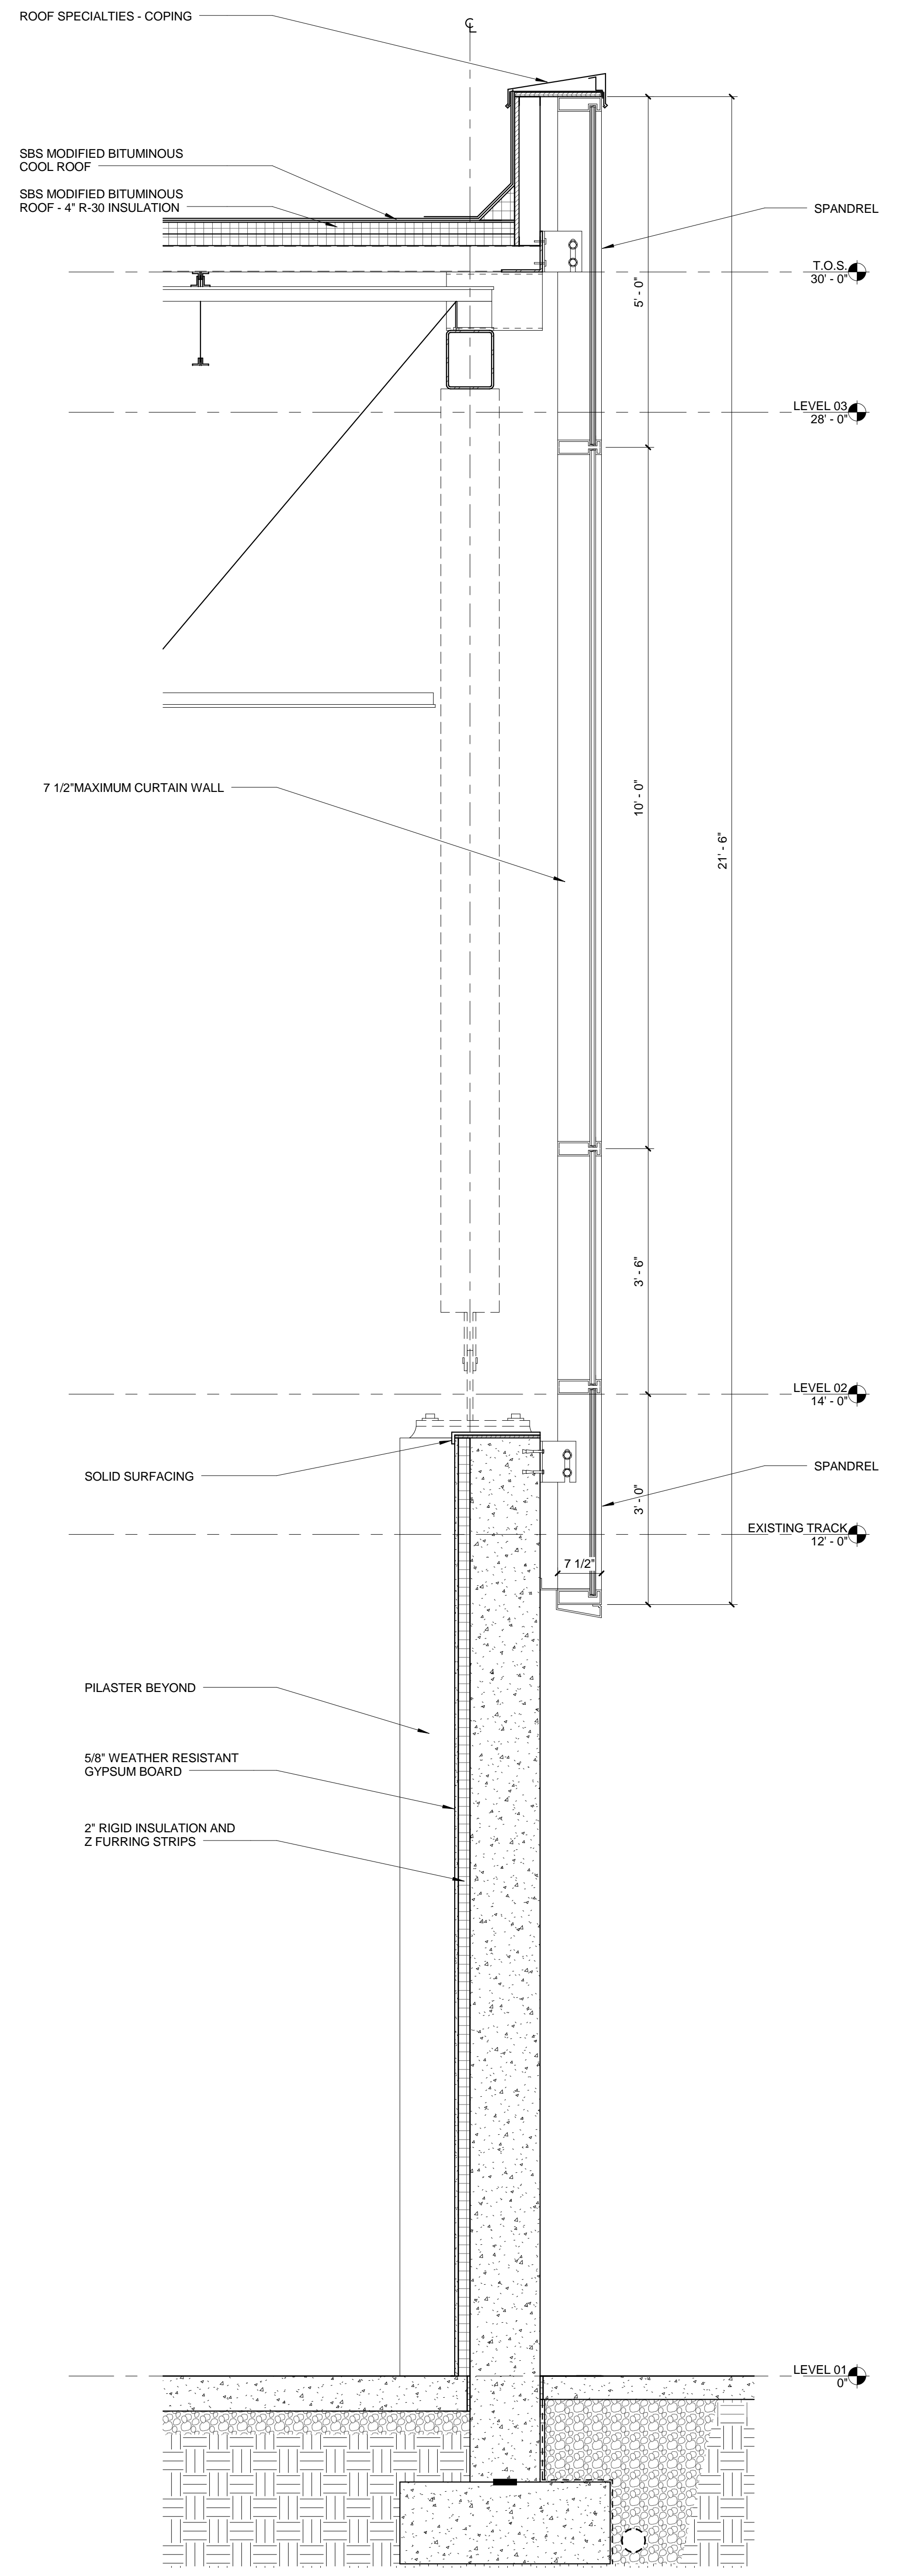


1 WALL SECTION  
3/4" = 1'-0"

# Northern Kentucky University - Campus Recreation Center

## 25% DD Package

Drawing Name:	Unnamed	#	Revision Date
NKU Project Number:	003869.00		
Project Number:	07/12/12		
Date:	Author	Checked By:	Checker

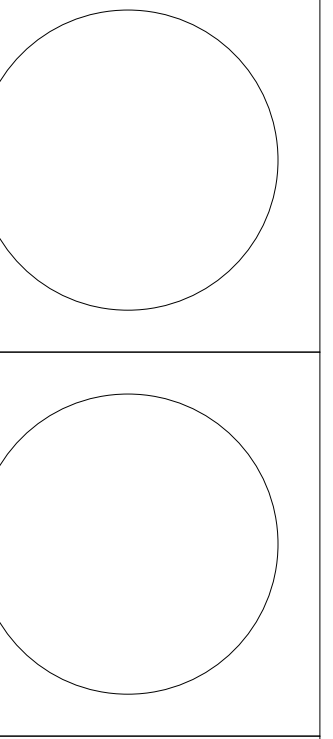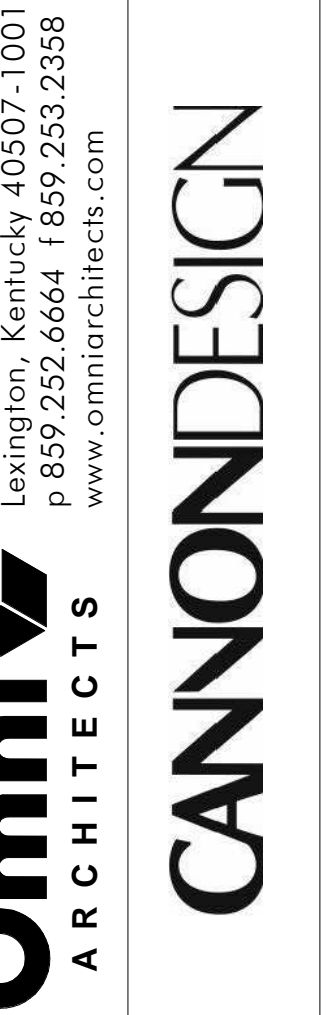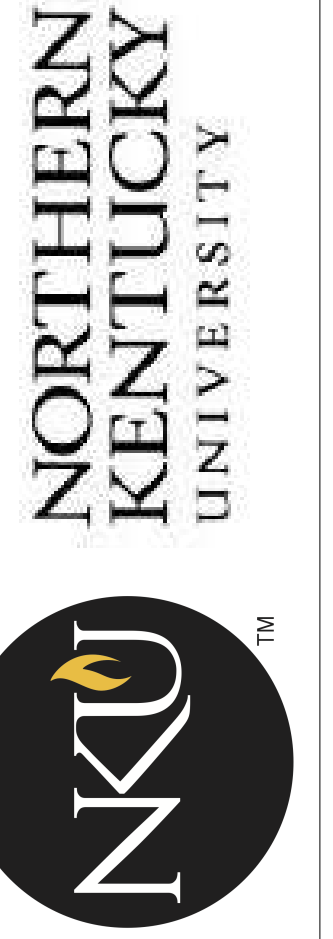

A-402