

DESIGNATOR	FIXTURE	HEIGHT	CW	HW	SAN	VENT
P-1	WATER CLOSET, WALL HUNG	15"	1/4"	---	4"	2"
P-1A	WATER CLOSET, WALL HUNG, ADA	17"	1/4"	---	4"	2"
P-1B	WATER CLOSET, FLOOR SET, ADA	17"	1/4"	---	4"	2"
P-2	LAVATORY, COUNTERTOP, ADA	34"	1/2"	1/2"	2"	1 1/2"
P-2A	LAVATORY, WALL HUNG, ADA	34"	1/2"	1/2"	2"	1 1/2"
P-3	URINAL	24"	3/4"	---	2"	1 1/2"
P-3A	URINAL, ADA	17"	3/4"	---	2"	1 1/2"
P-4	SHOWER - SHOWER FITTING SET	1/2"	1/2"	1/2"	2"	1 1/2"
P-4A	SHOWER, ADA, SHOWER FITTING SET	1/2"	1/2"	1/2"	2"	1 1/2"
P-5	BI-LEVEL, 2 STATION ELEC. WATER COOLER, RECESSED CHILLER	1/2"	---	---	1 1/2"	1 1/2"
P-5A	BOTTLE FILLING STATION - RECESSED CHILLER	1/2"	---	---	1 1/2"	1 1/2"
P-5B	3 STATION ELECTRIC WATER COOLER - SURFACE MOUNT	1/2"	---	---	1 1/2"	1 1/2"
P-6A	SINGLE COMPARTMENT SINK	1/2"	1/2"	1/2"	2"	1 1/2"
P-6B	DOUBLE COMPARTMENT SINK	1/2"	1/2"	1/2"	2"	1 1/2"
P-7	JANITOR'S SINK	3/4"	3/4"	3"	1 1/2"	---
P-8	LAUNDRY SINK	3/4"	3/4"	3"	1 1/2"	---
FD-1	SHOWER ROOM FLOOR DRAIN	---	---	---	3"	1 1/2"
FD-1	TOILET ROOM FLOOR DRAIN	---	---	---	3"	1 1/2"
FD-3	MECHANICAL ROOM FLOOR DRAIN W/ FUNNEL	---	---	---	3"	1 1/2"
FD-4	MECHANICAL ROOM FLOOR DRAIN	---	---	---	4"	2"



* ADA SPOUT MOUNTED AT 36" MAX. WITH 27" MINIMUM KNEE SPACE (ABOVE FINISHED FLOOR)

NOTES:

- PIPE SIZES ARE AS INDICATED UNLESS OTHERWISE NOTED ON FLOOR PLANS AND RESEV. DRAWINGS.
- MINIMUM 2" SANITARY PIPING UNDERGROUND.
- PROVIDE ALL REQUIRED PIPING TO FIXTURES INDICATED ON THE FLOOR PLANS, INDICATED WITH A "P". DESIGNATION. PROVIDE PIPING OF SIZE INDICATED IN THIS SCHEDULE.

PLUMBING LEGEND

FD	FLOOR DRAIN	
RD	ROOF DRAIN	
OSD	OVERFLOW SCUPPER DRAIN	
HB	HOSE BIBB	
VTR	VENT THRU ROOF	
WHA	WATER HAMMER ARRESTOR	
WH	WATER HEATER	
CO	CLEANOUT	
ECO	EXTERIOR CLEANOUT	
FPWH	FREEZE PROOF WALL HYDRANT	
TYP	TYPICAL	
NTS	NOT TO SCALE	
AFF	ABOVE FINISHED FLOOR	
W	POTABLE WATER PIPING	
SS	SANITARY PIPING	
GL	STORM PIPING	
QL	DEDICATED GREASE WASTE PIPING	
GL	NATURAL GAS PIPING	
V	SANITARY VENT PIPING	
---	DOMESTIC COLD WATER PIPING (CW)	
---	DOMESTIC HOT WATER (110°F-) PIPING (HW)	
---	DOMESTIC HOT WATER (110°F-) RETURN PIPING (HWR)	
---	RELIEF VALVE DISCHARGE PIPING	
RVD	UNION	
---	GATE VALVE	
---	DIRECT DIGITAL CONTROL TEMP. SENSOR	
---	FLOW METER	
---	DIAL THERMOMETER	
---	PRESSURE GAUGE	
---	PIPING ELBOW (TURNED UP/DOWN)	
---	PIPE TEE (TURNED UP/DOWN)	
---	BALL VALVE	
---	DOUBLE CHECK VALVE ASSEMBLY	
---	CHECK VALVE	
---	SAFETY OR RELIEF VALVE	
---	REDUCED PRESSURE BACKFLOW PREVENTER	

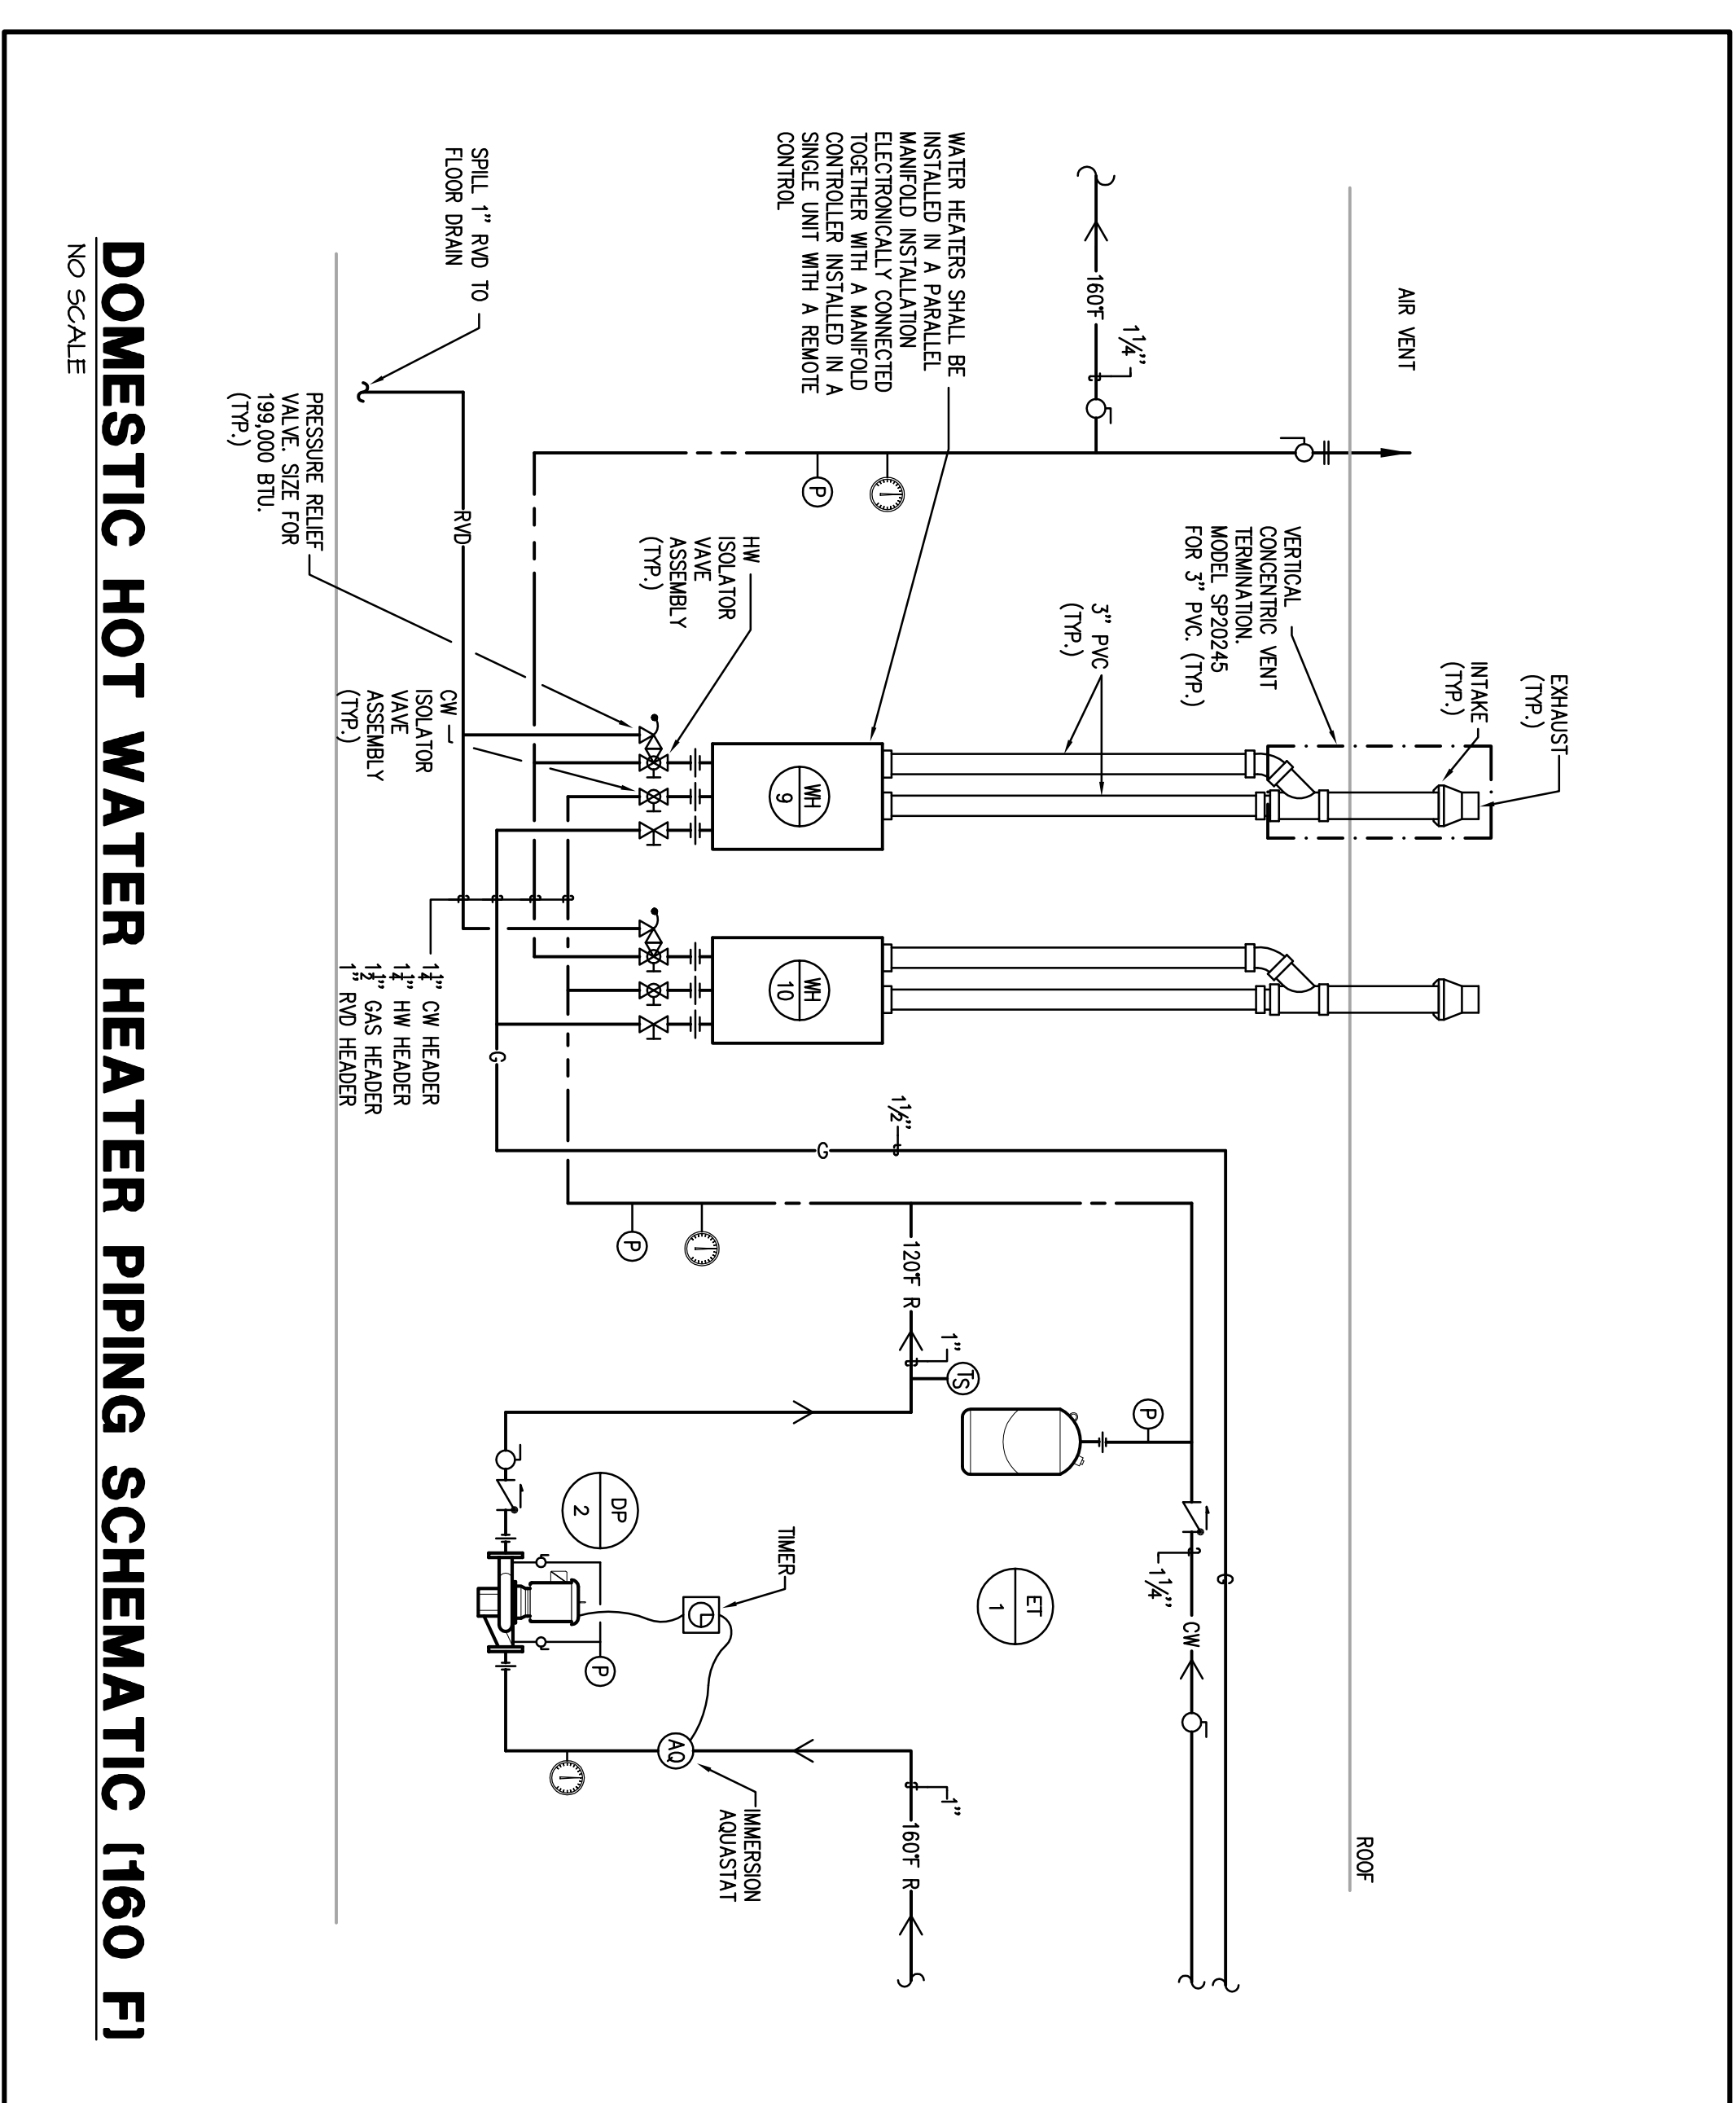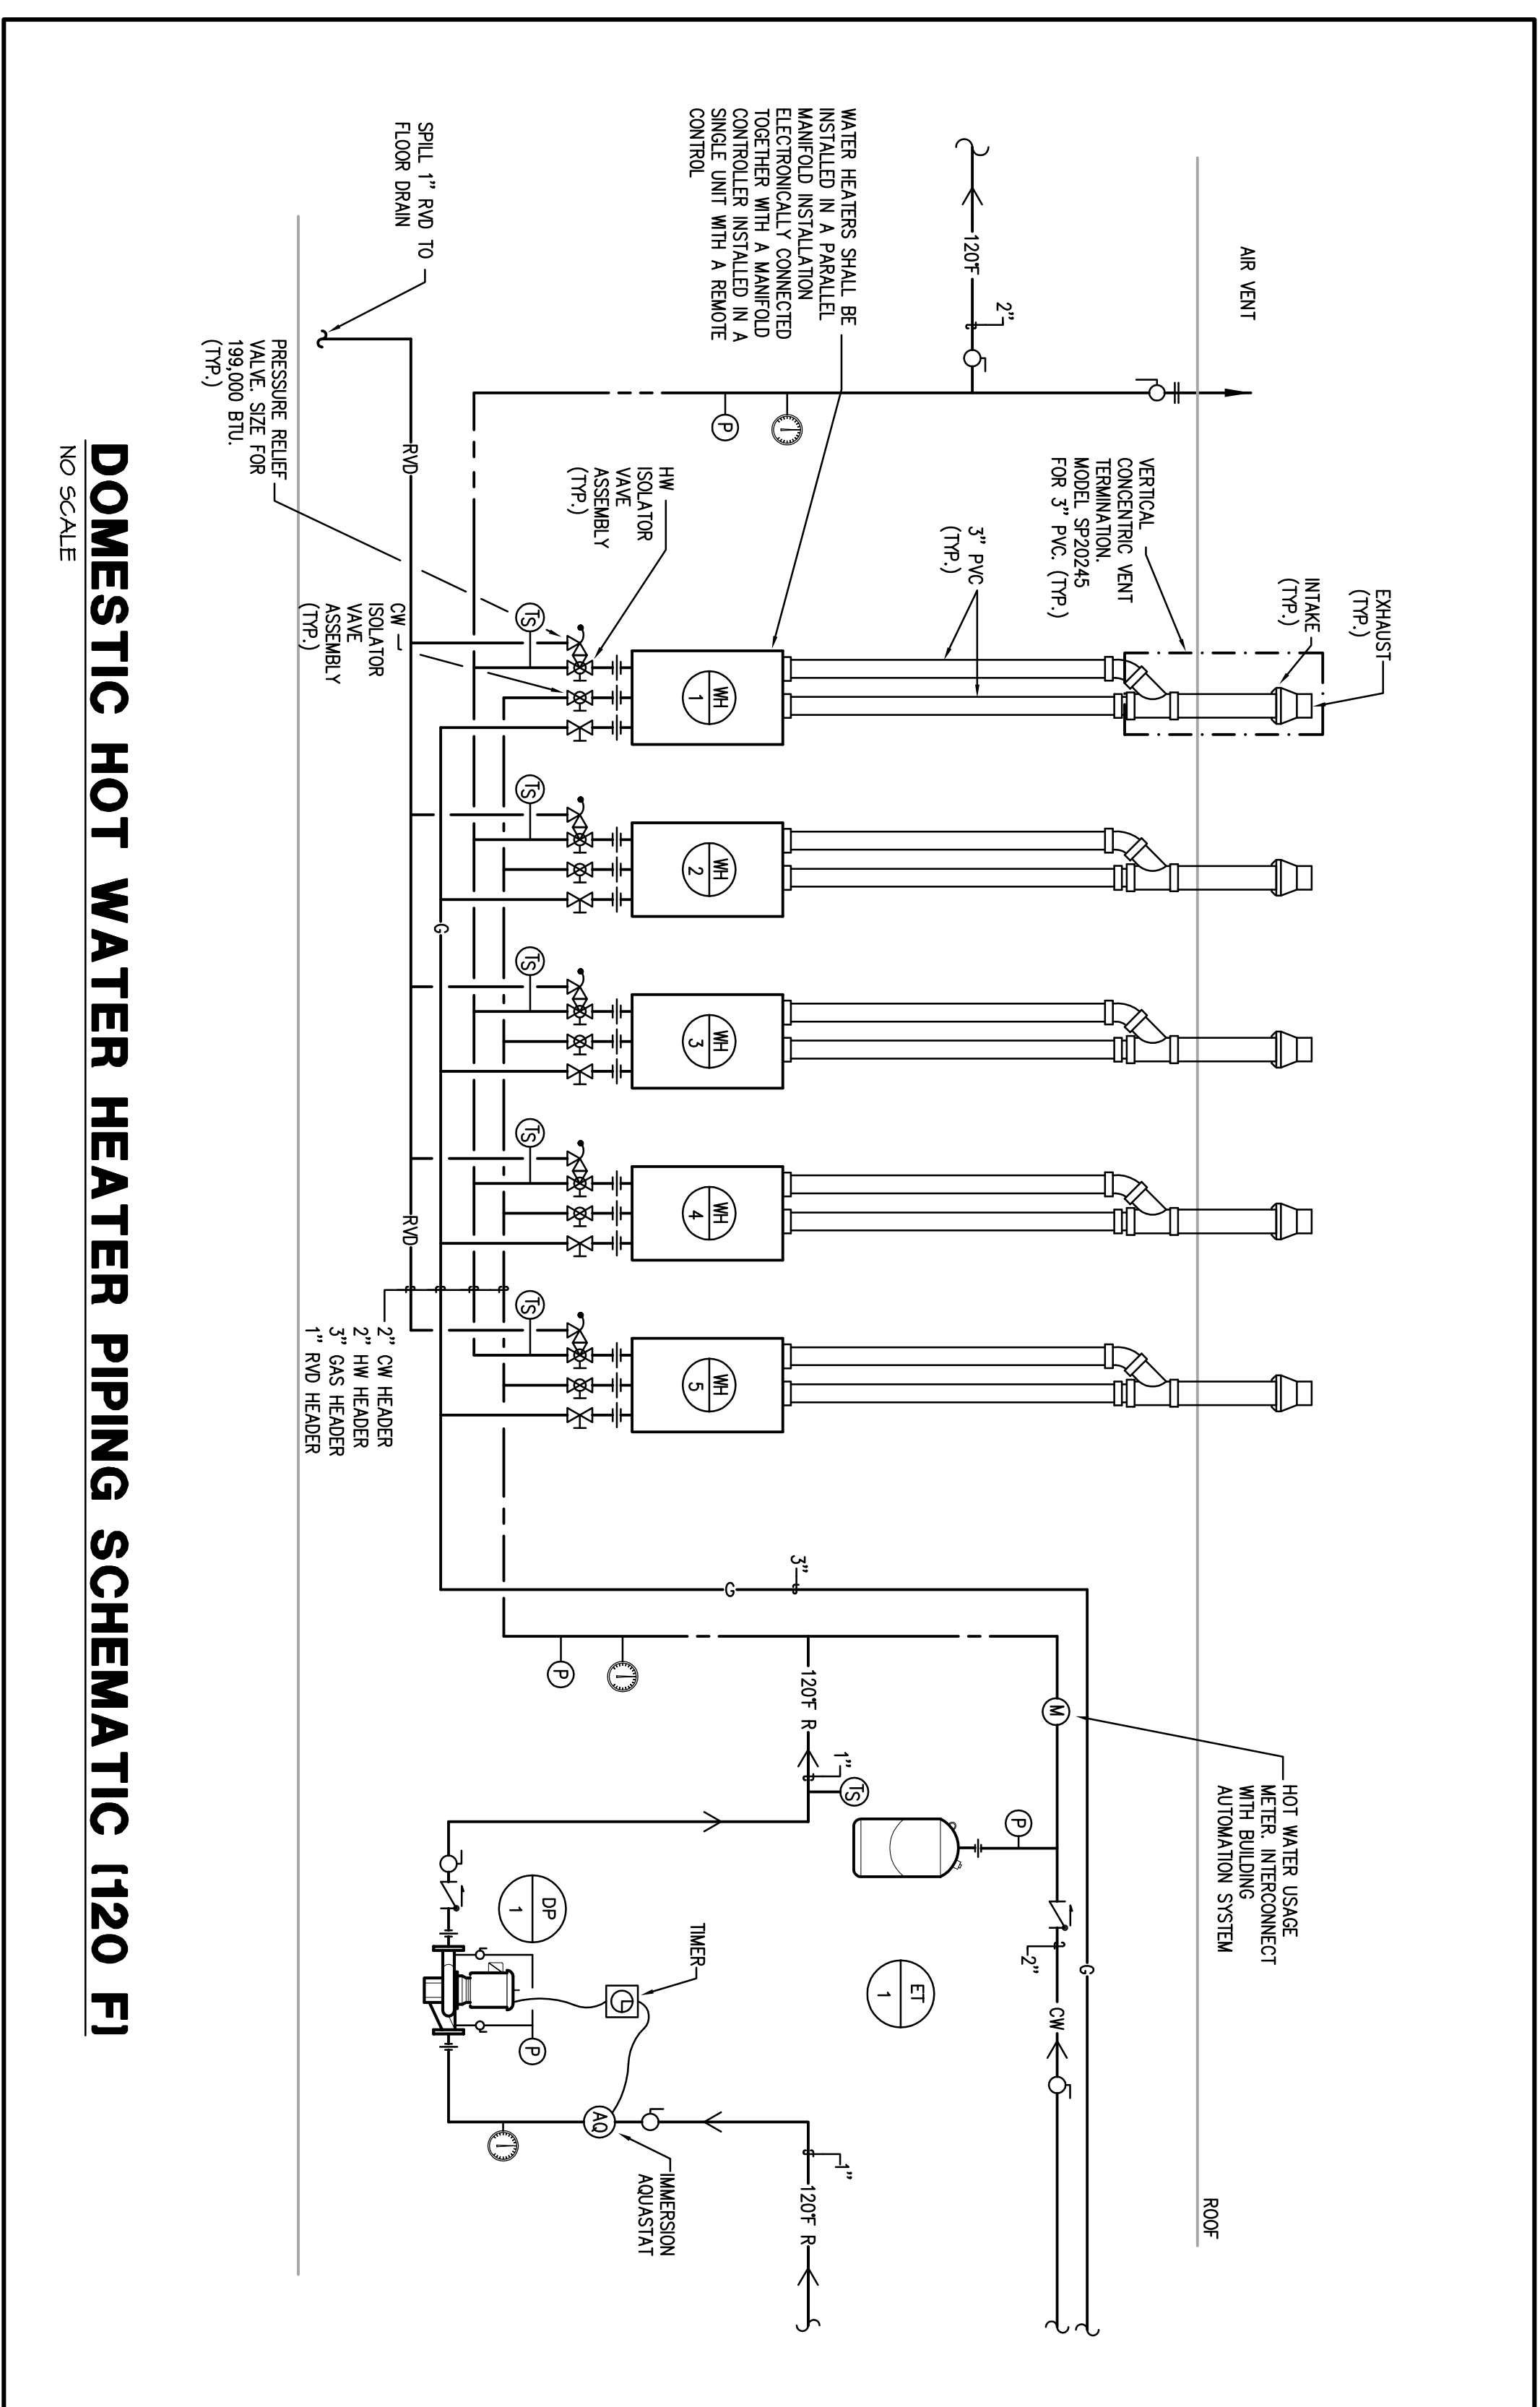


Northern Kentucky University - Student Recreation Center

Drawing Name:	#	Revision Date
Plumbing Legend and Schedules	1	
Owner Project Number:	2	
Project Number:	3	03667.00
Date:	4	August 2, 2012
Drawn By:	5	JAT
Checked By:	6	JEF




Omni ARCHITECTS
212 North Upper Street
Lexington, Kentucky 40507-1001
p 859.252.6664 f 859.253.2358
www.omniarchitects.com


CANNONDESIGN

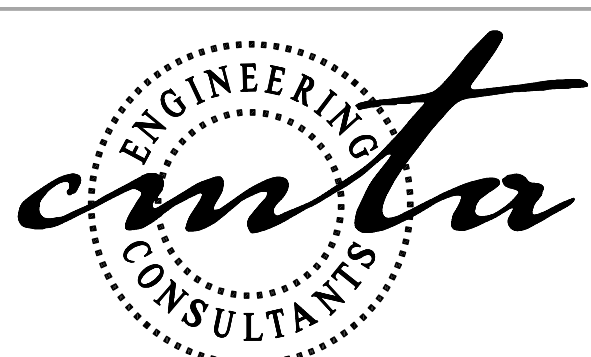


10411 Meeting Street,
Prospect, Kentucky 40059
p 502.326.3085 f 502.326.2691
www.cmtaegr.com

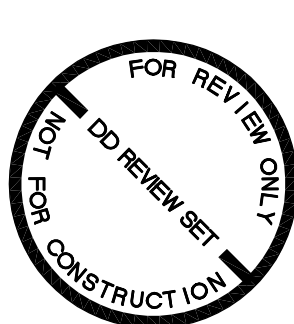

P0001

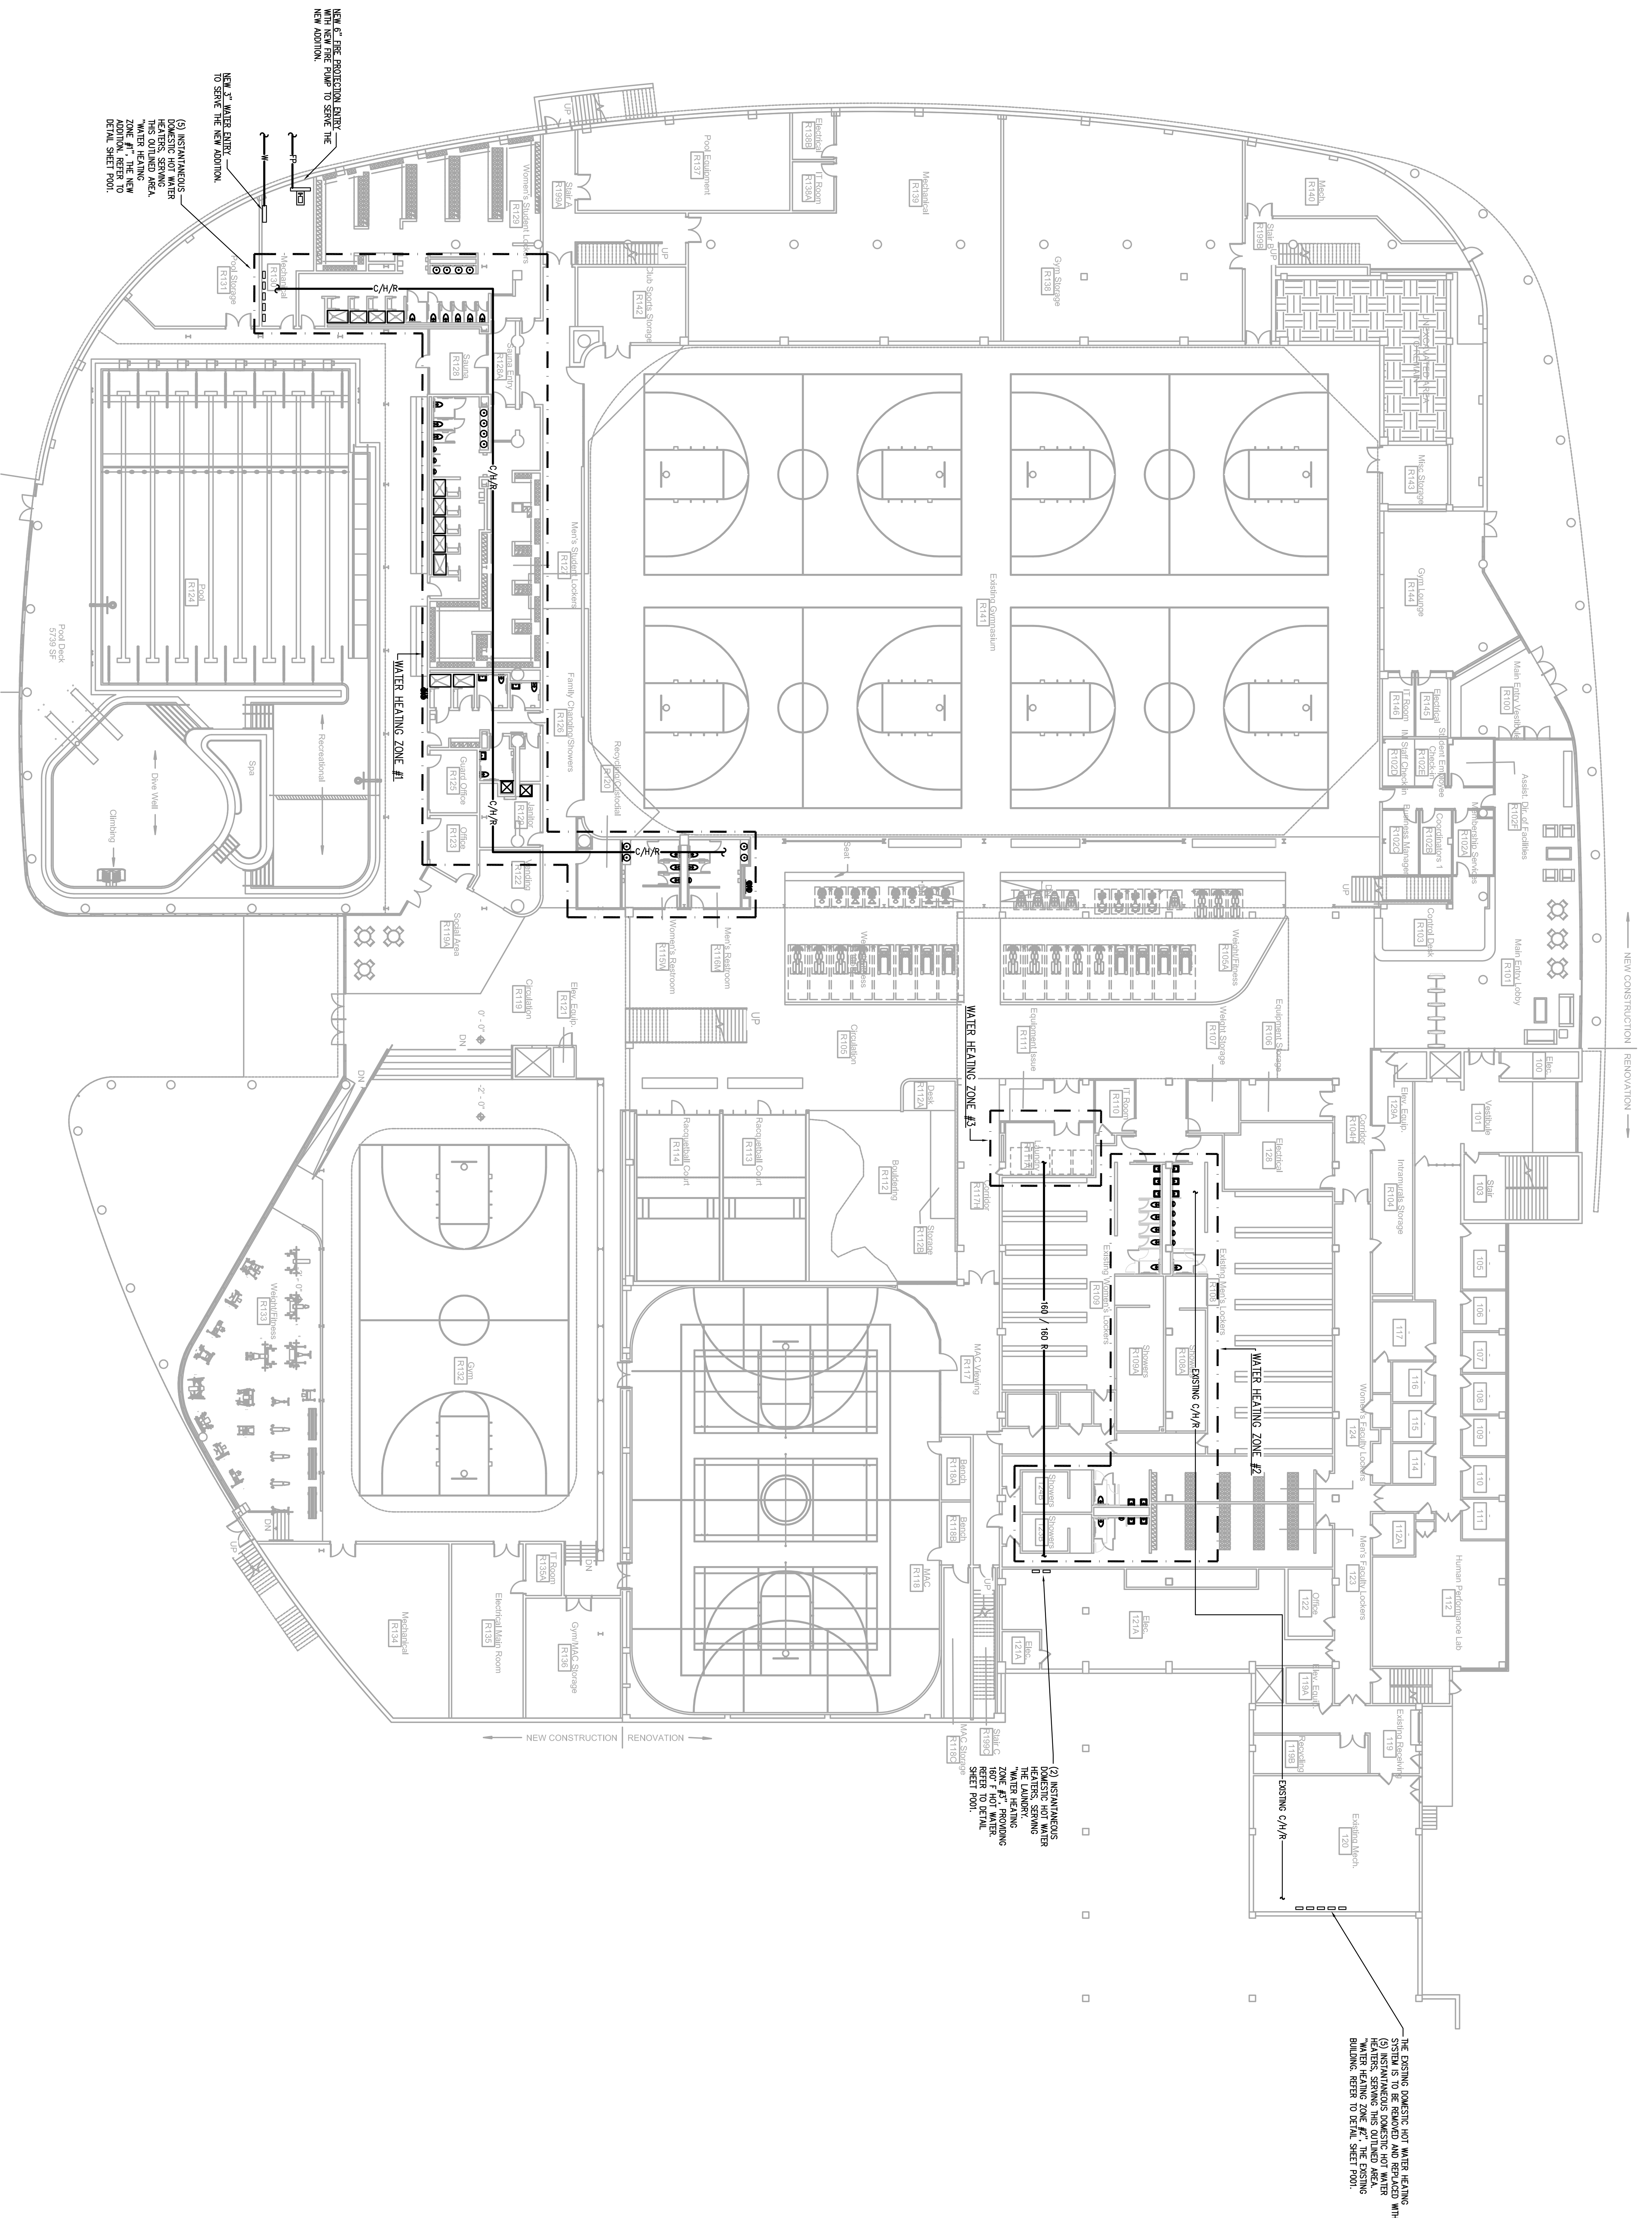

FIRST FLOOR PLAN - PLUMBING
 SCALE: 1/16" = 1'-0"

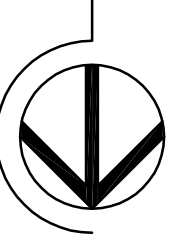

Northern Kentucky University - Student Recreation Center


Drawing Name:	#	Revision Date
Owner Project Number:	1	
Project Number:	2	03667.00
Date:	3	August 2, 2012
Drawn By:	4	JAT
Checked By:	5	JEF
	6	
	7	
	8	



NORTHERN KENTUCKY UNIVERSITY

Omni ARCHITECTS
 212 North Upper Street
 Lexington, Kentucky 40507-1001
 p 859.252.6664 f 859.253.2358
 www.omniarchitects.com


CANNONDESIGN

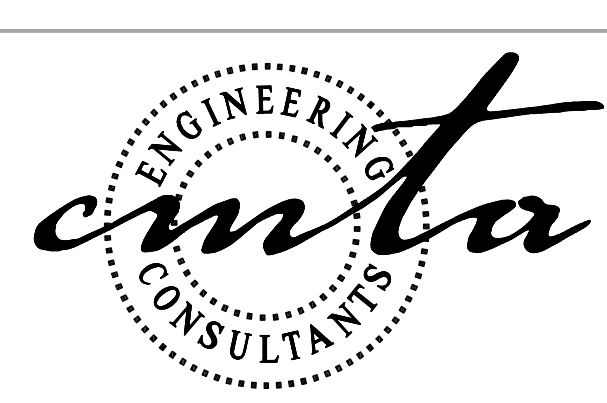

10411 Meeting Street,
 Prospect, Kentucky 40059
 p 502.326.3085 f 502.326.2691
 www.cmtaegr.com




P0101

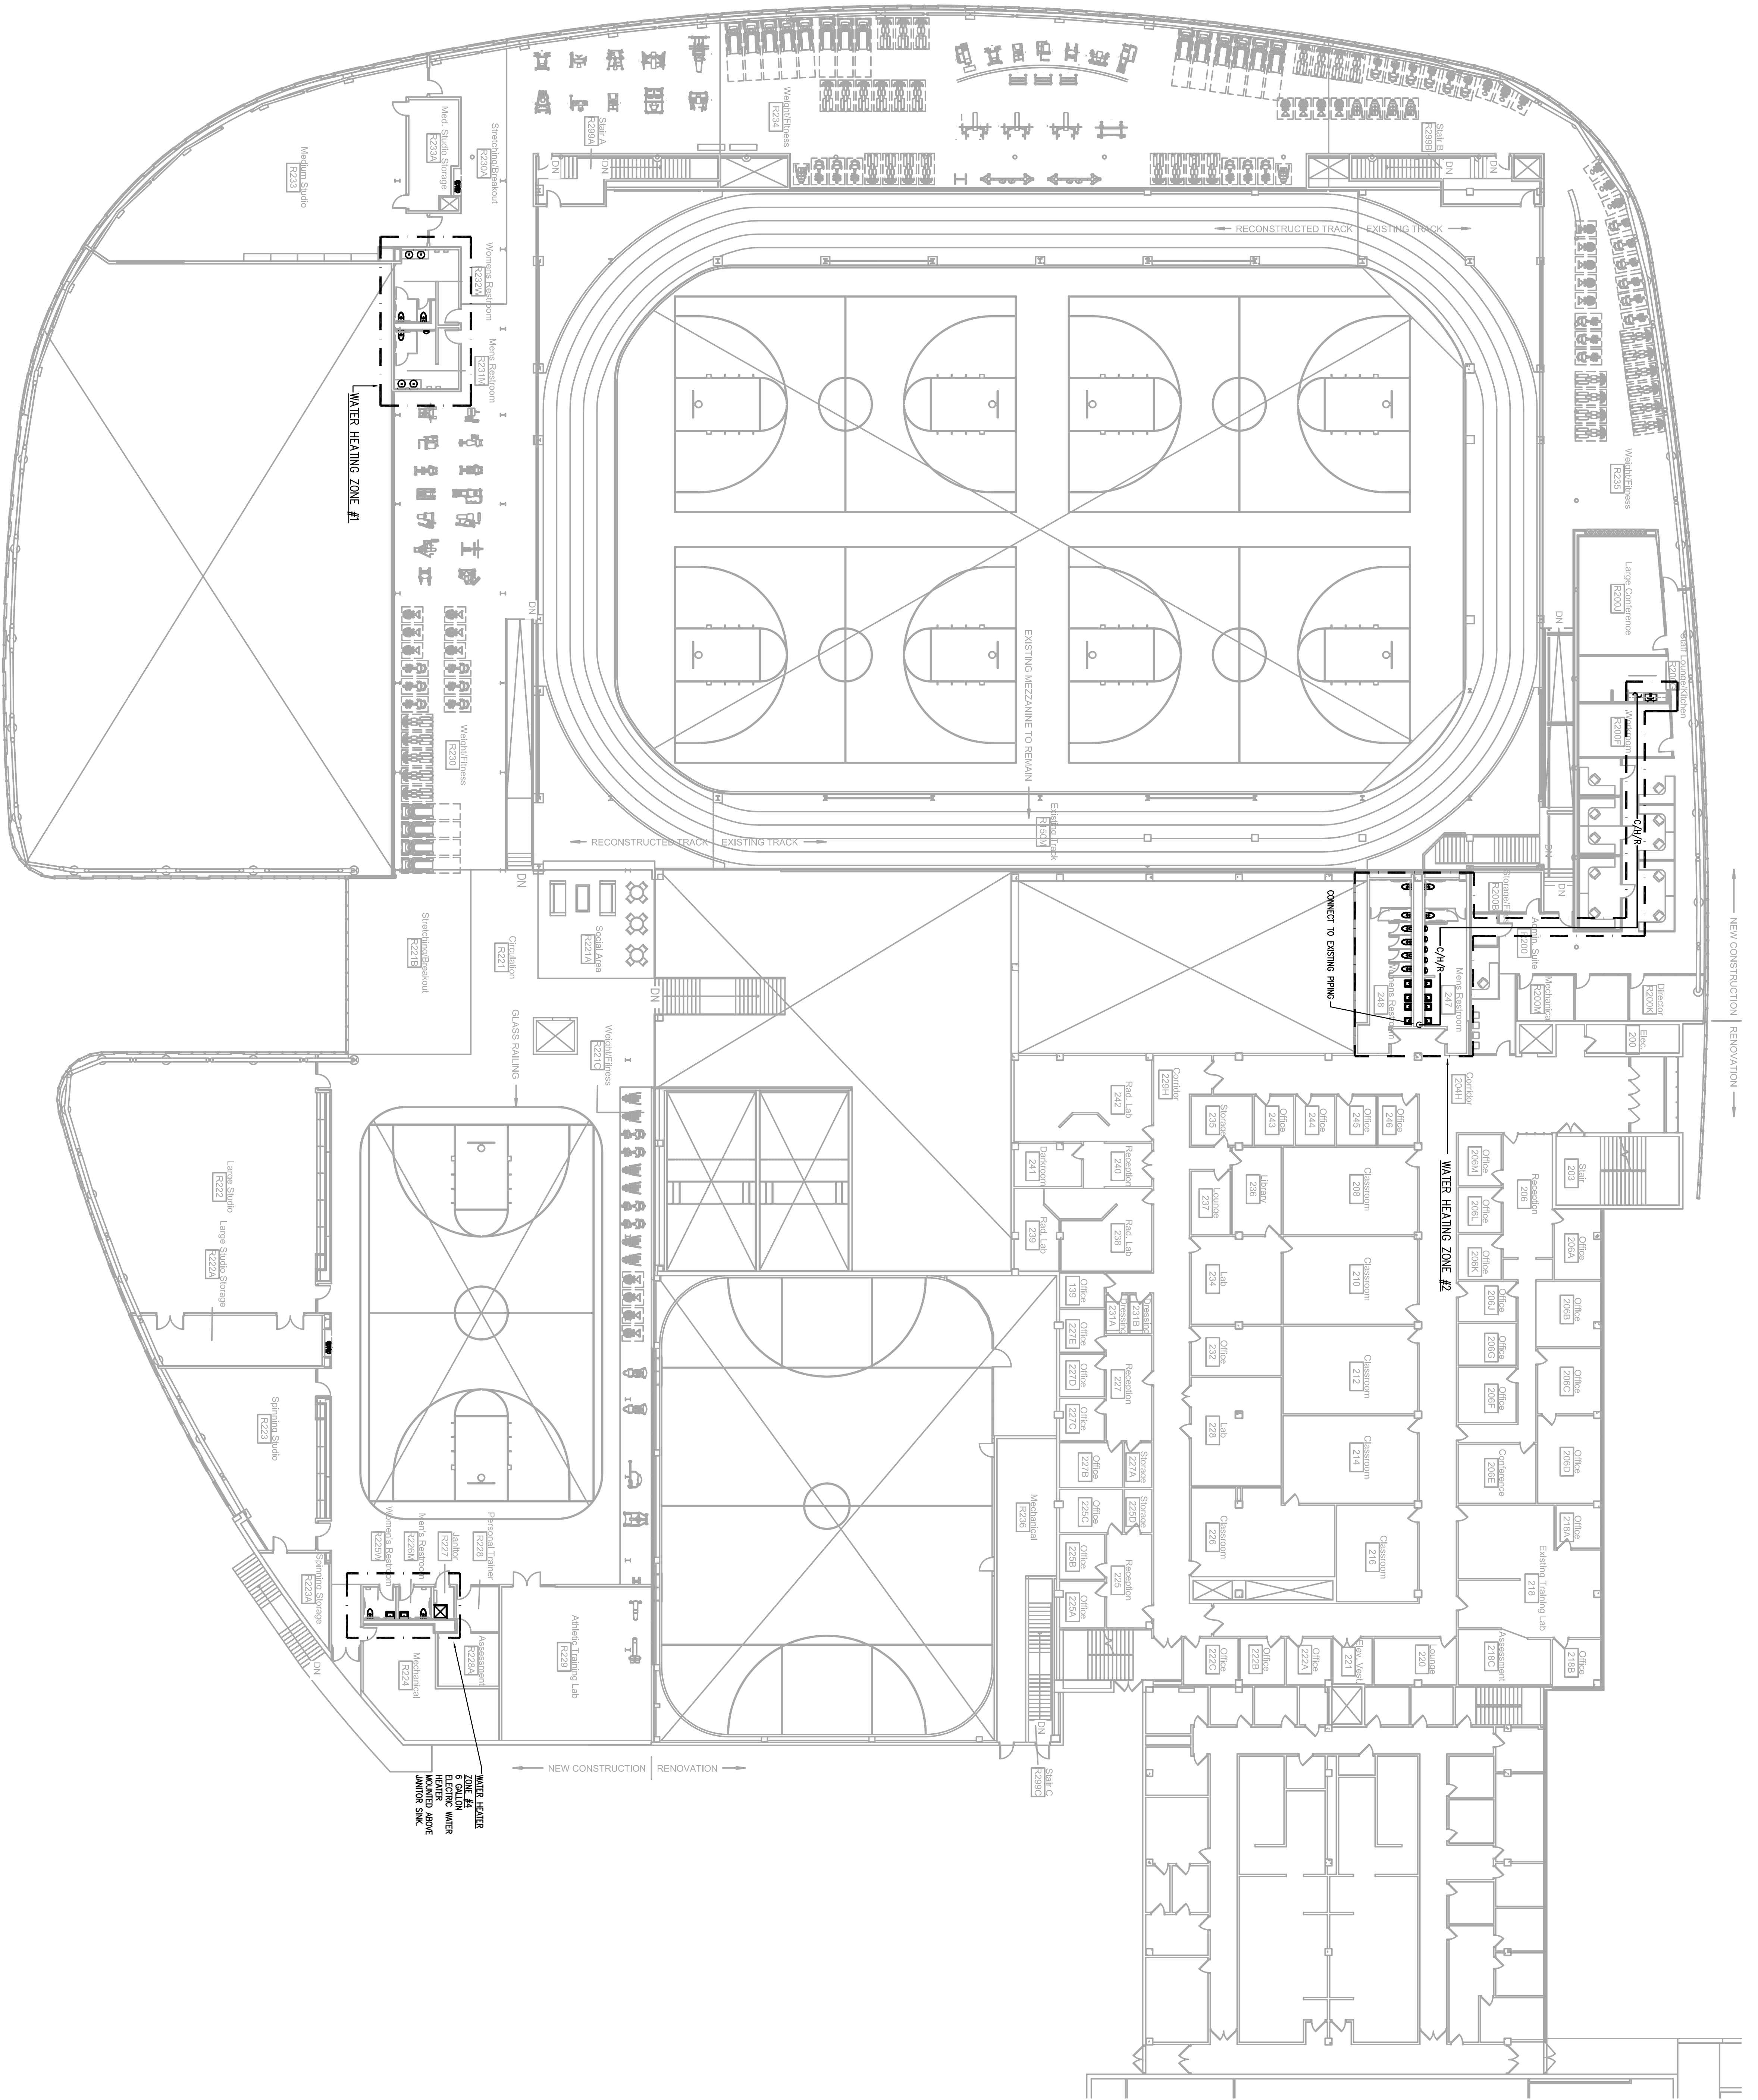

SECOND FLOOR PLAN - PLUMBING

SCALE: 1/16" = 1'-0"

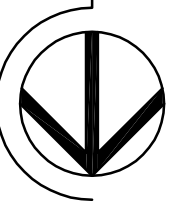

Northern Kentucky University - Student Recreation Center


Drawing Name:	#	Revision Date
Owner Project Number:	1	
Project Number:	2	03667.00
Date:	3	August 2, 2012
Drawn By:	4	JAT
Checked By:	5	JEF
	6	
	7	
	8	




NORTHERN KENTUCKY UNIVERSITY

Omni ARCHITECTS
 212 North Upper Street
 Lexington, Kentucky 40507-1001
 p 859.252.6664 f 859.253.2358
 www.omniarchitects.com


CANNONDESIGN

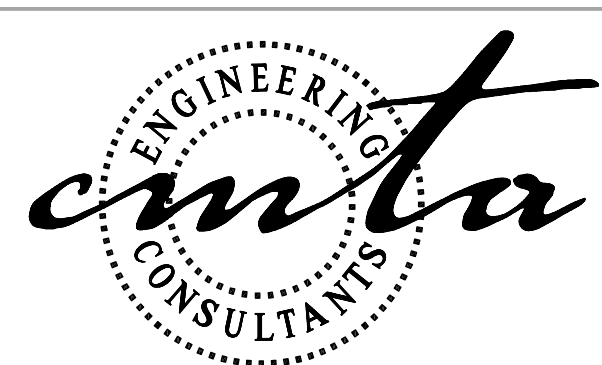


10411 Meeting Street,
 Prospect, Kentucky 40059
 p 502.326.3085 f 502.326.2691
 www.cmtaegr.com

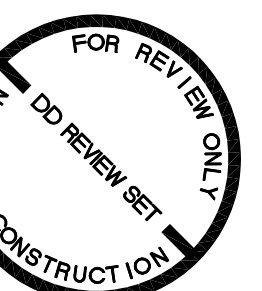

P0102

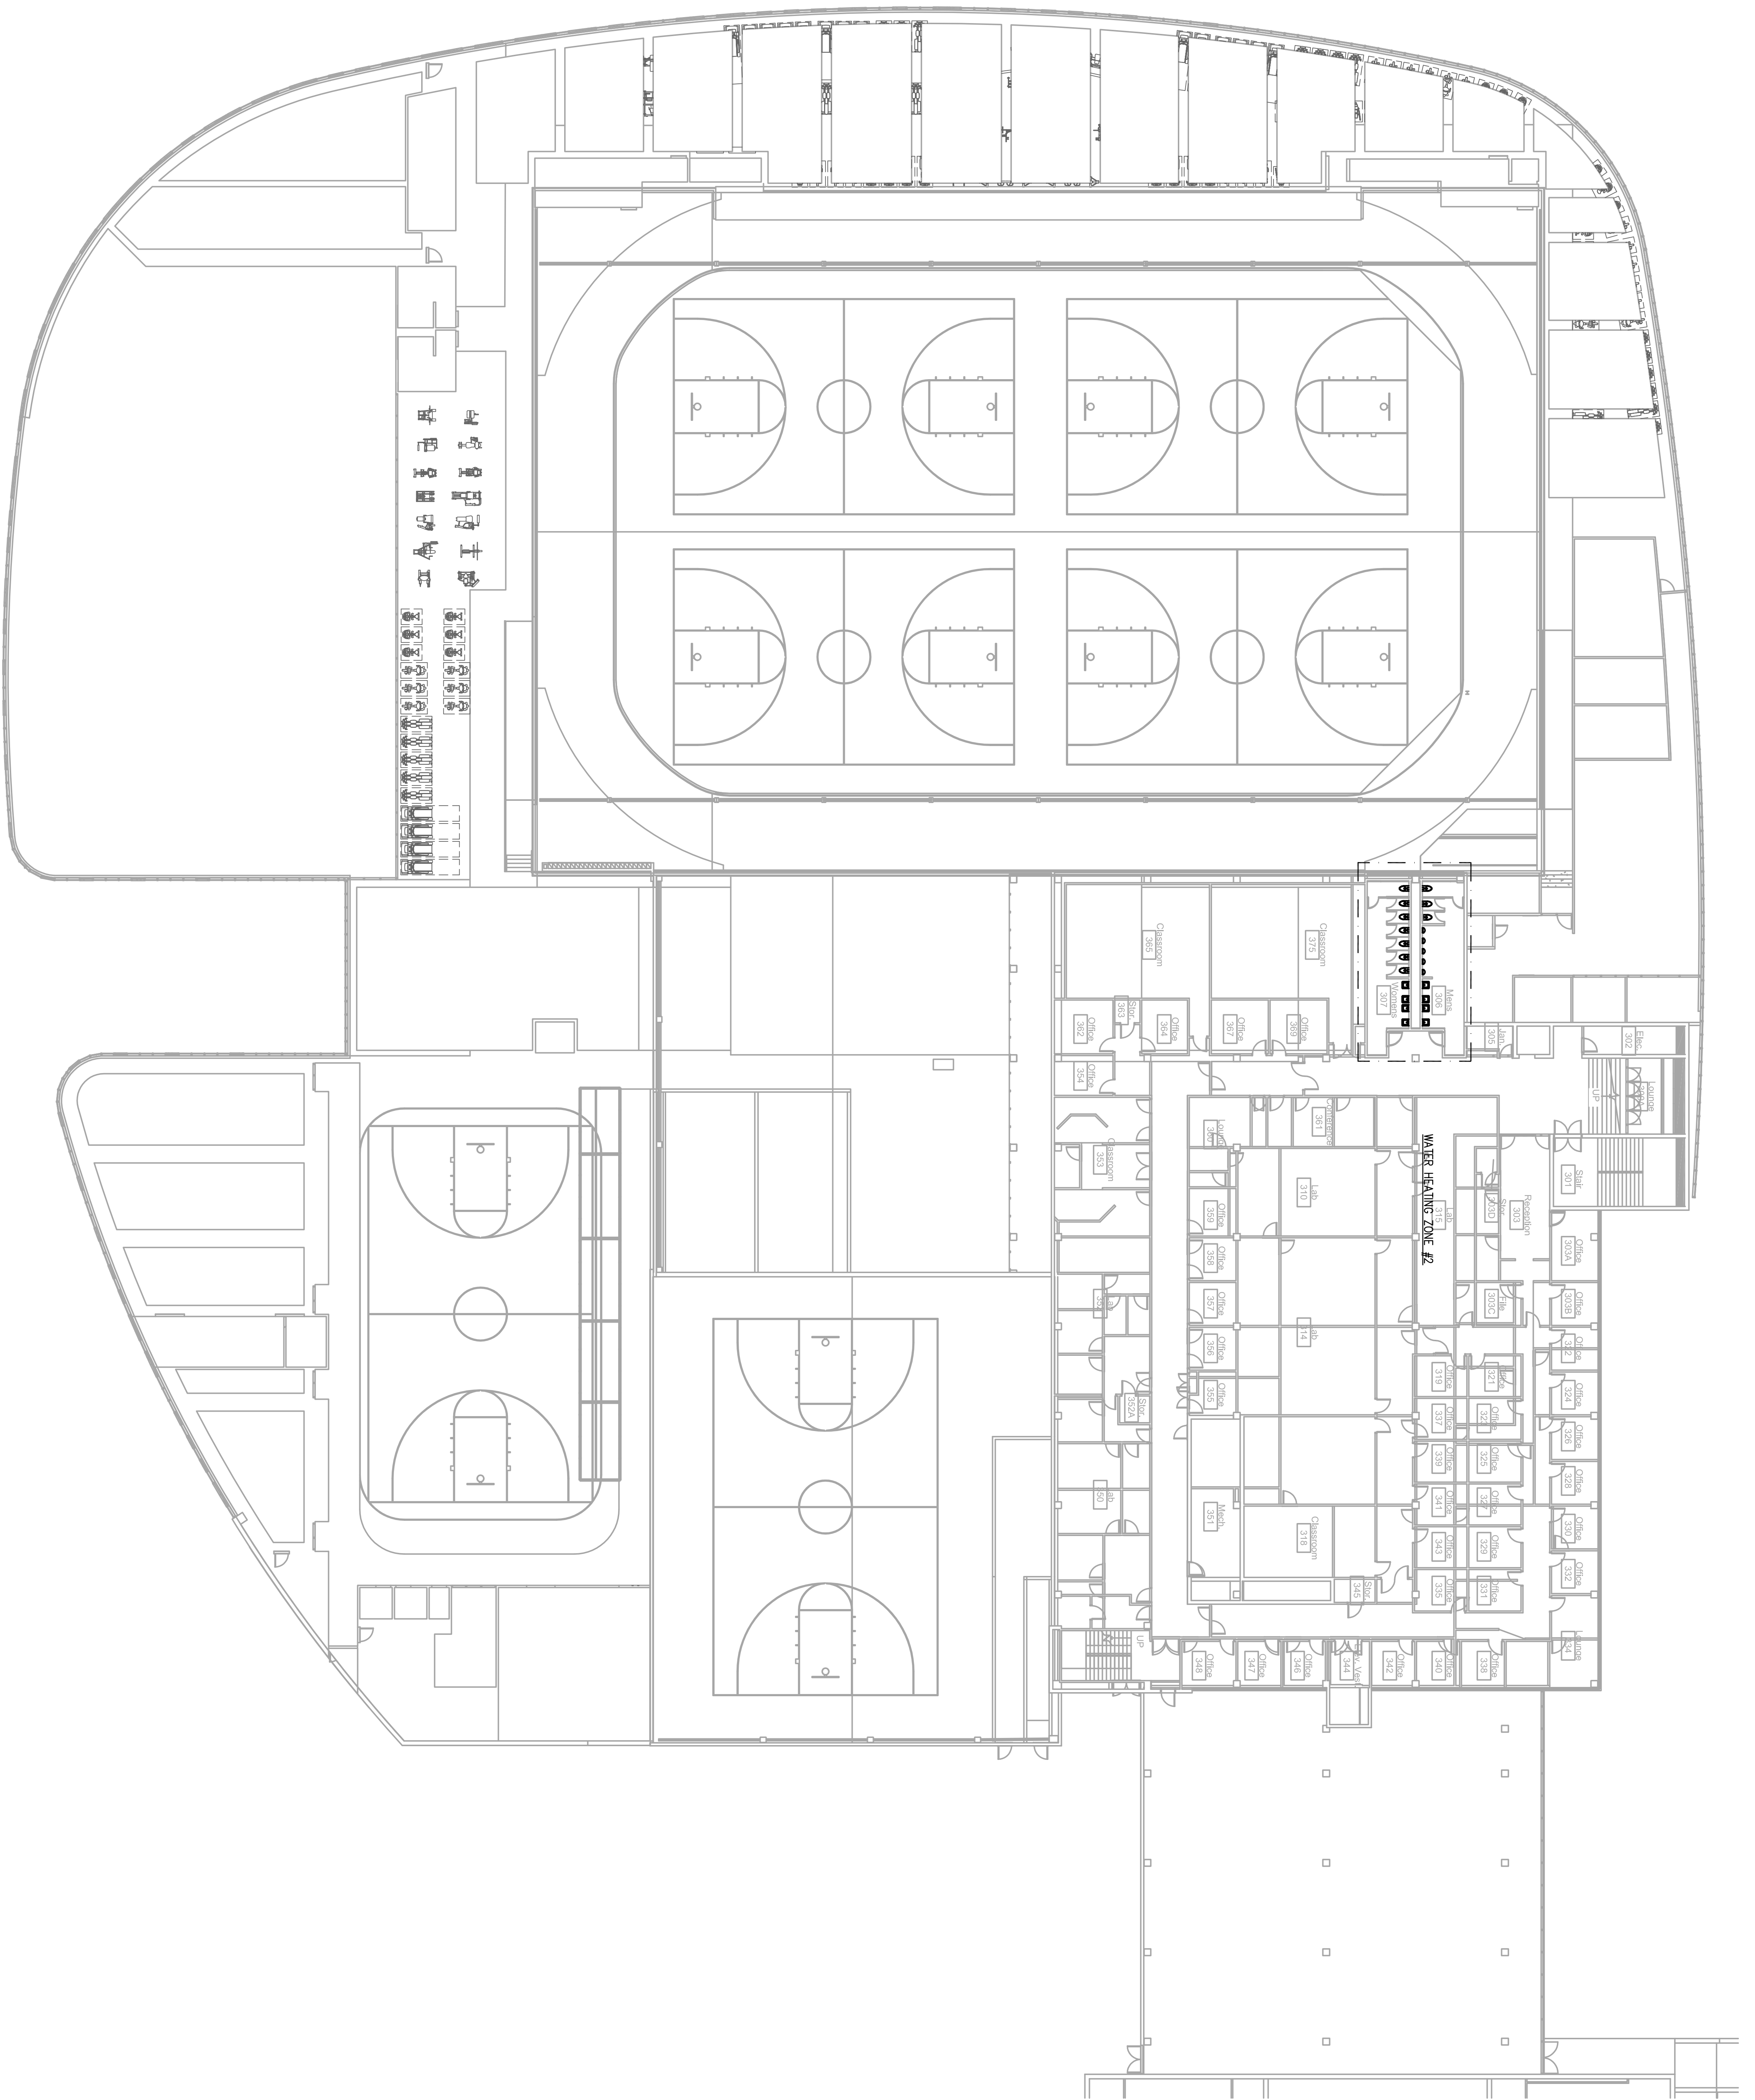

THIRD FLOOR PLAN - PLUMBING
SCALE: 1/16" = 1'-0"

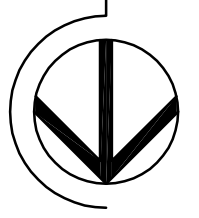

P0103

Northern Kentucky University - Student Recreation Center

Drawing Name:	#	Revision Date
Owner Project Number:	1	
Project Number:	2	03667.00
Date:	3	August 2, 2012
Drawn By:	4	JAT
Checked By:	5	JEF
	6	
	7	
	8	




NORTHERN KENTUCKY UNIVERSITY



212 North Upper Street
Lexington, Kentucky 40507-1001
p 859.252.6664 f 859.253.2358
www.omniarchitects.com

CANNONDESIGN

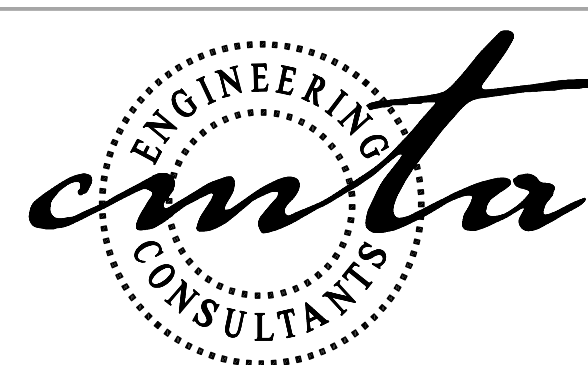

10411 Meeting Street,
Prospect, Kentucky 40059
p 502.326.3085 f 502.326.2691
www.cmtaegr.com

