


RENOVATION OF EXISTING POOL

9400 SF

+

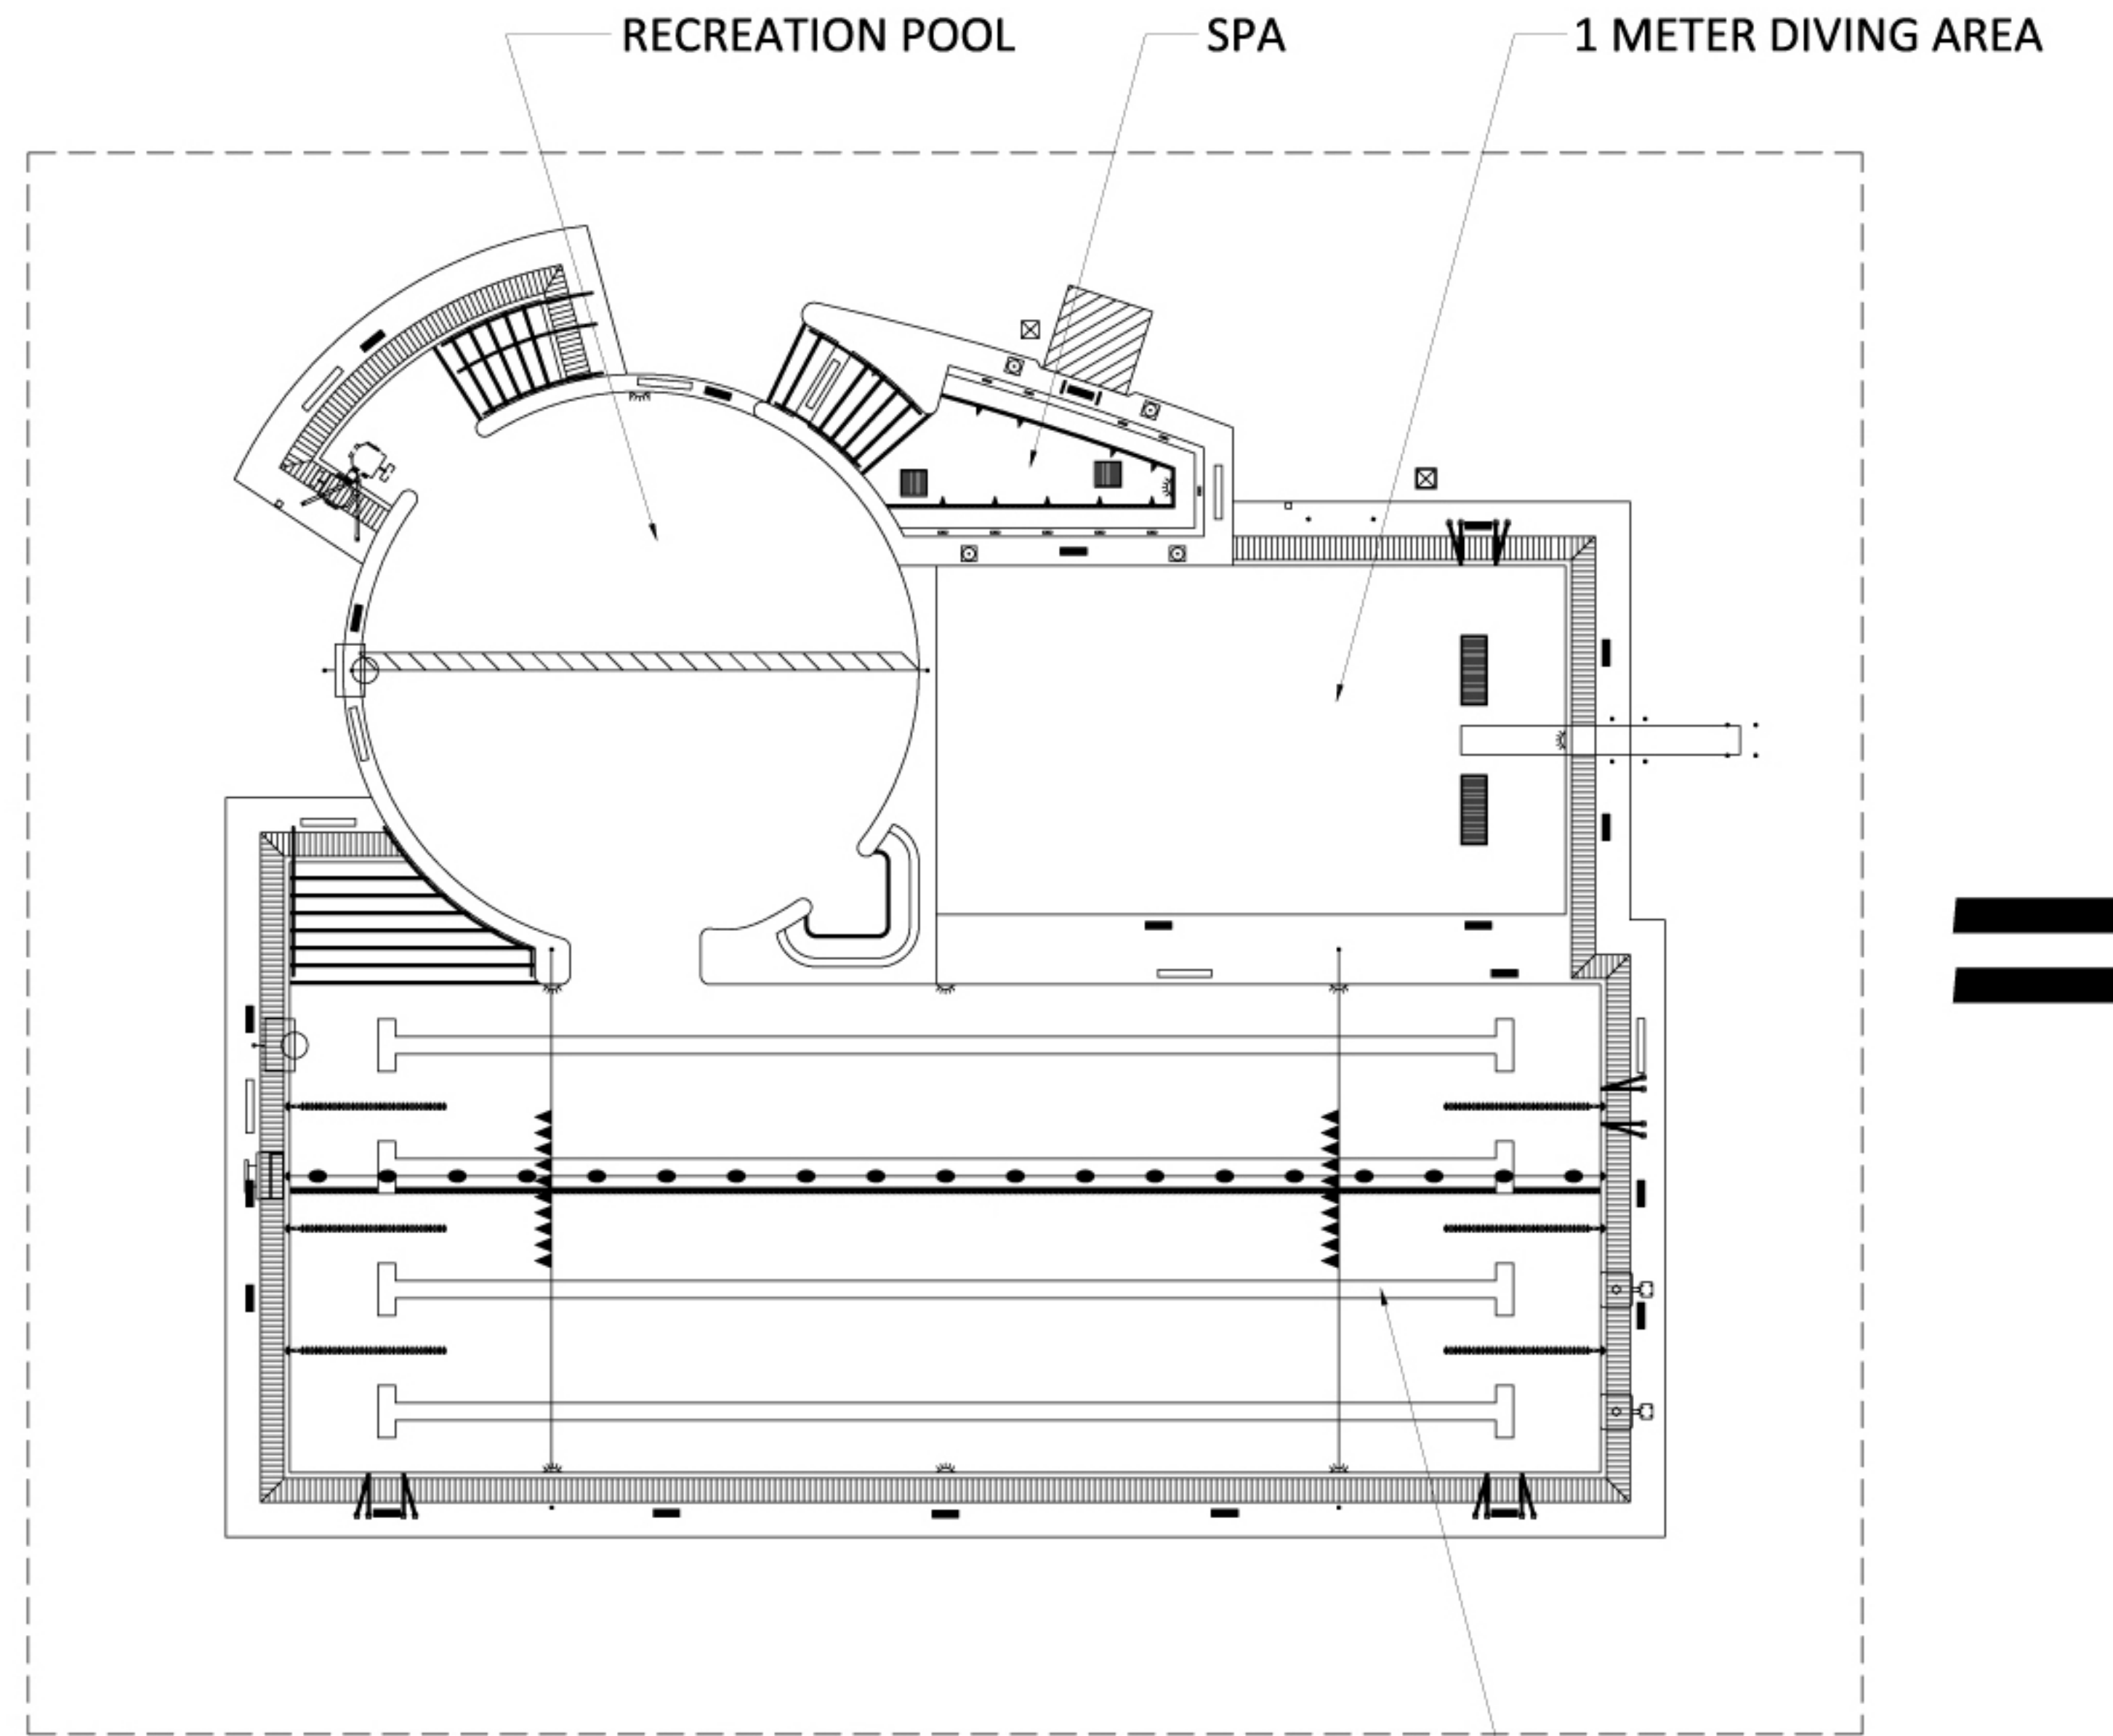

NEW LEISURE/RECREATION POOL CONCEPT

9400 SF

= 2 X BETTER



NKU CAMPUS RECREATION CENTER

- CONSIDER SKYLIGHTS FOR NATURAL DAYLIGHTING
- UPDATE COLORS/FINISHES AND LIGHTS
- MAINTAIN 3 METER DIVING AND 6 SWIMMING LANES
- REFURBISH POOL AND FILTRATION SYSTEM

UNIVERSITY OF DAYTON

- NKU BRANDING (COLORS/LOGO)
- 3 TO 4 ADDITIONAL SWIMMING LANES
- 1 METER DIVING / CLIMBING WALL
- NATURAL LIGHT
- OUTDOOR DECK



# PRE-DESIGN CONCEPT



#	Revision Date

Dra FLOOR PLAN - LEVEL 01

NKU Project Number:

Project Number:

Date:

Drawn By:

Checked By: